




2923 South Tryon Street, Suite 280
Charlotte, North Carolina 28203
Tel: 704.374.0068 Fax: 704.374.0260
MECHANICAL ELECTRICAL PLUMBING

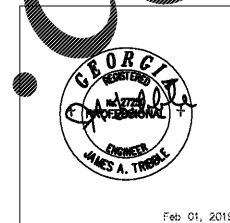

Feb 01, 2019

PLUMBING & GAS ROUGH-IN SCHEDULE											
MARK	R/L	HT.	QTY	CW	HW	SANITARY WASTE	GAS SIZE	GAS: BTUH	ITEM	DESCRIPTION	REMARKS
P-17	W		1			INDIRECT			17	BEVERAGE COUNTER	FLOOR SINK
P-18	W	STUB UP	2			1-1/2"			18	HAND SINK	STUB UP FROM FLOOR IN WALL. STUB OUT WALL AND MAKE FINAL CONNECTION AT SINK DECK.
P-21	W		1			INDIRECT			21	FRONT SERVICE COUNTER	FLOOR SINK
P-29	W		1			INDIRECT			29	HOLDING WRAP STATION	FLOOR SINK
P-35	W		1			INDIRECT			35	BEVERAGE COUNTER	FLOOR SINK
P-47	W		1			INDIRECT			47	T-LINE COUNTER	FLOOR SINK
P-48	W	STUB UP	2			1-1/2"			48	HAND SINK	STUB UP FROM FLOOR IN WALL. STUB OUT WALL AND MAKE FINAL CONNECTION AT SINK DECK.
P-56	W		1			INDIRECT			56	3 COMPARTMENT SINK	FLOOR SINK
P-58	W		2			INDIRECT			58	1 COMPARTMENT SINK	FLOOR SINK
P-87A	W		1			INDIRECT			87A	LOW TEMP. EVAP. COIL	WALL MOUNTED. MAKE SURE DRAINAGE IS MADE TO THE OUTSIDE.
P-88A	W		1			INDIRECT			88A	MEDIUM TEMP. EVAP. COIL	WALL MOUNTED. MAKE SURE DRAINAGE IS MADE TO THE OUTSIDE.
P-98	W		1			INDIRECT			98	SODA SYSTEM	FLOOR DRAIN
P-99	W		1			INDIRECT			99	ICE MAKER	FLOOR SINK
P-PVC	W	STUB UP	4			6" CONDUIT - SEE PVC DETAIL			PVC	SODA LINES	THE LINE SHALL BE UP 8" @ BOTH ENDS.

NOT FOR CONSTRUCTION PRELIM-BUDGET


BOJANGLES' 14 RESTAURANT
HUDSON BRIDGE ROAD
AT WILLIS DRIVE
STOCKBRIDGE, GEORGIA

NOT FOR CONSTRUCTION PRELIM-BUDGET

ISSUE DATE: 02-08-2019
REVISION 1: ---
REVISION 2: ---
REVISION 3: ---
REVISION 4: ---
PROJECT #: 18-164-000
CONTENT: PLUMBING WASTE/VENT FLOOR PLAN
PROJECT ENGINEER: SABER
DRAWN BY: SABER
CADD FILE NAME: ESD-1901-14-P02.dwg

THIS DRAWING AND THE DESIGN SHOWN ARE THE PROPERTY OF BOJANGLES RESTAURANTS, INC. THE REPRODUCTION OR USE OF THIS DRAWING WITHOUT THEIR WRITTEN CONSENT IS PROHIBITED. ANY INFRINGEMENT IS SUBJECT TO LEGAL ACTION.

Sheet P-2

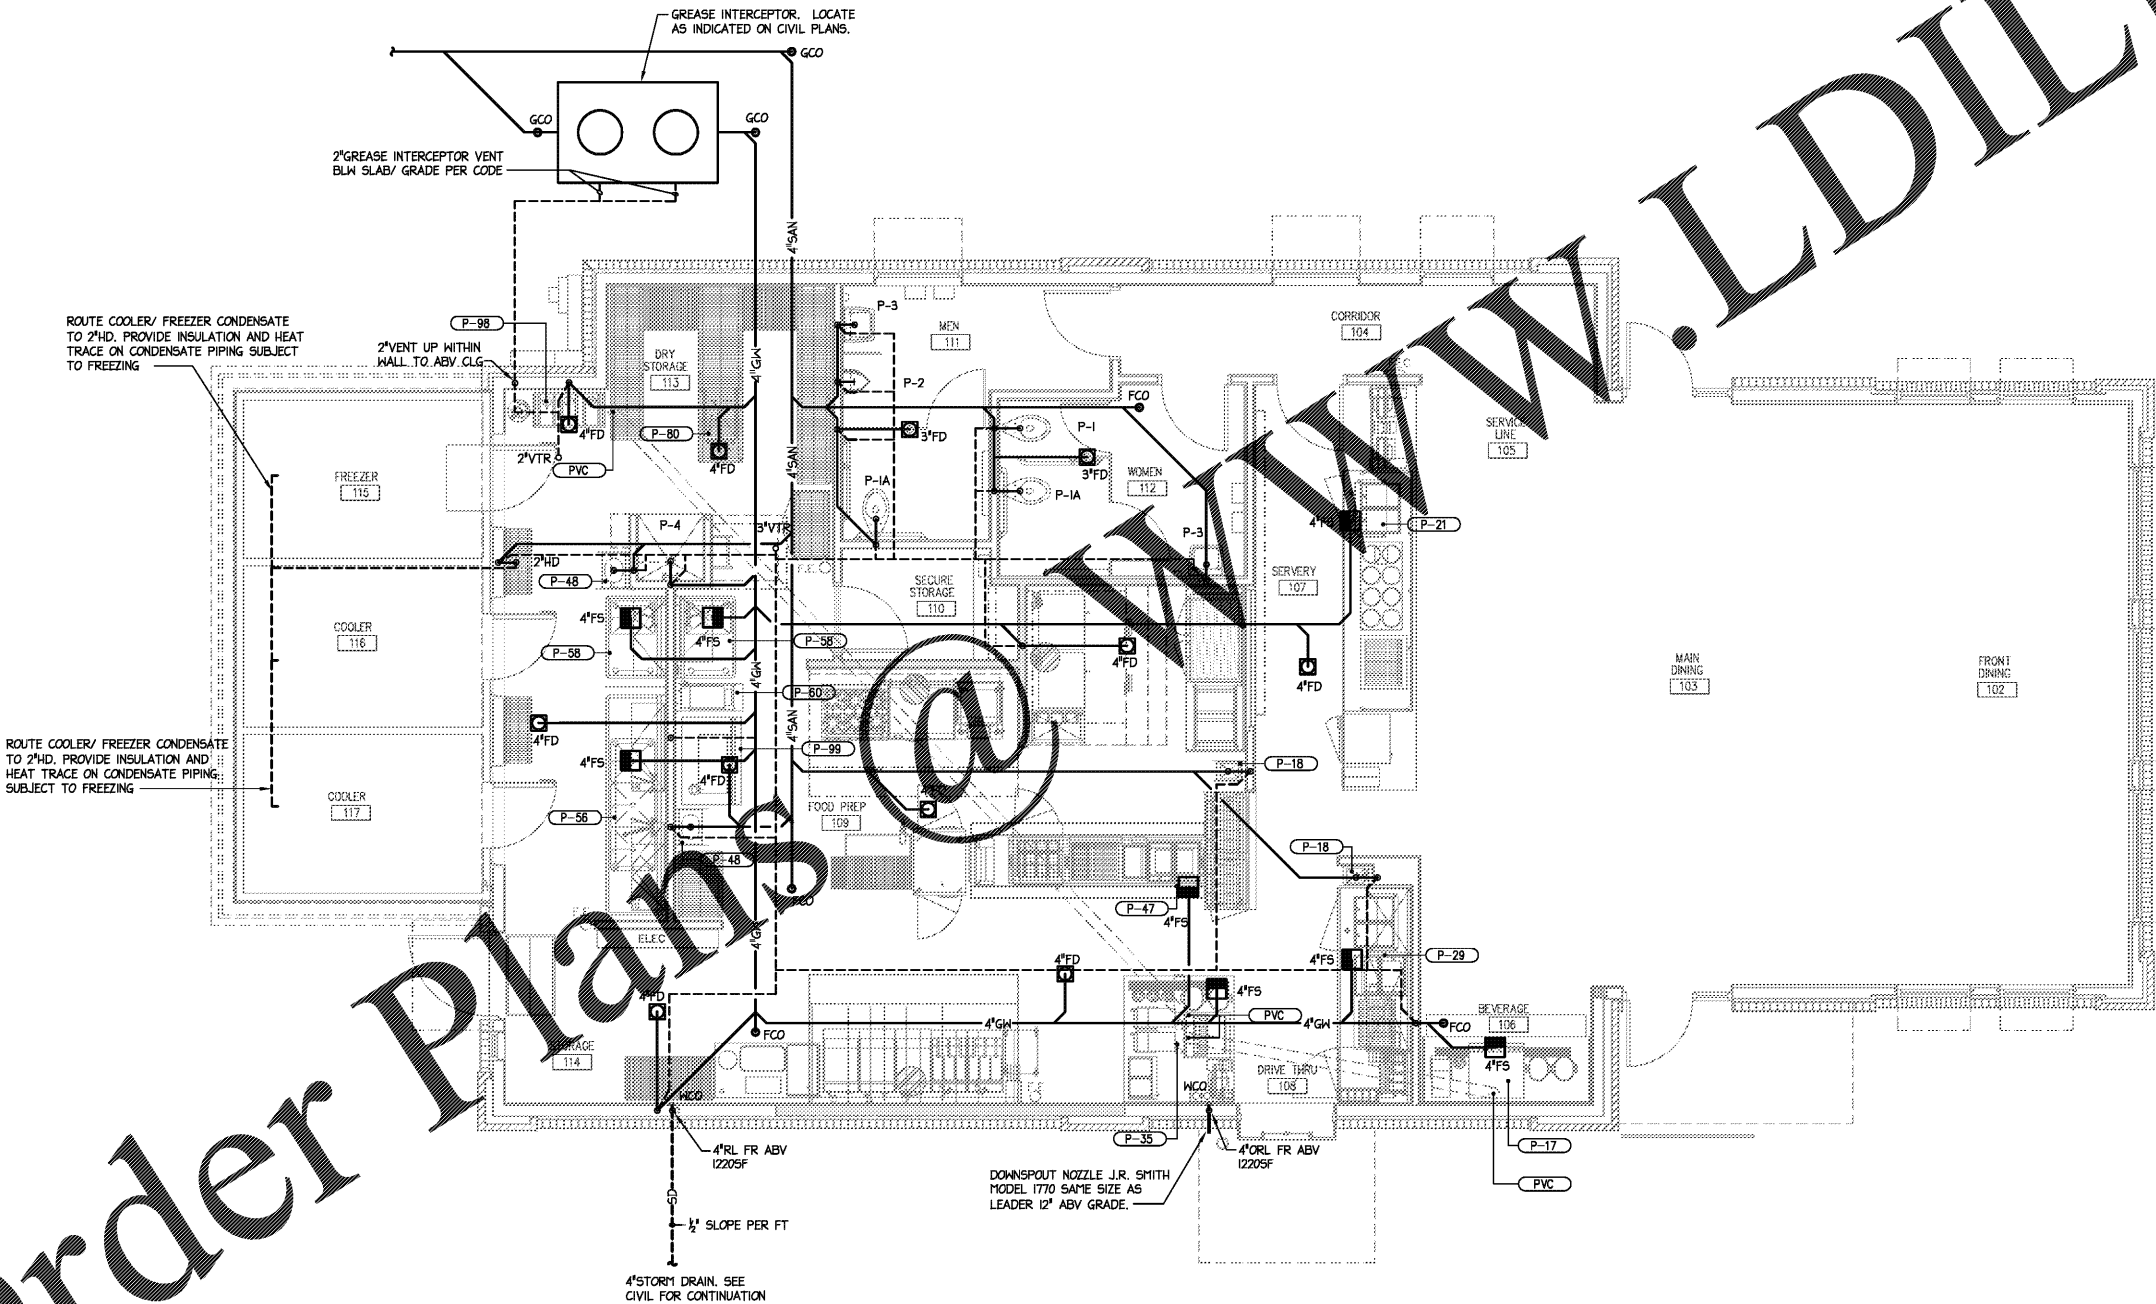

1 PLUMBING FLOOR PLAN - WASTE/VENT PIPING
1/4"=1'-0"

NO COMBUSTIBLE MATERIALS ALLOWED WITH 18" OF KITCHEN HOODS. ALL PIPING LOCATED IN WALLS BEHIND HOODS, AND WITHIN 18" OF HOOD, SHALL BE CONSTRUCTED OF NONCOMBUSTIBLE MATERIALS.

NOTE: IF 1/2" SLOPE NOT POSSIBLE ON SITE, INCREASE HORIZONTAL ROOF DRAIN PIPE SIZE TO 6"

NOTE: PROVIDE 24" DIAMETER DEPRESSION IN CONCRETE SLAB AROUND EACH FLOOR DRAIN.

SEE KITCHEN EQUIPMENT AND/OR ARCHITECTURAL PLANS FOR EXACT PLACEMENT OF FIXTURES.

NO PIPING OR DUCTWORK SHALL BE LOCATED OVER ELECTRICAL PANELS. CONTRACTOR TO VERIFY IN FIELD WITH OTHER TRADES.

THE ARCHITECT/ENGINEER DOES NOT DEFINE THE SCOPE OF INDIVIDUAL TRADES, SUBCONTRACTORS, MATERIAL SUPPLIERS, OR VENDORS. ANY SHEET NUMBERING SYSTEM USED WHICH IDENTIFIES DISCIPLINES IS SOLELY TO SEPARATE ARCHITECT'S AND ENGINEER'S SCOPE. IT DOES NOT DEFINE A SUBCONTRACTOR'S SCOPE OF WORK. ANY DISCREPANCIES BETWEEN DRAWINGS, SPECIFICATIONS, CODES OR CONSTRUCTION SEQUENCING SHALL BE BROUGHT TO THE ATTENTION OF THE ARCHITECT PRIOR TO PROCEEDING. NO CONSIDERATION WILL BE GIVEN TO REQUESTS FOR CHANGE ORDERS FOR FAILURE TO OBTAIN AND REVIEW THE COMPLETE SET OF CONSTRUCTION DOCUMENTS, OR FOR FAILURE TO SEEK INTERPRETATION FROM ARCHITECT FOR DISCREPANCIES.