


2 WASTE ENCLOSURE WATER PLAN
1/4"=1'-0"

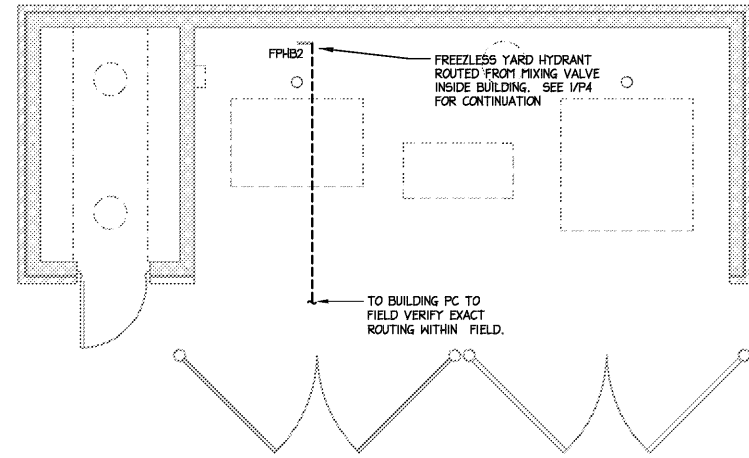

3 WASTE ENCLOSURE W/STORAGE WATERPLAN
1/4"=1'-0"


PLUMBING SCHEDULE									
MARK	R.I. HT.	QTY	CW	HW	SANITARY WASTE	ITEM	DESCRIPTION	REMARKS	
P-17D-C	24"	1	1/2"			17D	ICE MAKER W/O BIN	BRANCH THRU WATER FILTER	
P-17H-C	24"	1	1/2"			17H	COFFEE BREWER	VERIFY OPERATIONS. VERIFY THE SIZE AND LOCATION WITH OPERATIONS. BRANCH THRU WATER FILTER	
P-17L-C	24"	1	1/2"			17L	SODA/ICE DISPENSER	VERIFY OPERATIONS. VERIFY THE SIZE AND LOCATION WITH OPERATIONS. BRANCH THRU WATER FILTER	
P-18-H	24"	2		1/2"		18	HAND SINK	BRANCH TO CONNECTION	
P-21-C	24"	2	1/2"			21	FRONT SERVICE COUNTER	BRANCH TO CONNECTION	
P-35F-C	16"	1	1/2"			35F	SODA TOWER	VERIFY OPERATIONS. VERIFY THE SIZE AND LOCATION WITH OPERATIONS. BRANCH THRU WATER FILTER	
P-35K-C	54"	1	1/2"			35K	COFFEE BREWER	VERIFY OPERATIONS. VERIFY THE SIZE AND LOCATION WITH OPERATIONS. BRANCH THRU WATER FILTER	
P-47-C	-	1	1/2"			47	T-LINE COUNTER	CAPPED FOR FUTURE	
P-48-H	SU	3		1/2"		48	HAND SINK	BRANCH TO CONNECTION	
P-56-C	16"	1	1/2"			56	THREE COMPARTMENT SINK	BRANCH TO CONNECTION	
P-58-H	16"	1		1/2"		58	THREE COMPARTMENT SINK	BRANCH TO CONNECTION	
P-58-C	16"	2	1/2"			58	ONE COMPARTMENT SINK	BRANCH TO CONNECTION	
P-58-H	16"	2		1/2"		58	ONE COMPARTMENT SINK	BRANCH TO CONNECTION	
P-60-C	38"	1	1/2"			60	HOT WATER DISPENSER	BRANCH THRU WATER FILTER	
P-98-C	86"	1	1/2"			98	SODA SYSTEM	BRANCH THRU WATER FILTER	
P-99-C	72"	1	1/2"			99	ICE MAKER	BRANCH THRU WATER FILTER	

SABER ENGINEERING
2923 South Tryon Street Suite 280
Charlotte, North Carolina 28203
Tel: 704.374.0068 Fax: 704.374.0260
MECHANICAL ELECTRICAL PLUMBING

GEORGIA REGISTERED PROFESSIONAL ENGINEER
MAES A. TREBBL

Feb 01, 2019

architecture - interior design
421 Penman Street, Suite 200, Charlotte, NC 28203
Email: esd@esdarch.com • Phone: 704-373-1900

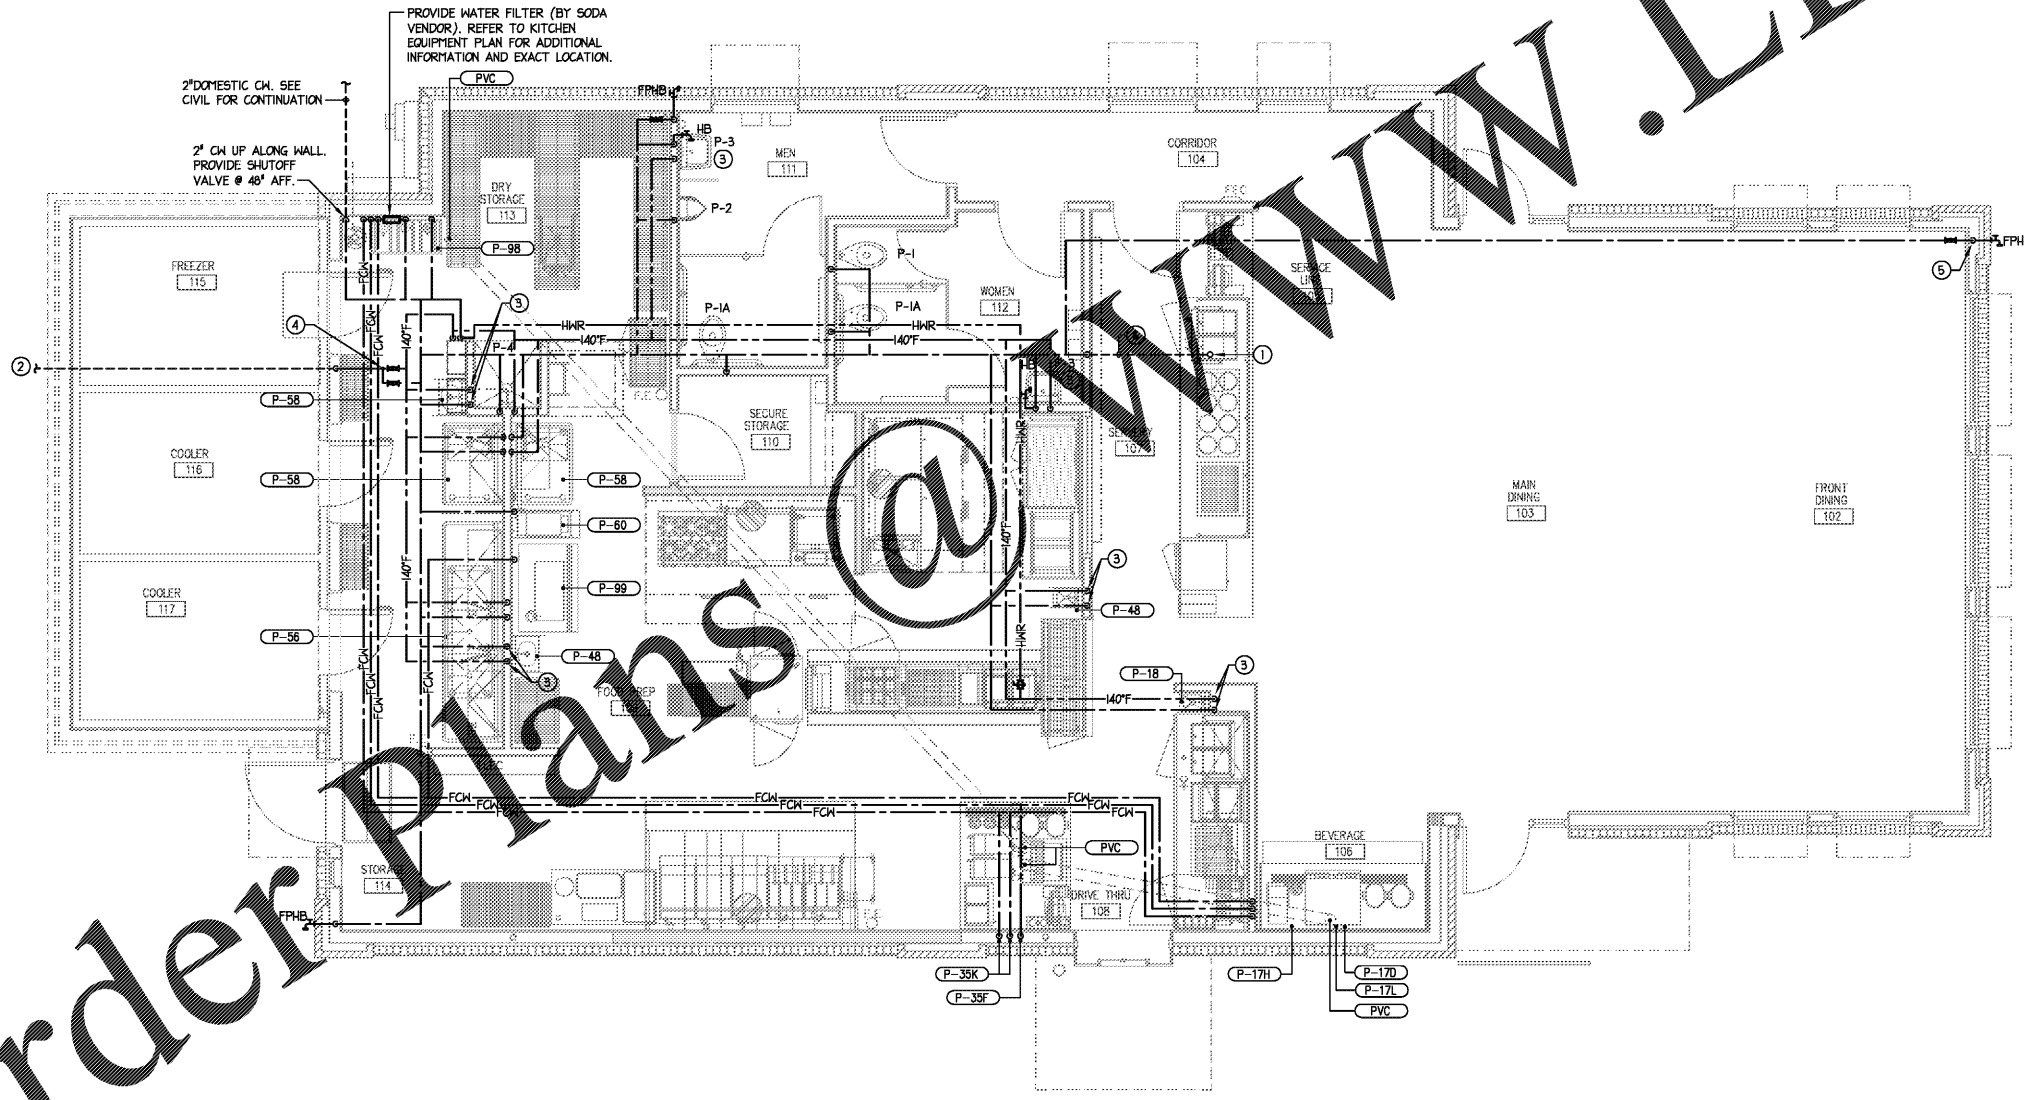

1 PLUMBING FLOOR PLAN - WATER PIPING
1/4"=1'-0"

NOTE:
REFER TO RISER DIAGRAMS FOR ADDITIONAL INFORMATION.

- PLUMBING KEY NOTES:**
- 1/2" CW CAPPED FOR FUTURE @ 0'-4" AFF.
 - 3/4" WATER ON TO BLW SLAB. 3/4" WATER TO SERVE OUTDOOR FREEZE-PROOF GROUND HYDRANT (FPHB-2) AT DUMPSTER. PROVIDE VACUUM BREAKER ON DISCHARGE PIPE.
 - PROVIDE 'SYMMONS' POINT-OF-USE MIXING VALVE, FACTORY PRESET @ 110°F.
 - MIXING VALVE TO PROVIDE 110°F WATER AT TRASH ENCLOSURE HYDRANT.
 - LOCATE HOSE BIBB BELOW THE UPPER WAINSCOTT BUMP OUT. REFER TO ARCHITECT DRAWINGS.
 - PIPING BLW SLAB SHALL BE SLEEVED/ ENCASED AS REQUIRED PER CODE.

* SEE KITCHEN AND/OR ARCHITECTURAL PLANS FOR EXACT KITCHEN EQUIPMENT LOCATIONS AND ADDITIONAL INFORMATION. PC TO VERIFY/ COORDINATE ALL KITCHEN EQUIPMENT CONNECTIONS WITH KITCHEN CONSULTANT.

NO COMBUSTIBLE MATERIALS ALLOWED WITH 18" OF KITCHEN HOODS. ALL PIPING LOCATED IN WALLS BEHIND HOODS, AND WITHIN 18" OF HOOD, SHALL BE CONSTRUCTED OF NONCOMBUSTIBLE MATERIALS.

NO PIPING OR DUCTWORK SHALL BE LOCATED OVER ELECTRICAL PANELS. CONTRACTOR TO VERIFY IN FIELD WITH OTHER TRADES.

THE ARCHITECT/ENGINEER DOES NOT DEFINE THE SCOPE OF INDIVIDUAL TRADES, SUBCONTRACTORS, MATERIAL SUPPLIERS, OR VENDORS. ANY SHEET NUMBERING SYSTEM USED WHICH IDENTIFIES DISCIPLINES IS SOLELY TO SEPARATE ARCHITECT'S AND ENGINEER'S SCOPE; IT DOES NOT DEFINE A SUBCONTRACTOR'S SCOPE OF WORK. ANY DISCREPANCIES BETWEEN DRAWINGS, SPECIFICATIONS, CODES OR CONSTRUCTION SEQUENCING SHALL BE BROUGHT TO THE ATTENTION OF THE ARCHITECT PRIOR TO PROCEEDING. NO CONSIDERATION WILL BE GIVEN TO REQUESTS FOR CHANGE ORDERS FOR FAILURE TO OBTAIN AND REVIEW THE COMPLETE SET OF CONSTRUCTION DOCUMENTS, OR FOR FAILURE TO SEEK INTERPRETATION FROM ARCHITECT FOR DISCREPANCIES.

NOT FOR CONSTRUCTION
PRELIM-BUDGET

BOJANGLES' 14 RESTAURANT
HUDSON BRIDGE ROAD
AT WILLIS DRIVE
STOCKBRIDGE, GEORGIA

NOT FOR CONSTRUCTION
PRELIM-BUDGET

ISSUE DATE: 02-08-2019
REVISION 1: _____
REVISION 2: _____
REVISION 3: _____
REVISION 4: _____
PROJECT #: 18-164-000
CONTENT: PLUMBING FLOOR PLAN WATER PIPING
PROJECT ENGINEER: SABER
DRAWN BY: _____
CADD FILE NAME: ESD-1901-14-P04.dwg

THIS DRAWING AND THE DESIGN SHOWN ARE THE PROPERTY OF BOJANGLES RESTAURANTS, INC. THE REPRODUCTION OR USE OF THIS DRAWING WITHOUT THEIR WRITTEN CONSENT IS PROHIBITED. ANY INFRINGEMENT IS SUBJECT TO LEGAL ACTION.