



SABER ENGINEERING
 2923 South Tryon Street Suite 280
 Charlotte, North Carolina 28203
 Tel: 704.374.0068 Fax: 704.374.0260
 MECHANICAL ELECTRICAL PLUMBING



Feb 01, 2019

architecture • interior design
 421 Penman Street, Suite 200, Charlotte, NC 28203
 Email: esd@esdarch.com • Phone: 704-373-1900

NOT FOR CONSTRUCTION PRELIM-BUDGET

BOJANGLES' 14 RESTAURANT
 HUDSON BRIDGE ROAD
 AT WILLIS DRIVE
 STOCKBRIDGE, GEORGIA

NOT FOR CONSTRUCTION PRELIM-BUDGET

ISSUE DATE: 02-08-2019

REVISION 1: --
 REVISION 2: --
 REVISION 3: --
 REVISION 4: --


PROJECT #: 18-164-000
 CONTENT: PLUMBING
 ROOF PLAN

PROJECT ENGINEER: SABER
 DRAWN BY: SABER

CADD FILE NAME: ESD-1901-14-P05.dwg

THIS DRAWING AND THE DESIGN SHOWN ARE THE PROPERTY OF BOJANGLES RESTAURANTS, INC. THE REPRODUCTION OR USE OF THIS DRAWING WITHOUT THEIR WRITTEN CONSENT IS PROHIBITED. ANY INFRINGEMENT IS SUBJECT TO LEGAL ACTION.

Sheet P-5

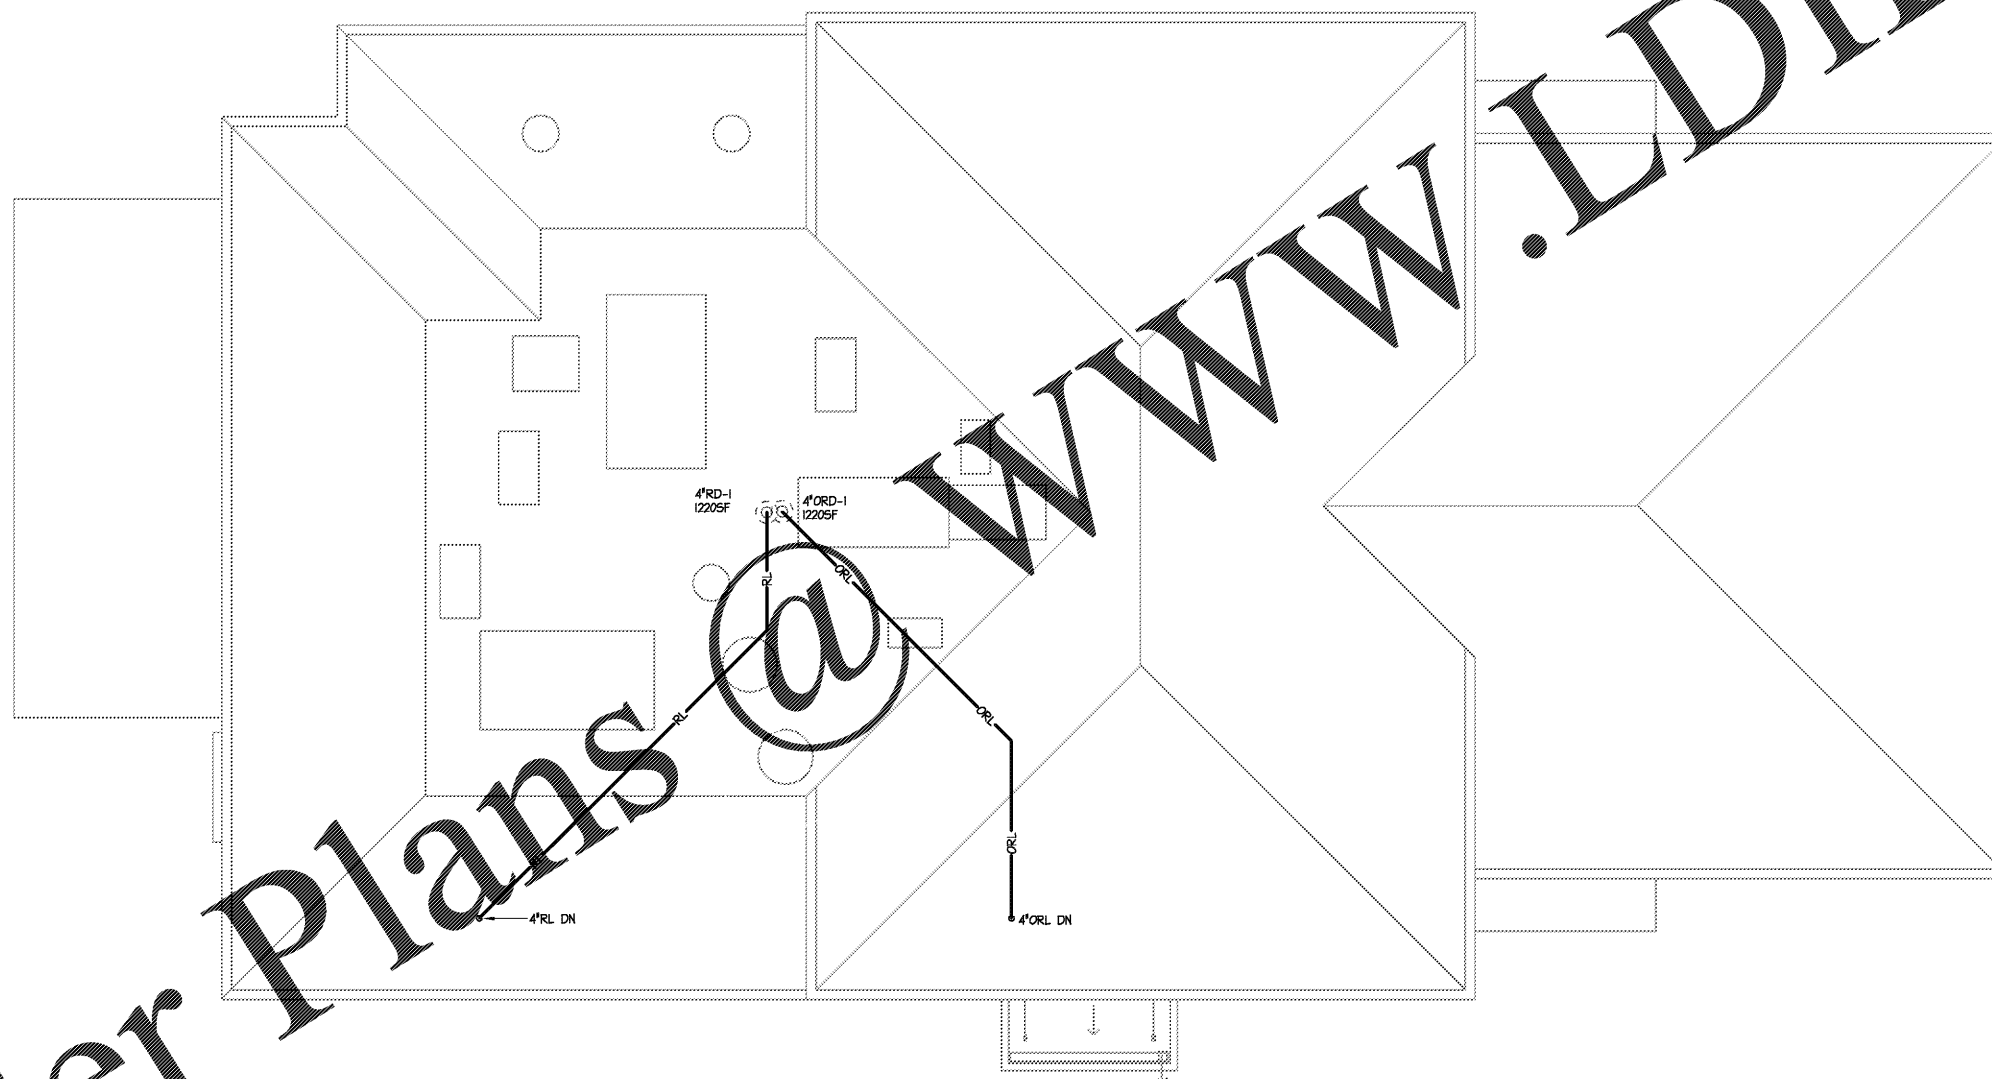

1 PLUMBING ROOF PLAN
 1/4"=1'-0"

NOTE:
 REFER TO ARCHITECTURAL PLANS FOR OVERFLOW SCUPPER INFORMATION.

NO COMBUSTIBLE MATERIALS ALLOWED WITH IN 18" OF KITCHEN HOODS. ALL PIPING LOCATED IN WALLS BEHIND HOODS, AND WITHIN 18" OF HOOD, SHALL BE CONSTRUCTED OF NONCOMBUSTIBLE MATERIALS.

ROOF LEADERS SHALL BE 1/2" PER FT. SLOPE UNLESS OTHERWISE SPECIFIED

SIZING BASED ON 5"RAINFALL RATE PER 2012 STATE PLUMBING CODE.

NO PIPING OR DUCTWORK SHALL BE LOCATED OVER ELECTRICAL PANELS. CONTRACTOR TO VERIFY IN FIELD WITH OTHER TRADES.

THE ARCHITECT/ENGINEER DOES NOT DEFINE THE SCOPE OF INDIVIDUAL TRADES, SUBCONTRACTORS, MATERIAL SUPPLIERS, OR VENDORS. ANY SHEET NUMBERING SYSTEM USED WHICH IDENTIFIES DISCIPLINES IS SOLELY TO SEPARATE ARCHITECT'S AND ENGINEER'S SCOPE; IT DOES NOT DEFINE A SUBCONTRACTOR'S SCOPE OF WORK. ANY DISCREPANCIES BETWEEN DRAWINGS, SPECIFICATIONS, CODES OR CONSTRUCTION SEQUENCING SHALL BE BROUGHT TO THE ATTENTION OF THE ARCHITECT PRIOR TO PROCEEDING. NO CONSIDERATION WILL BE GIVEN TO REQUESTS FOR CHANGE ORDERS FOR FAILURE TO OBTAIN AND REVIEW THE COMPLETE SET OF CONSTRUCTION DOCUMENTS, OR FOR FAILURE TO SEEK INTERPRETATION FROM ARCHITECT FOR DISCREPANCIES.

Order Plans @ www.LDILine.com