



architecture + interior design  
 421 Penman Street, Suite 200, Charlotte, NC 28203  
 Email: esd@esdarch.com • Phone: 704-373-1900

NOT FOR CONSTRUCTION  
 PRELIM-BUDGET

BOJANGLES' 14 RESTAURANT  
 HUDSON BRIDGE ROAD  
 AT WILLIS DRIVE  
 STOCKBRIDGE, GEORGIA

NOT FOR CONSTRUCTION  
 PRELIM-BUDGET

ISSUE DATE: 02-08-2019

REVISION 1: \_\_\_\_\_  
 REVISION 2: \_\_\_\_\_  
 REVISION 3: \_\_\_\_\_  
 REVISION 4: \_\_\_\_\_

PROJECT #: 18-164-000  
 CONTENT: ELECTRICAL  
 ROOF PLAN

PROJECT ENGINEER: SABER

DRAWN BY: RPL

CADD FILE NAME:  
 ESD-1901-14-E05.dwg


THIS DRAWING AND THE DESIGN SHOWN ARE THE PROPERTY OF BOJANGLES RESTAURANT'S INC. THE REPRODUCTION OR USE OF THIS DRAWING WITHOUT THEIR WRITTEN CONSENT IS PROHIBITED. ANY INFRINGEMENT IS SUBJECT TO LEGAL ACTION.

Sheet

E-5

NO COMBUSTIBLE MATERIALS ALLOWED WITH 18" OF KITCHEN HOODS. ALL PIPING LOCATED IN WALLS BEHIND HOODS, AND WITHIN 18" OF HOOD, SHALL BE CONSTRUCTED OF NONCOMBUSTIBLE MATERIALS.

NO PIPING OR DUCTWORK SHALL BE LOCATED OVER ELECTRICAL PANELS. CONTRACTOR TO VERIFY IN FIELD WITH OTHER TRADES.

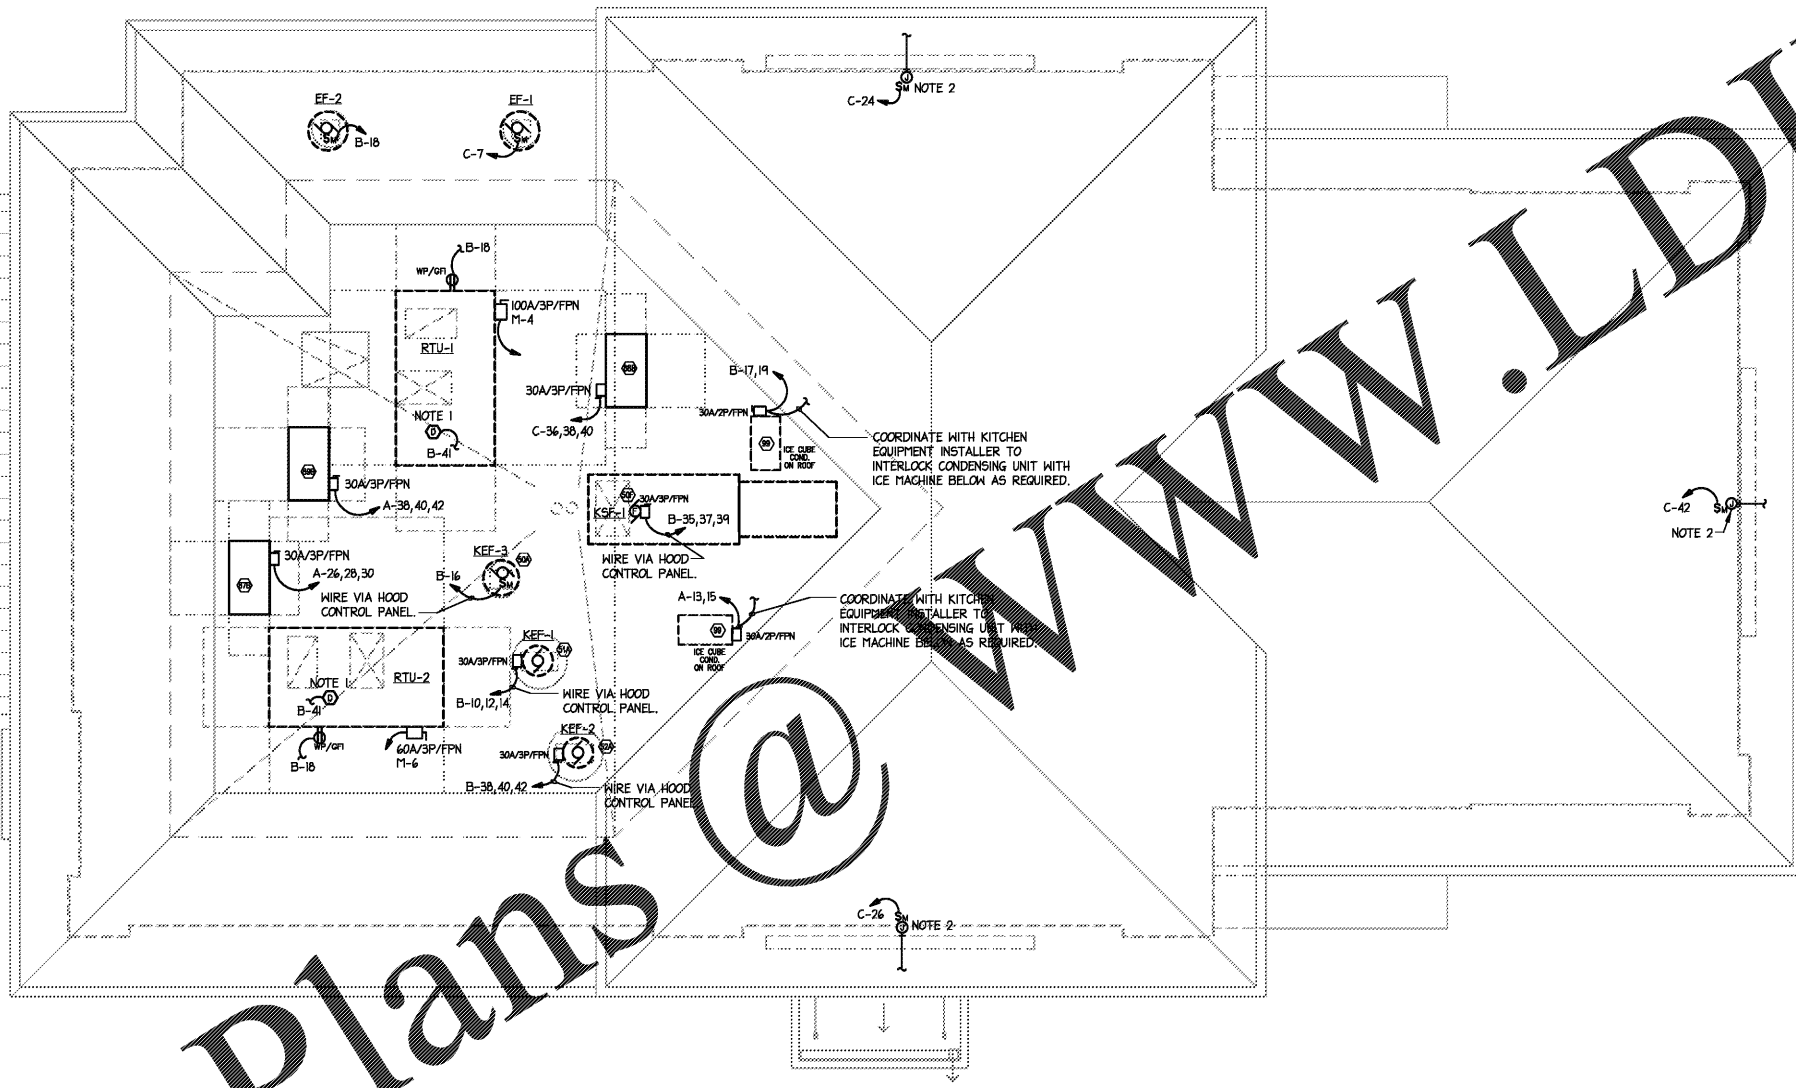

**1 ELECTRICAL ROOF PLAN**  
 1/4"=1'-0"

- NOTES:
- DUCT DETECTORS PROVIDED AND WIRED BY E.C., INSTALLED BY M.C. SEE DETAIL 6/E-5 FOR WIRING DIAGRAM.
  - PROVIDE 120V CONNECTION FOR SIGN. FIELD COORDINATE EXACT CONNECTION REQUIREMENTS AND LOCATION WITH G.C./SIGN INSTALLER. PROVIDE DISCONNECTING MEANS AS REQUIRED.

THE ARCHITECT/ENGINEER DOES NOT DEFINE THE SCOPE OF INDIVIDUAL TRADES, SUBCONTRACTORS, MATERIAL SUPPLIERS, OR VENDORS. ANY SHEET NUMBERING SYSTEM USED WHICH IDENTIFIES DISCIPLINES IS SOLELY TO SEPARATE ARCHITECTS AND ENGINEERS SCOPE. IT DOES NOT DEFINE A SUBCONTRACTOR'S SCOPE OF WORK. ANY DISCREPANCIES BETWEEN DRAWINGS, SPECIFICATIONS, CODES OR CONSTRUCTION SEQUENCING SHALL BE BROUGHT TO THE ATTENTION OF THE ARCHITECT PRIOR TO PROCEEDING. NO CONSIDERATION WILL BE GIVEN TO REQUESTS FOR CHANGE ORDERS FOR FAILURE TO OBTAIN AND REVIEW THE COMPLETE SET OF CONSTRUCTION DOCUMENTS, OR FOR FAILURE TO SEEK INTERPRETATION FROM ARCHITECT FOR DISCREPANCIES.

Order Plans @

WWW.LDLine.com