


KEY PLAN

REFER TO SHEET E4.1 FOR GENERAL AND KEY PLAN.

INTERPLAN
ARCHITECTURE
ENGINEERING
INTERIOR DESIGN
PROJECT MANAGEMENT

404 COURTLAND STREET
SUITE 1
ORLANDO, FLORIDA 32803
PH: 407.253.1238
FAX: 407.253.1274

THIS DOCUMENT IS NOT
A REGULATORY
APPROVAL PERMITTING
OR CONSTRUCTION.

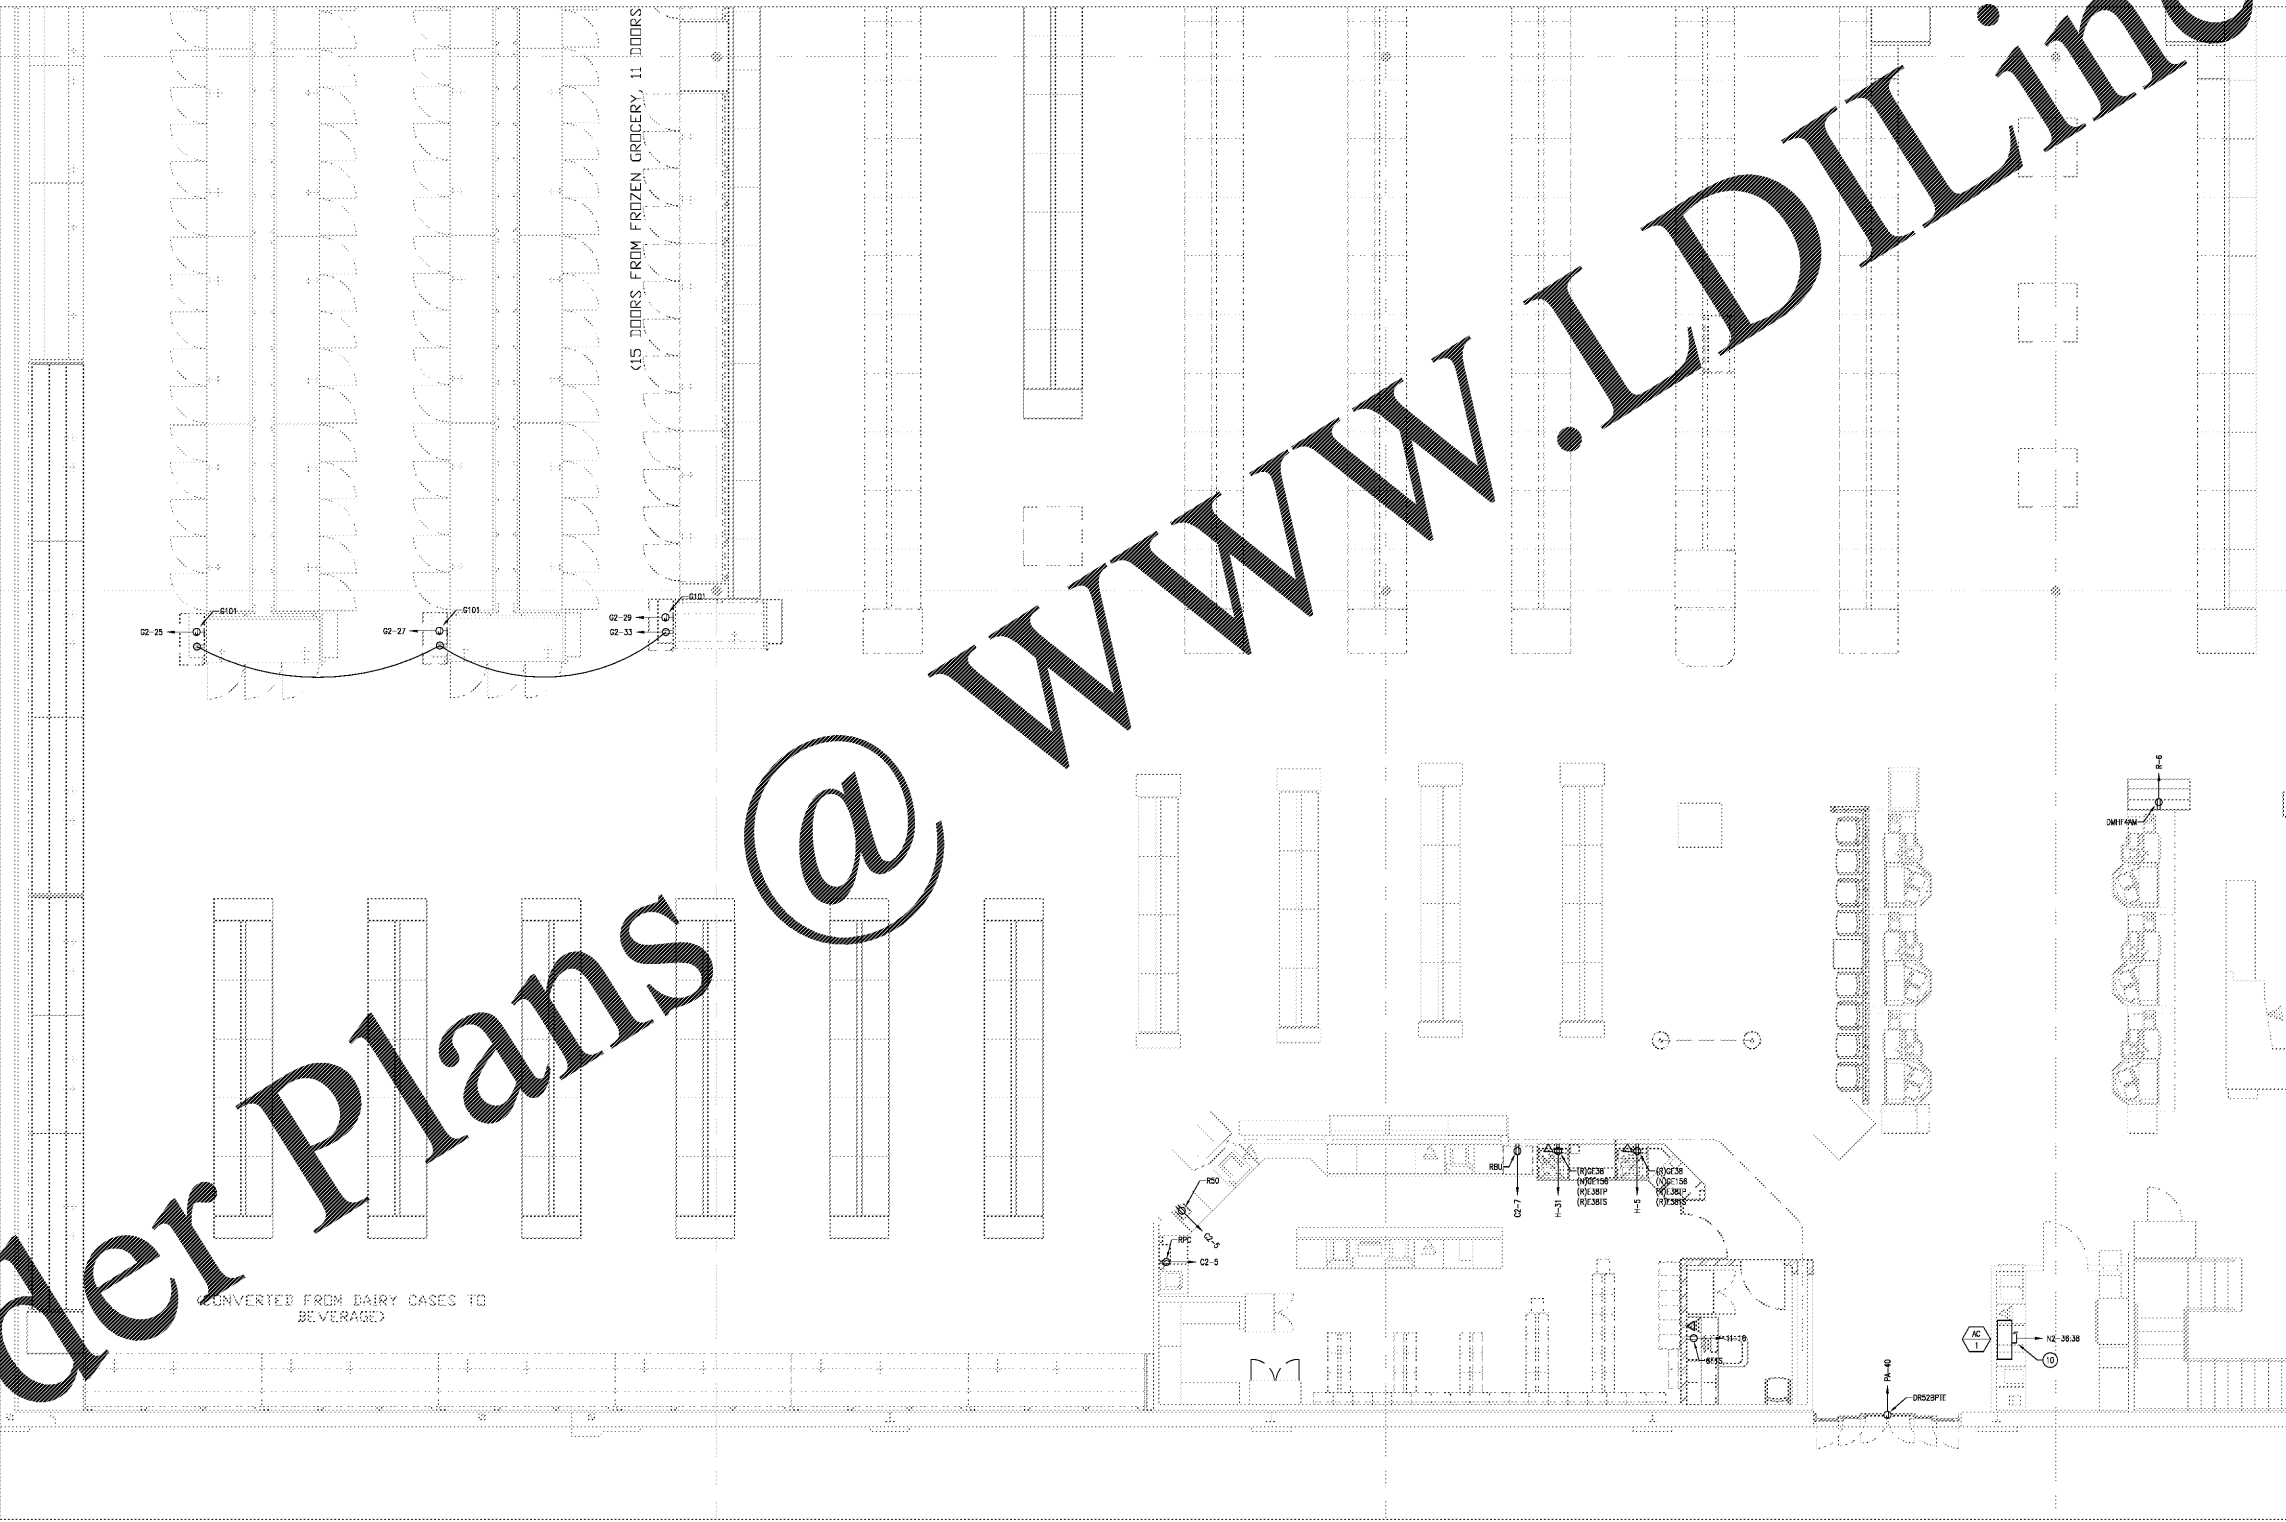

Order Plans @ www.LDILine.com

A WITHIN THE WALLS REMODEL FOR:
KROGER STORE # 443 - LOGANVILLE
910 ATHENS HWY.
LOGANVILLE, GA 30052



NO DATE REVISIONS
REVISIONS
PROJECT NO: 2018.1168
DATE: 01.23.2019

E4.4
ELECTRICAL POWER PLAN

CHECKED: DS DRAWN: VLD

COPYRIGHT © 2019 INTERPLAN, LLC. ALL RIGHTS RESERVED. THIS DOCUMENT IS THE PROPERTY OF INTERPLAN, LLC. NO PART OF THIS DOCUMENT IS TO BE REPRODUCED, COPIED, OR TRANSMITTED IN ANY FORM OR BY ANY MEANS, WITHOUT THE WRITTEN PERMISSION OF INTERPLAN, LLC.