

Order Plans @

WWW.LDILLINO.COM


Chubb & Peterson
 Planners
 Architects
 1800 West 10th Street
 Tallahassee, FL 32310
 Phone: 904.438.1414
 Fax: 904.438.1415
 Email: info@chubb.com

GENERAL NOTES:

- ELECTRICAL CONTRACTOR TO PROVIDE CONDUIT, OUTLET/BACK BOX AND PULL STRING TO ABOVE ACCESSIBLE CEILING FOR ALL DEVICES, PANELS AND OTHER ELECTRICAL EQUIPMENT. LOCATED IN WALL OR HARD CEILING SPACES.
- ALL SECURITY SYSTEM PANELS & DEVICES, CAMERAS, SPEAKERS, AND ASSOCIATED WIRING SUPPLIED AND INSTALLED BY WAWA SECURITY CONTRACTOR.
- CONNECTION BETWEEN SECURITY CAMERA SYSTEM AND FIRE ALARM SYSTEM PANEL SHALL BE A 2 GAUGE 2 PHAS.
- ELECTRICAL CONTRACTOR SHALL PROVIDE (1)18-2 AND (1)18-3 COAX CABLE TO EACH SECURITY CAMERA FROM CAMERA POWER SUPPLY. PROVIDE 2 WHITE 18-2 CONDUCTORS FOR POWER SUPPLY. PHONE LINES PROVIDED BY OTHERS, E.C. TO PROVIDE CONDUIT, BOX AND PULL STRING TO ACCESSIBLE ABOVE CEILING SPACE.
- EXTERIOR WALL MOUNTED CAMERAS (NOT UNDER OVERHANGS) TO BE MOUNTED AT HEIGHT OF 14 FEET.

KEYNOTES:

- SECURITY CONTRACTOR TO MOUNT OUTSIDE VESTIBULE DOORS 9 AND 10 VIEWING GAS PUMPS. FOR EXACT LOCATION OF DEVICES IN MANAGERS OFFICE, RE. SHEET AS 2.
- SECURITY CONTRACTOR SHALL MOUNT SECURITY SYSTEM PANELS IN OFFICE CEILING. IN WALL OR METAL STRIP IN RESTROOM OFFICE.
- TRASH CANS TO BE RELEASE BUTTON MOUNTED IN OFFICE. SECOND SWITCH MOUNTED TO THE RIGHT OF DOOR OPENING IN FIRST CABINET. TIME DELAY NEEDED WITH BATTERY.
- DELIVERY POWER RELEASE BUTTON MOUNTED IN OFFICE BELOW SECURITY PANEL. SECOND SWITCH MOUNTED TO THE LEFT OF DOOR OPENING IN CABINET.
- DELIVERY POWER RELEASE BUTTON MOUNTED IN OFFICE EXACT COORDINATE WITH MANAGER.
- FOR ALL SECURITY CAMERAS, PROVIDE O/S TYPE RATED FOR OUTDOOR USE.

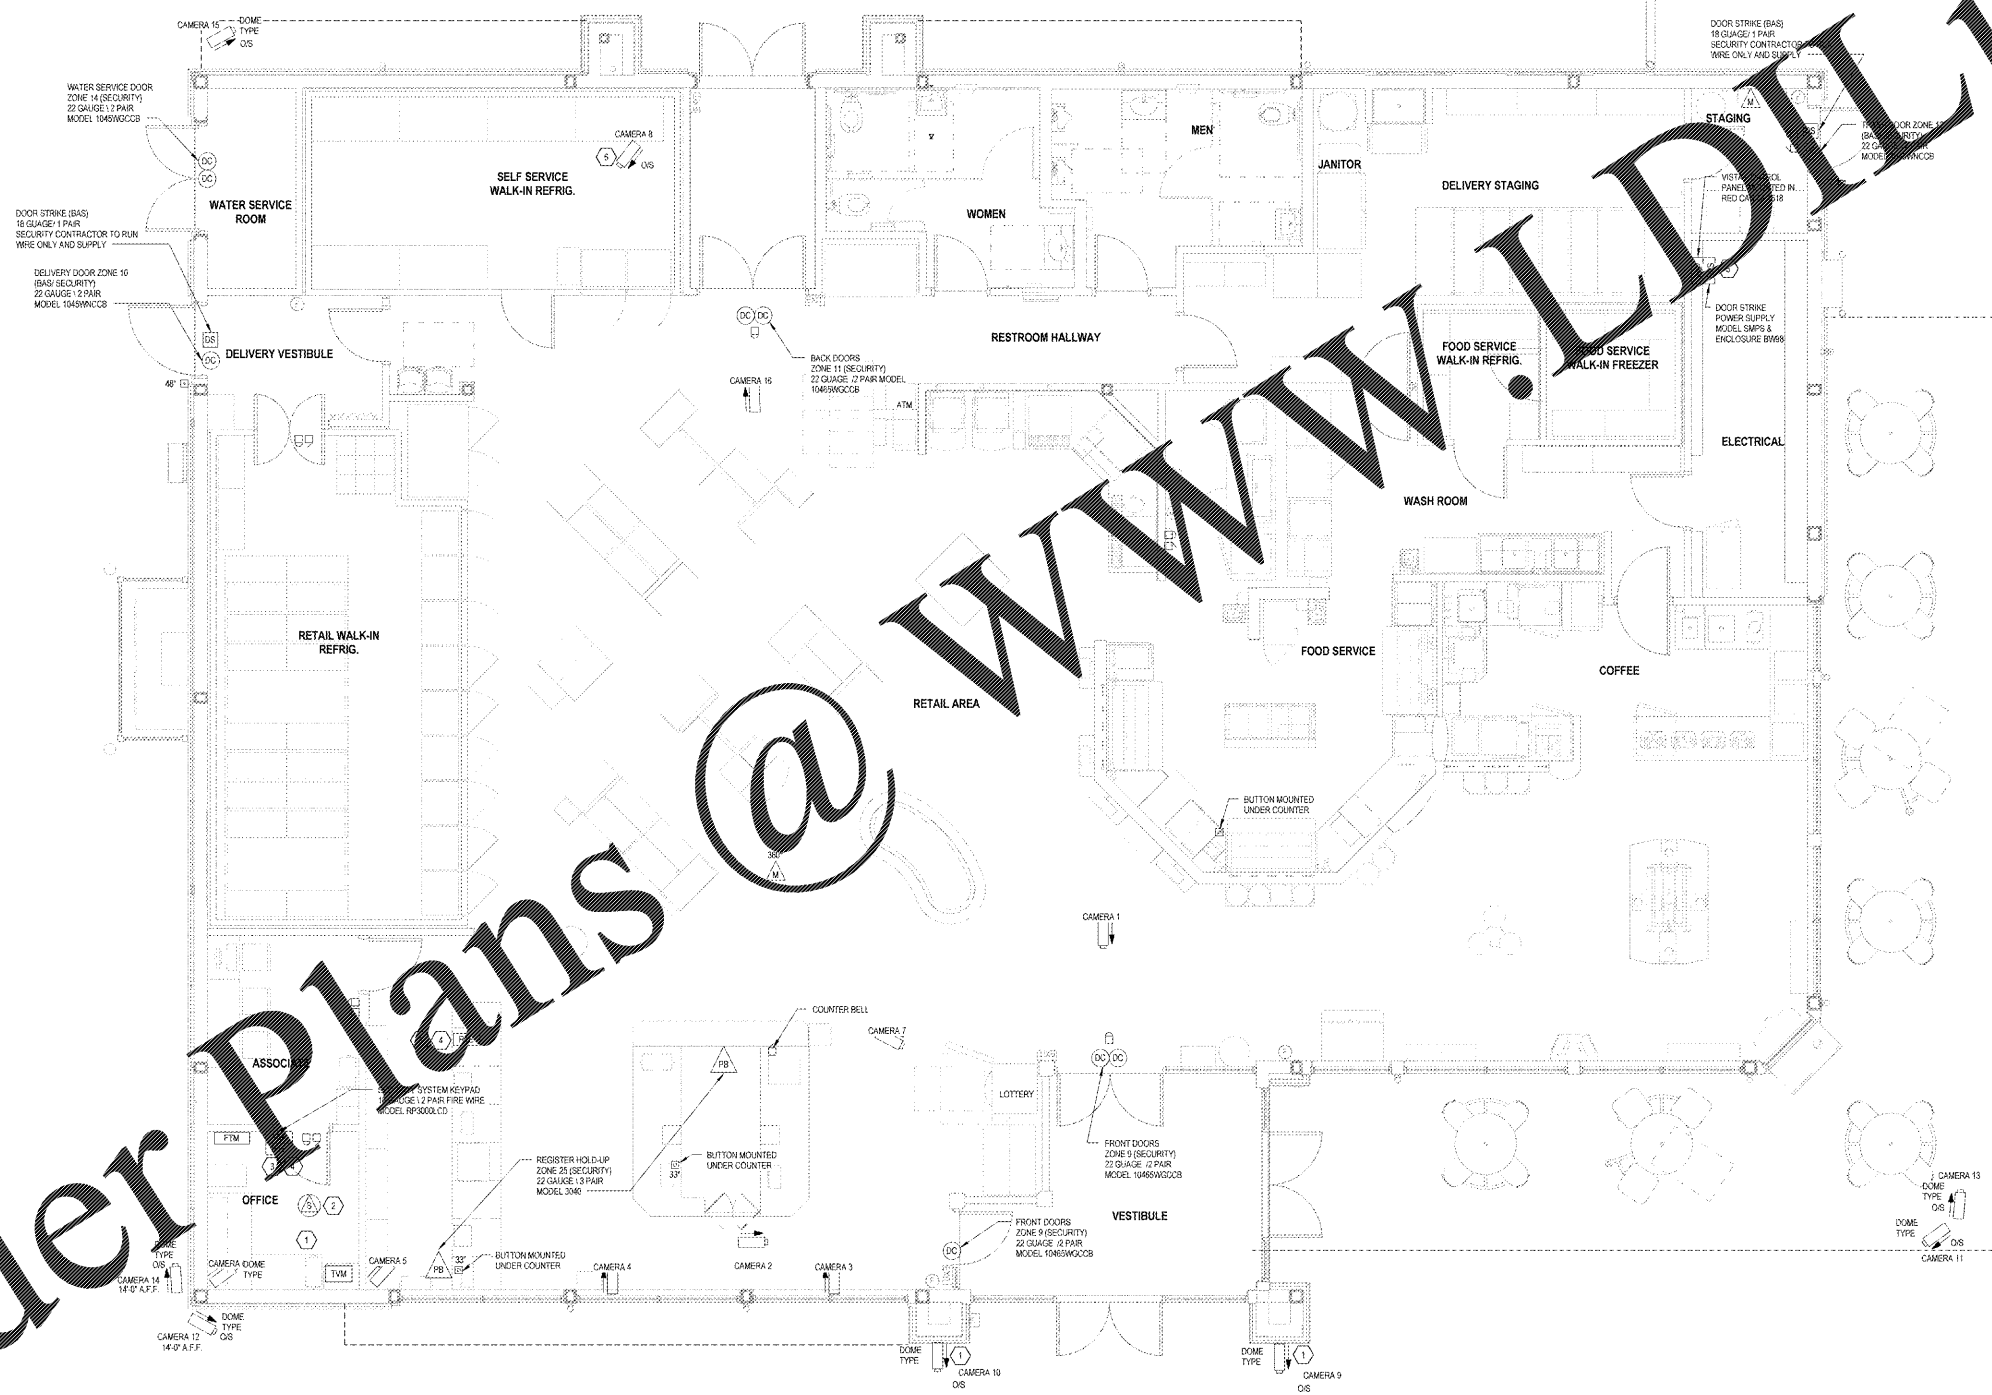

LEGEND

[Symbol]	PUSH-BUTTON BUZZER (EXTERIOR)
[Symbol]	PUSH-BUTTON BELL (INTERIOR)
[Symbol]	BUZZER (EXTERIOR) / BELL (INTERIOR)
[Symbol]	CHIME
[Symbol]	SECURITY SYSTEM PANEL
[Symbol]	SECURITY SYSTEM KEYPAD
[Symbol]	FUEL TANK MONITOR
[Symbol]	DOOR CONTACT
[Symbol]	MOTION DETECTOR
[Symbol]	PANIC BUTTON
[Symbol]	PANIC BUTTON WITH LEAD
[Symbol]	SECURITY SPEAKER
[Symbol]	DOOR STRIKE POWER SUPPLY
[Symbol]	DOOR STRIKE
[Symbol]	REQUEST TO ENTER
[Symbol]	CAMERA (SHOWING DIRECTION)
[Symbol]	CAMERA (OUTSIDE RATED FOR TEMPERATURE AND WEATHER)
[Symbol]	MONITOR FOR CAMERAS (CCTV)

1 SECURITY SYSTEM DEVICE PLAN
 1/8" = 1'-0"

CLIENT NAME: **WAWA**
 280 WEST BALTIMORE PIKE
 WAWA, PENNSYLVANIA 19053

PROJECT NAME: **WAWA F85FB 2018.02 STORE #5292-TLR**
 U.S. 17-92 & TAYLOR RD.
 DELAND, FLORIDA 32720

SHEET TITLE: **SECURITY PLAN**

PROJECT NO.	2/17/18
DATE	08-29-2018
FILED AND REVIEWED BY	LD
DATE SET	02/19/2019
REVISION	
CHECKED	JPM