


Order Plans @ www.LDILine.com

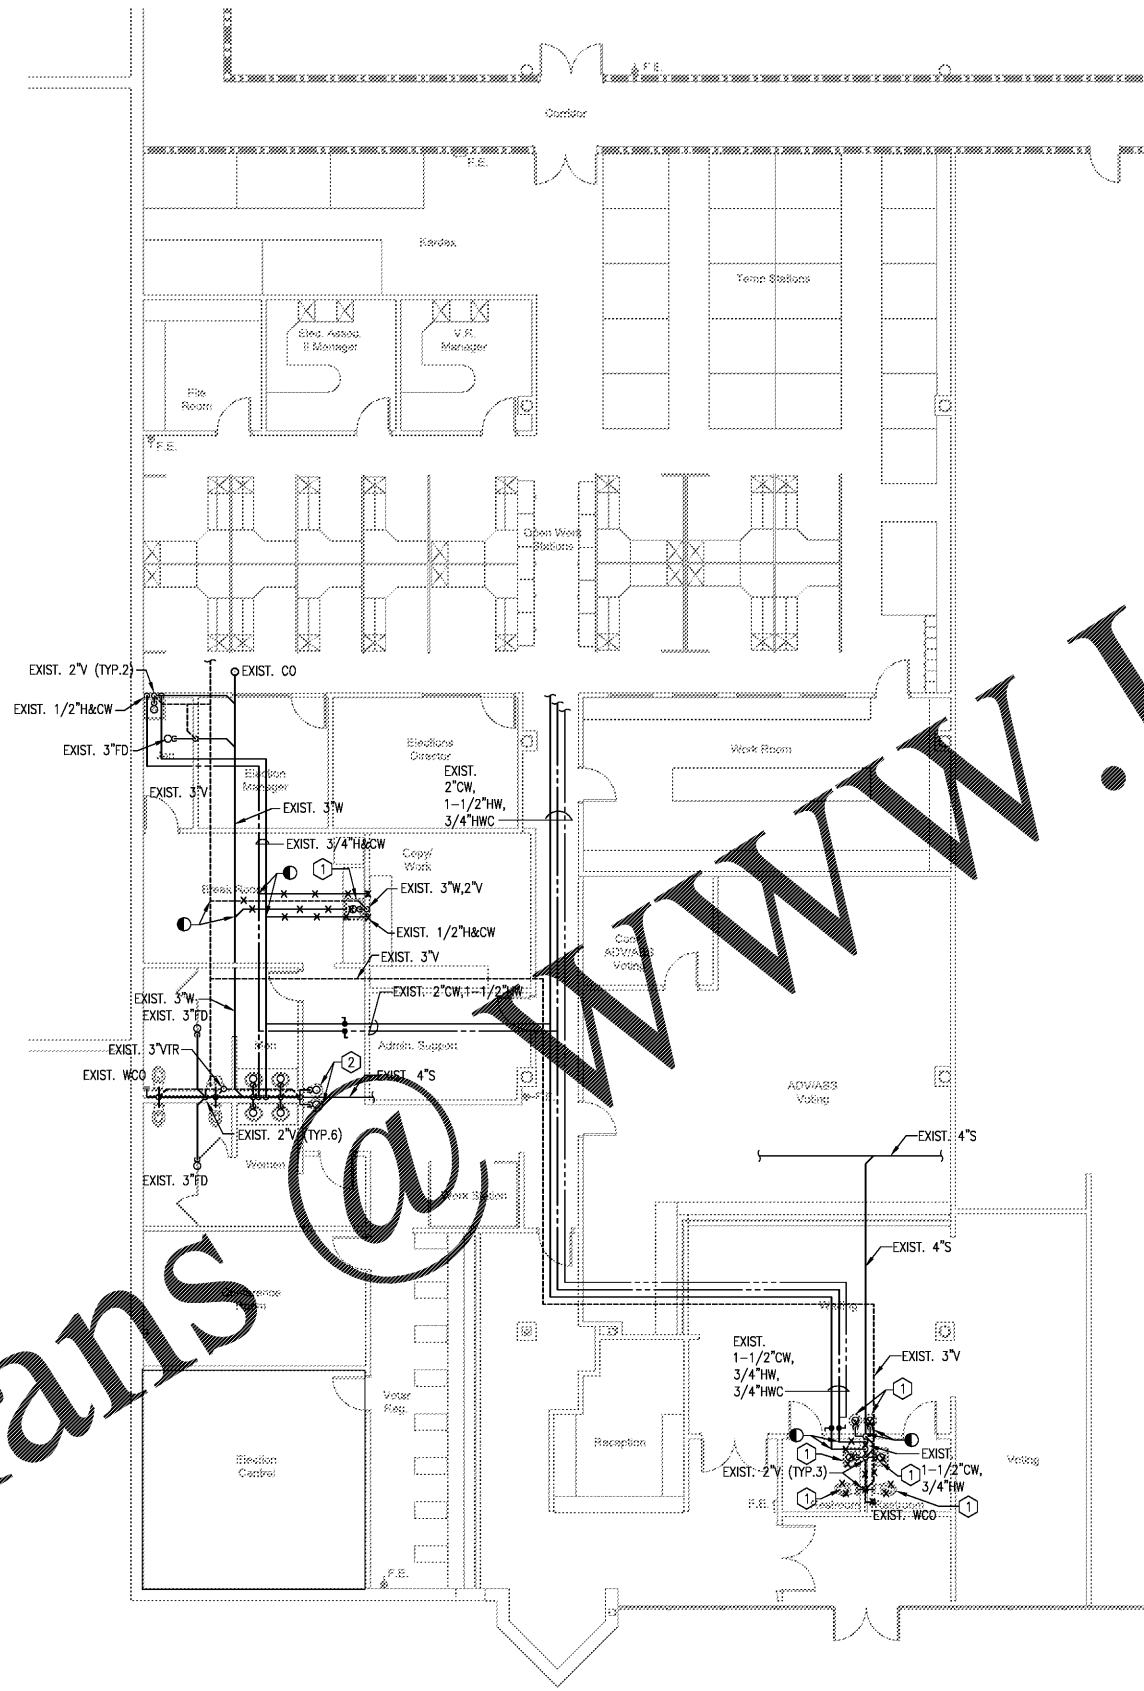

 
GENERAL NOTES

1. SEE PD.1 FOR PLUMBING GENERAL NOTES.


KEY NOTES

- ① REMOVE EXISTING PLUMBING FIXTURE. REMOVE AND CAP ASSOCIATED PIPING.
- ② REMOVE EXISTING DRINKING FOUNTAIN. ASSOCIATED EXISTING WASTE AND VENT PIPING SHALL REMAIN AND BE REUSED FOR THE NEW BOTTLE FILLER STATION AT THE SAME LOCATION. CAP EXISTING WATER PIPING IN WALL/CHASE.

PLUMBING DEMOLITION PART PLAN
SCALE: 1/8" = 1'-0"



© 2019
PRECISION PLANNING, INC.
ALL RIGHTS RESERVED.
THIS DOCUMENT IS THE PROPERTY OF PRECISION PLANNING, INC. AND IS TO BE USED ONLY FOR THE PROJECT AND SITE SPECIFICALLY IDENTIFIED HEREON. IT IS NOT TO BE REPRODUCED OR COPIED IN ANY MANNER WITHOUT THE WRITTEN PERMISSION FROM PRECISION PLANNING, INC.

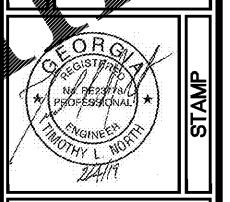

PRECISION Planning Inc.
planners • engineers • architects • surveyors
400 Pils. Boulevard, Lawrenceville, GA 30046
770.338.8000 • www.ppi.us

**GWINNETT COUNTY
VOTER REG. AND
ELEC. RENOVATION**
Suite 200
455 Grayson Highway
Lawrenceville, GA 30046

DESIGN	GBP	CHECKED	TLN
	AG		TLN
DRAWN			TLN
PROJECT TITLE			PROJECT

DATE	NO.	DESCRIPTION
02/04/19	1	RELEASED FOR BID

DATE	PROJ. NUMBER	FILE NAME	FILE NUMBER
02-04-19	A18-87A68B	M-200.dwg	

P.1.1