

**REFLECTED CEILING LEGEND**


- Ⓢ EXISTING WALL MOUNTED SPEAKER
- Ⓞ CEILING MOUNTED SPEAKER, COORDINATE EXACT LOCATION & QUANTITY OF SPEAKERS WITH PLAY NETWORK SYSTEM DESIGN DWGS
- ⊕ EXISTING SPRINKLER
- Ⓜ EXISTING SECURITY CAMERA
- NEW CAN
- LINEAR LIGHTER SEE SPECIFICATIONS
- ▭ 2X4' LED LIGHT FIXTURE - LAYIN
- ▭ 2X2' LED LIGHT FIXTURE - LAYIN
- WHITE PENDANT LIGHT FIXTURE
- RED PENDANT LIGHT FIXTURE
- TRACK LIGHTING  
 - MOUNT TO KITCHEN SIDE OF SOFFIT.  
 - CENTERED VERT ON SOFFIT.
- ⊠ EXHAUST, SEE SPECIFICATIONS
- ▭ ACOUSTICAL CEILING TILE
- ▭ GYPSUM BOARD

**GENERAL NOTES**

1. ALL EQUIPMENT IS EXISTING TO REMAIN UNLESS NOTED OTHERWISE.

**CONSTRUCTION NOTES**

- 1 ACT START POINT. TEST FIT CEILING GRID AND VERIFY DIMENSIONS TO ENSURE PROPOSED LIGHTING PACKAGE FITS AS DESIGNED.
- 2 OPEN SIGN, REFER TO SHEET K1-01 & DETAIL 2 ON SHEET A6-01
- 3 MENU BOARD MOUNTED FROM CEILING PER MFR INSTALLATION INSTRUCTIONS
- 4 CENTER LIGHT FIXTURE IN RESTROOM CEILING
- 5 PENDANT FIXTURE TO HAVE 6" CORD, TYP UNDER SERVICE SOFFIT ONLY
- 6 HOOD GREASE CUP, REFER TO SHEET K1-01 & M14-01
- 7 DINING ROOM SIDE OF SOFFIT TO ALIGN WITH COUNTER KNEE WALL BELOW, TYP. (EXCEPTION: MILKSHAKE ENCLOSURE)
- 8 ALIGN ACT SUPPORT TEE WITH FRONT EDGE OF HOOD
- 9 EXPOSED SPIRAL DUCTWORK, REFER TO MECHANICAL DWGS FOR MORE DETAILS
- 10 RED PENDANT FIXTURE UNDER BEVERAGE AREA TO HAVE 1'-6" CORD AND MATCH HEIGHT A.F.F. OF PENDANTS UNDER SERVICE SOFFIT
- 11 CENTER NEON SIGN CENTERED OVER MILKSHAKE EQUIPMENT, BELOW PROVIDE BLOCKING IN CEILING FOR DIRECT MOUNTING.
- 12 WINDOW NEON SIGN OVER MILKSHAKE EQUIPMENT BELOW

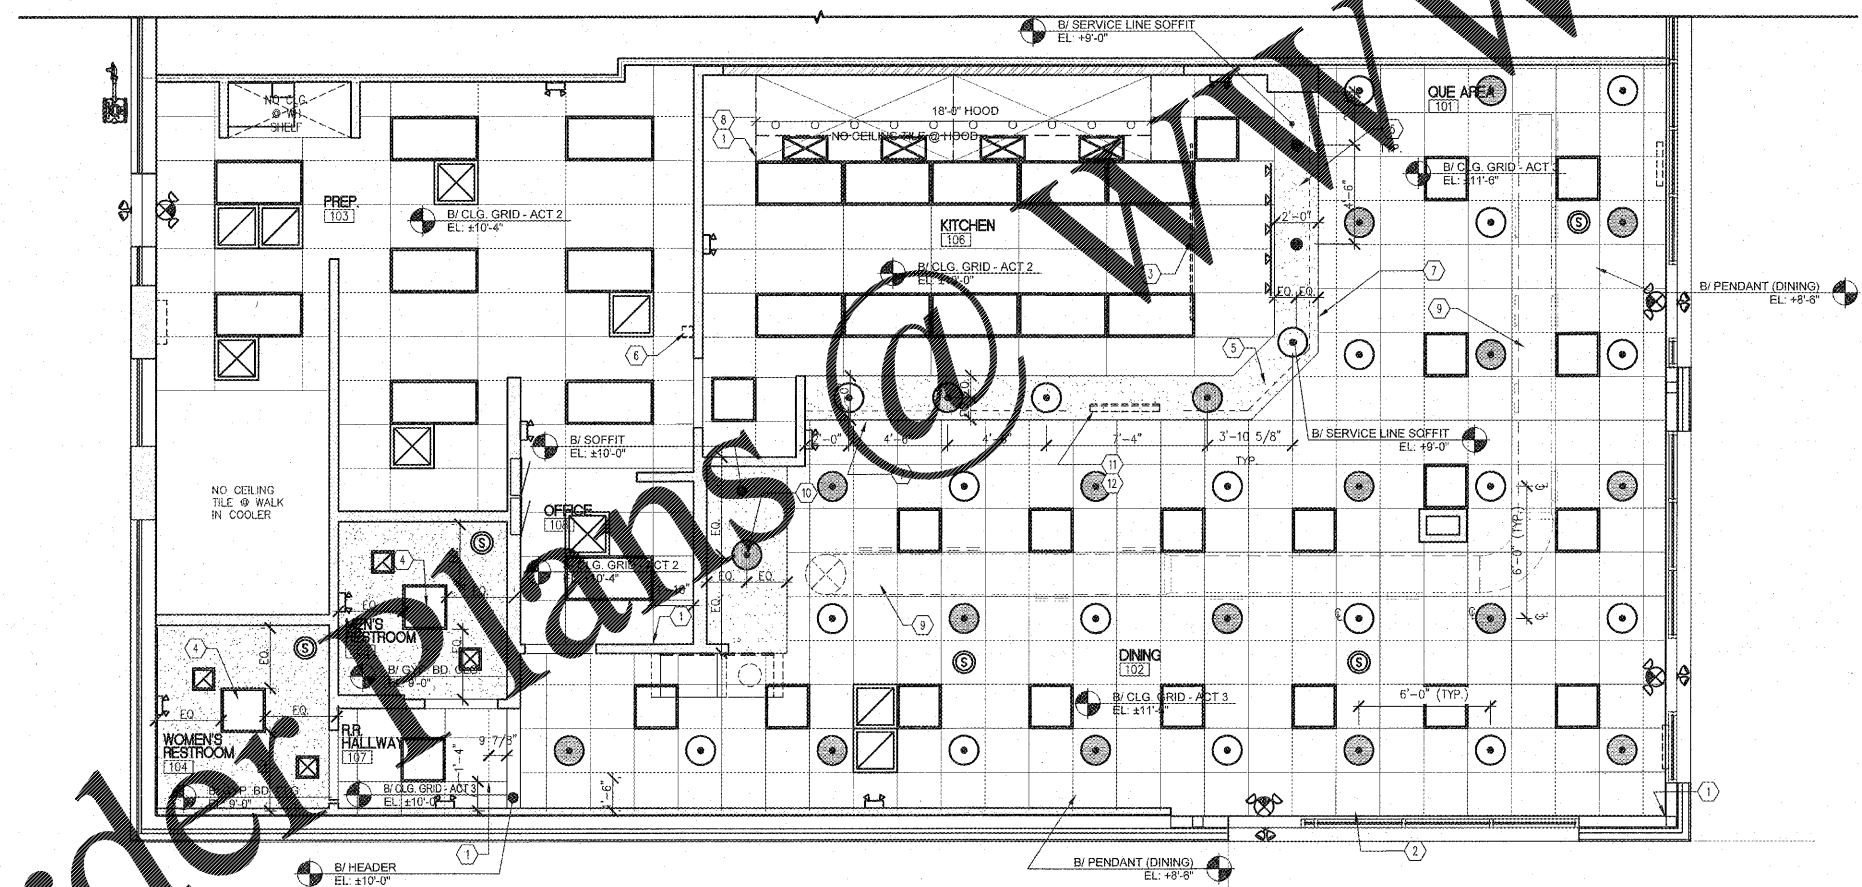

**1 PROPOSED REFLECTED CEILING PLAN**  
 A301 SCALE: 1/4" = 1'-0"

PROJECT: FIVE GUYS BURGERS & FRIES  
 630 CRANE CREEK DRIVE  
 AUGUSTA, GA, 30907

**Revisions**

REVISION DATE

PROJECT DATE  
 12.3.18  
 Drawn By  
 TA  
 Checked By  
 OL

Sheet No.  
**A301**

Order Plans @ [WWW.LDILine.com](http://WWW.LDILine.com)