


ALDI Inc. - Cary, North Carolina

Store No. 59
1315 Kildaire Farm Rd
Cary, NC 27511

ARCHITECT'S JOB NUMBER: 40452-25
ISSUE DATE: 03/08/19

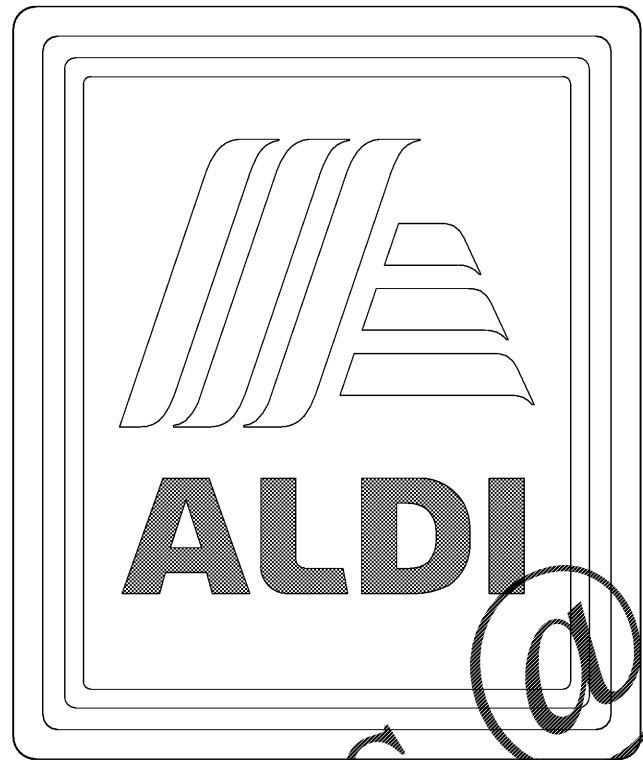

ALDI - Salisbury Division
1985 Old Union Church Road
Salisbury, NC 28146

Drawing Index

G-001	Cover Sheet	FP-101	Fire Protection Floor Plan
G-002	Code Review	H-101	HVAC Construction Plan
G-003	NC Appendix B	H-201	HVAC Legend, Section & Schedules
G-004	Accessibility Standards		
G-005	COMCheck	E-001	Materials List and Notes
G-006	UL Assembly & Code Decision Diagram	E-101	Lighting Plan
		E-102	Schedules and Diagrams
ASP-101	Architectural Site Plan	E-201	Electrical Plan
		E-301	Enlarged Plan
D-102	Demolition Keyed Notes	E-401	One-line Diagram Schedules & Elevation
D-103	Demolition Keyed Notes	E-402	One-line Diagram Schedules & Elevation
D-121	Demolition Roof Plan	E-501	Electrical Details
D-201	Demolition Exterior Elevations	E-502	Electrical Details
S-001	General Structural Notes		
S-101	Foundation Plan		
S-111	Roof Framing Plan		
S-301	Foundation Details		
S-302	Foundation Details		
S-401	Steel Framing Sections & Details		
S-402	Steel Framing Sections & Details		
S-403	Steel Framing Sections & Details		
S-404	Steel Framing Sections & Details		
A-001	General Notes, Symbols, Abbreviations		
A-101	Floor Plan		
A-102	Keyed Notes Plan		
A-103	Keyed Notes Plan		
A-111	Reflected Ceiling Plan		
A-121	Roof Plan		
A-131	Operational Plan		
A-201	Exterior Elevations		
A-211	Interior Elevations		
A-212	Interior Elevations		
A-213	Interior Elevations		
A-214	Interior Elevations		
A-215	Interior Elevations		
A-216	Interior Elevations		
A-301	Wall Sections		
A-302	Wall Sections		
A-303	Wall Sections		
A-304	Wall Sections		
A-305	Wall Sections		
A-401	Enlarged Plans		
A-402	Enlarged Plans		
A-501	Exterior Details - Section		
A-502	Exterior Details - Section		
A-503	Exterior Details		
A-504	Exterior Details		
A-511	Interior Details - Section		
A-512	Interior Details		
A-513	Interior Details		
A-601	Door Schedules & Details		
A-602	Window Elevations & Details		
A-603	Finish Schedules & Notes		
P-101	Plumbing Floor Plan		
P-102	Plumbing Drainage Location Plan		
P-201	Enlarged Plumbing Plans		
P-301	Plumbing Isometrics		
P-401	Plumbing Details and Schedules		

Deferred Submittals

Reference Drawings


NOTES

NOTE: THESE DRAWINGS ARE PART OF THE CONTRACT DOCUMENTS AS DESCRIBED IN THE PROJECT MANUAL; IN ANY AND ALL CONFLICTS BETWEEN THE DRAWINGS AND THE TECHNICAL SPECIFICATIONS, THE MOST STRINGENT REQUIREMENT WILL GOVERN AND THE G.C. SHALL COORDINATE WITH THE ALDI REPRESENTATIVE.

THESE DOCUMENTS ARE FOR THE SOLE PURPOSE OF INITIAL BUILDING PERMIT SUBMITTAL ONLY. ANY COMMENTS, REVISIONS OR CORRECTIONS BASED ON BUILDING DEPARTMENT REVIEW AND/OR BUILDING CODE INTERPRETATION ITEMS ARE THE SOLE RESPONSIBILITY OF THE OWNER AND REGIONAL ARCHITECT WILL NOT BE HELD LIABLE FOR ANY CHANGE ORDERS RESULTING FROM THESE ITEMS. FINAL BID PRICES SHOULD NOT BE SUBMITTED UNTIL THE BUILDING PERMIT HAS BEEN ISSUED.

DRAWINGS ARE BASED ON ALDI VERSION 7.0 PROTOTYPE RELEASED ON 11.17.17

LOCATION MAP:

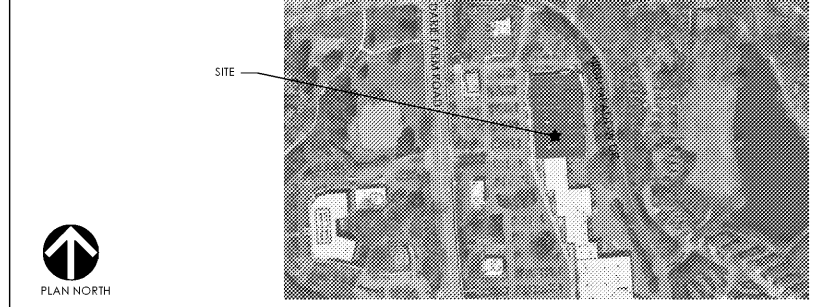

Issued:	Date:
A Client Review Set	02/15/19
B Bid Set	03/08/19
C	
D	
Revisions:	Date:
1	
2	
3	
4	
5	
6	
7	
8	

DO NOT SCALE PLANS
Copying, Printing, Software and other processes required to produce these prints can stretch or shrink the actual paper or layout. Therefore, scaling of this drawing may be inaccurate. Contact us consultants with any need for additional dimensions or clarifications.

ms consultants, inc.
engineers, architects, planners
920 Main Campus Drive
Suite 430
Raleigh, NC 27606-5213
(919)-772-5565
fax: (919)-779-2308

DRAWN BY: MEM/BMT

REVIEWED BY: NAL/CMB

Seal

ALDI Inc.
1985 Old Union Church Road
Salisbury, NC 28146
(704) 642-0023
(704) 642-0078 fax

ALDI Inc. Store #: 59
Cary, NC
1315 Kildaire Farm Rd
Cary, NC 27511
Wake County
Project Name & Location:

Cover Sheet	
Drawing Name:	
Prototype Rls.	Project No.
	40452-25
Type:	V7.1
	G-001
Scale: As Noted	Drawing No.

ALDI CONTACTS:

Todd Bonnett
1985 Old Union Church Rd.
Salisbury, NC, 28146
(704) 642-0023
Todd.Bonnett@aldi.us

ARCHITECT OF RECORD:

ms consultants, inc.
Eric M. Elizondo AIA, NCARB,
LEED AP BD+C
2221 Schrock Road
Columbus, Ohio 43229
(614) 898-7100
(614) 898-7570 (FAX)

STRUCTURAL ENGINEER OF RECORD:

ms consultants, inc.
Craig Metzger, PE
2221 Schrock Road
Columbus, Ohio 43229
(614) 898-7100
(614) 898-7570 (FAX)

MECHANICAL ENGINEER OF RECORD:

ms consultants, inc.
Daniel Dowler, PE
2221 Schrock Road
Columbus, Ohio 43229
(614) 898-7100
(614) 898-7570 (FAX)

ELECTRICAL ENGINEER OF RECORD:

ms consultants, inc.
Daniel Dowler, PE
2221 Schrock Road
Columbus, Ohio 43229
(614) 898-7100
(614) 898-7570 (FAX)