




REVISION DATE

 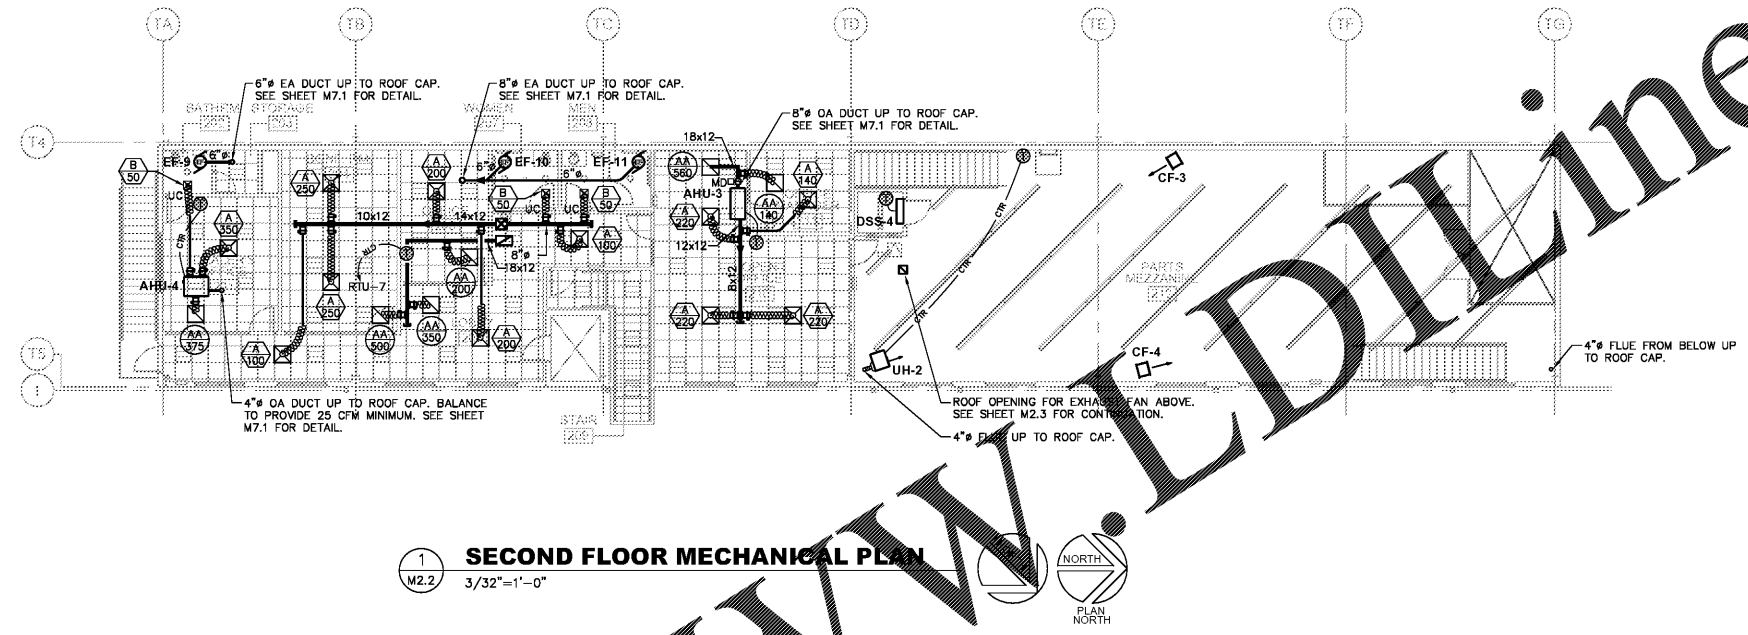


1  
M2.2 **SECOND FLOOR MECHANICAL PLAN**  
3/32"=1'-0"

NORTH  
PLAN NORTH

Order Plans @ [www.LDILine.com](http://www.LDILine.com)

ELLSWORTH  
ARCHITECTS  
3136 LANIER DRIVE  
ATLANTA, GEORGIA 30319  
PHONE: 404.949.9351



**PRO  
BUILDING  
SYSTEMS**  
DESIGN BUILD  
CONTRACTORS

3678 North Peachtree Road  
Atlanta, Georgia 30341  
(770) 455-1791 / Fax 455-4123  
www.probdgsystems.com

**GINN CHRYSLER - DODGE - RAM AND JEEP**  
I-20 ACCESS ROAD  
COVINGTON GEORGIA 30040

DATE: 11.06.2018

SCALE: AS SHOWN

BY: GD

JOB ID:

SECOND FLOOR MECH. PLAN

DRAWING TITLE

**M2.2**

SHEET 3 OF 7

**PROMUS**  
SCOTT MERIWETHER, P.E.  
GEORGIA LICENSE #30780

518 BLACK CANYON PARK  
CANTON, GA 30114  
PROJECT MANAGER: GEORGE DAVIDOV  
PHONE 678.246.5146