 




REVISION DATE


ELLSWORTH ARCHITECTS  
 3136 LANIER DRIVE  
 ATLANTA, GEORGIA 30319  
 PHONE: 404.949.9351



**PRO BUILDING SYSTEMS**  
 DESIGN BUILD CONTRACTORS

3678 North Peachtree Road  
 Atlanta, Georgia 30341  
 (770) 455-1791 / Fax 455-4123  
 www.probdgsystems.com

**GINN CHRYSLER - DODGE - RAM AND JEEP**  
 1-20 ACCESS ROAD  
 COVINGTON GEORGIA 30040

DATE: 11.06.2018

SCALE: AS SHOWN

BY: GD

JOB ID:

ROOF MECHANICAL PLAN

DRAWING TITLE


**M2.3**

SHEET 4 OF 7

**PROMUS**  
 SCOTT MERIWETHER, P.E.  
 GEORGIA LICENSE #30780  
 518 BLACK CANYON PARK  
 CANTON, GA 30114  
 PROJECT MANAGER: GEORGE DAVIDOV  
 PHONE 678.246.5146

Order Plans @

WWW.LDILINE.COM

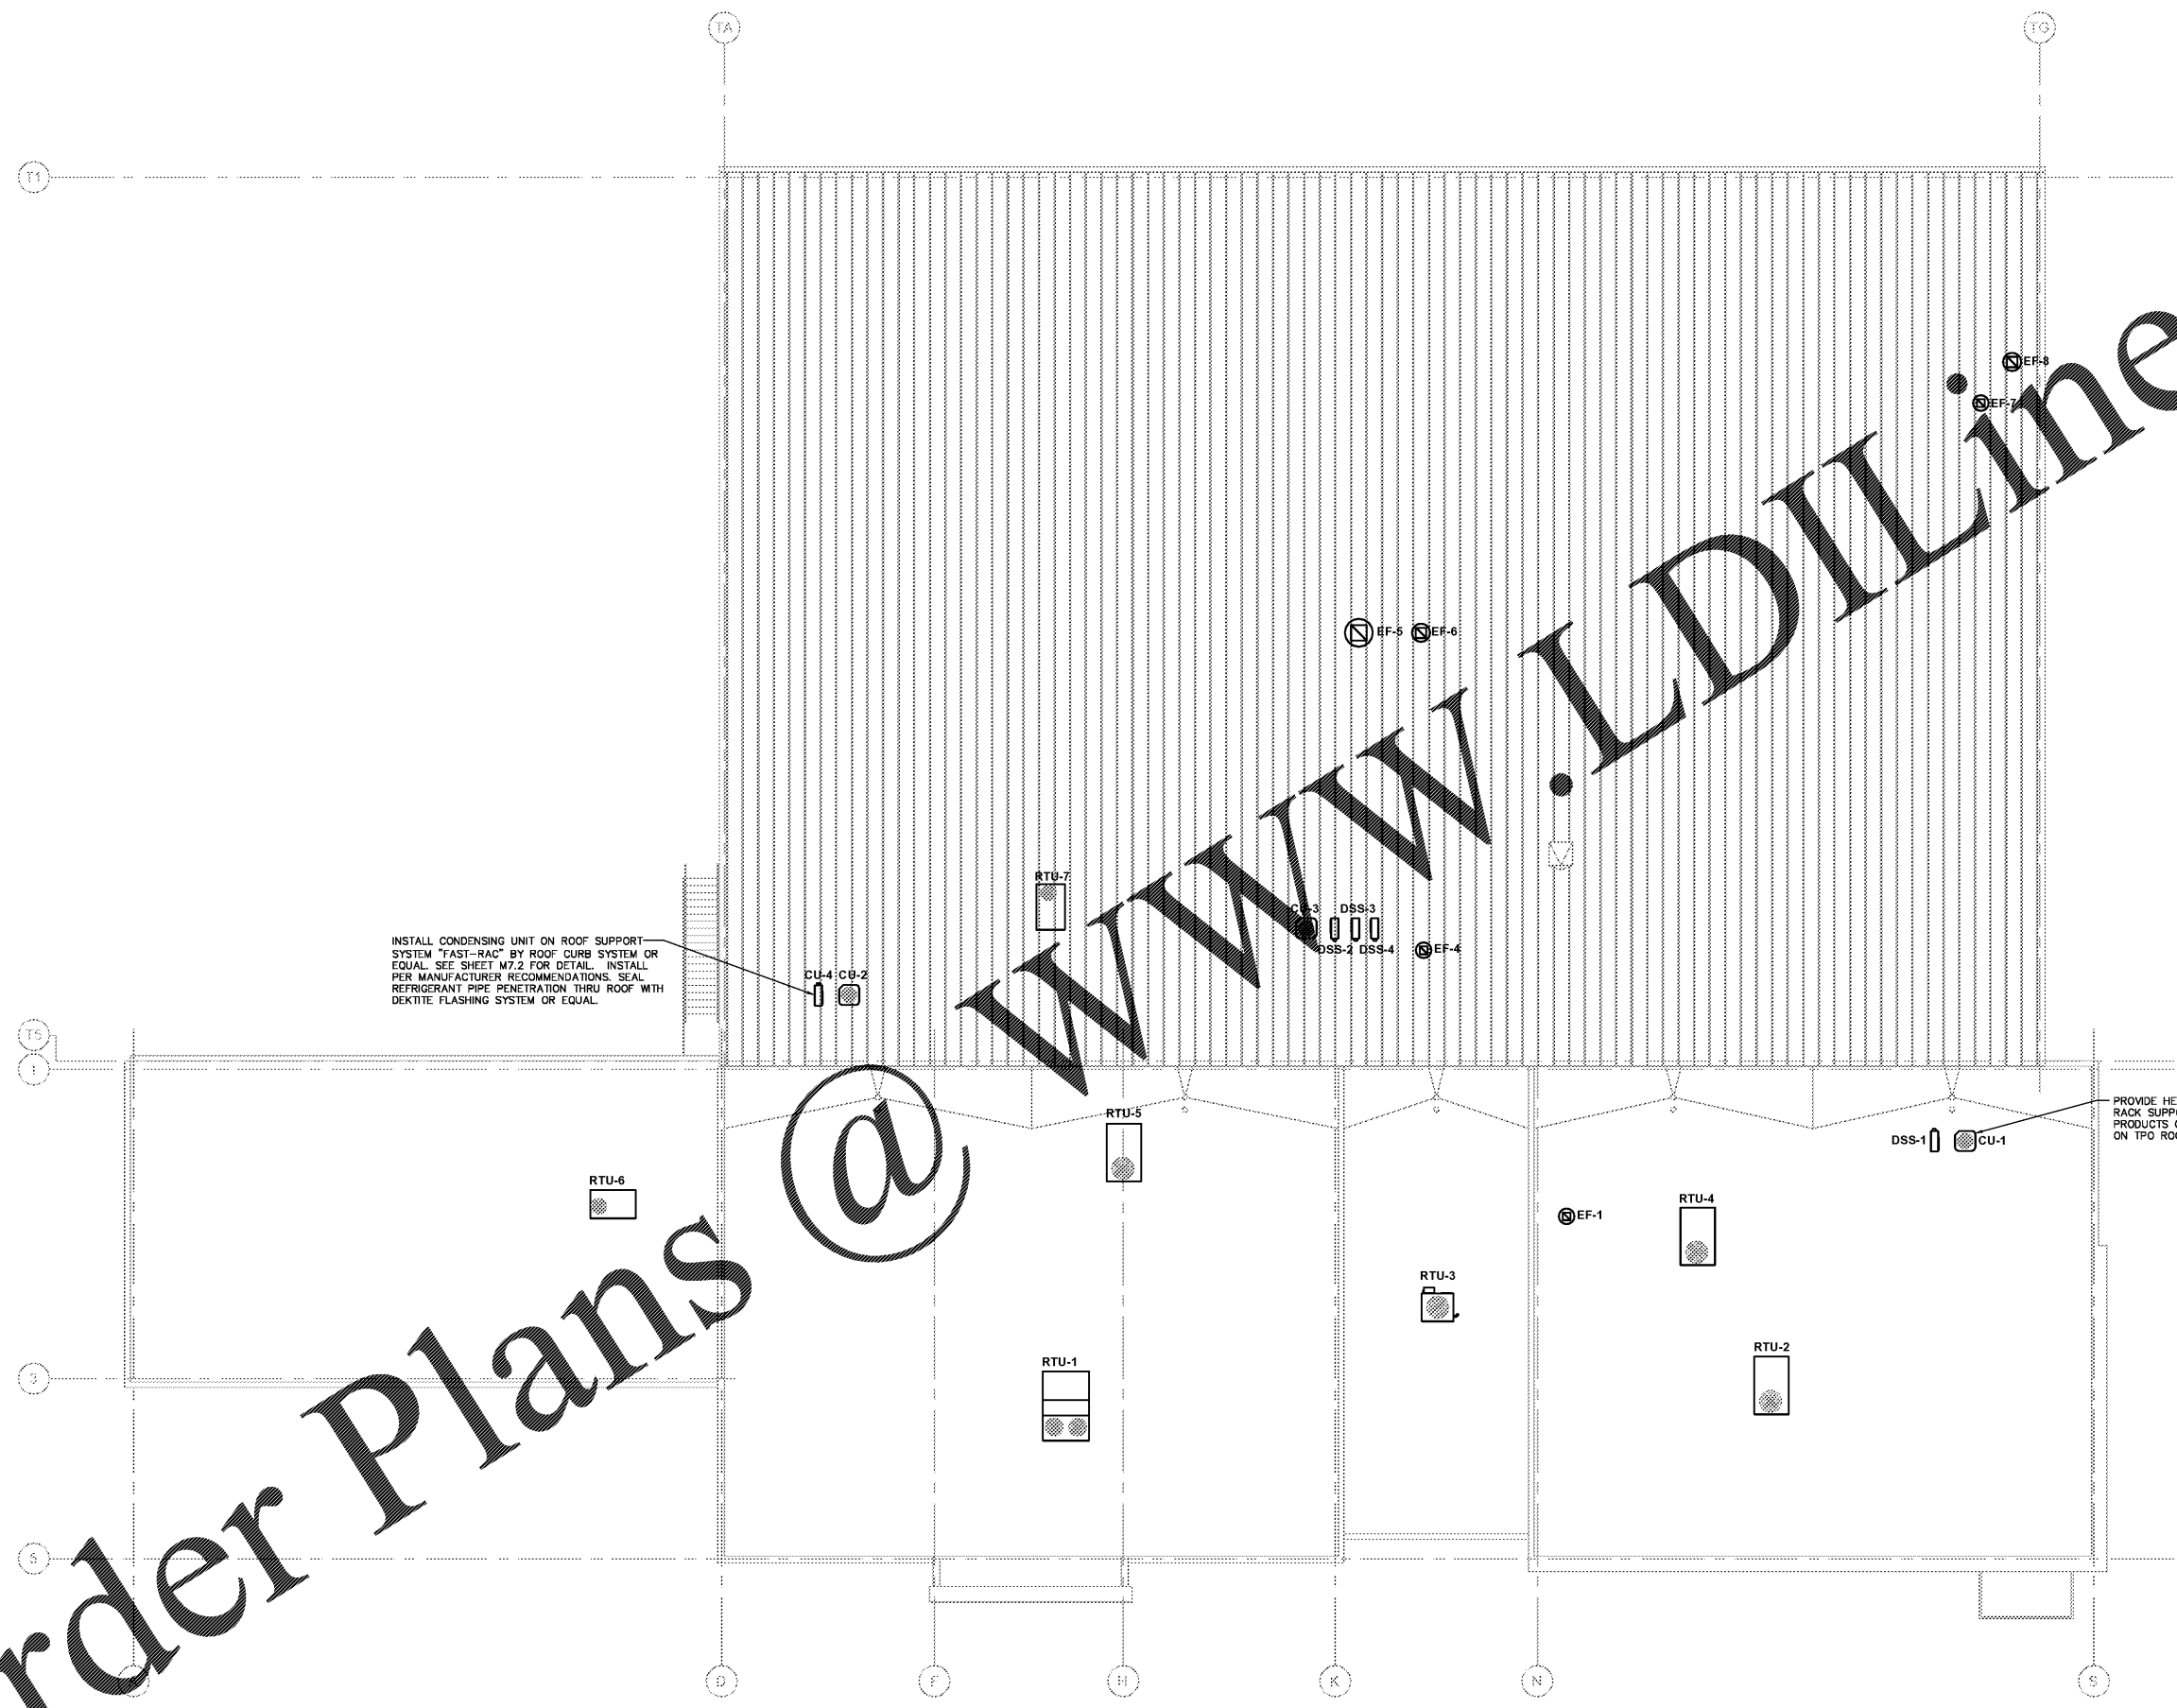

**1 ROOF MECHANICAL PLAN**  
 M2.3 3/32"-1'-0"

