


SITE LIGHTING FIXTURE SCHEDULE									
SYMBOL	LABEL	QTY	MANUFACTURER	CATALOG NUMBER	DESCRIPTION	LAMP	LUMENS PER LAMP	LIGHT LOSS FACTOR	WATTAGE
☐	OA	24	GE LIGHTING SOLUTIONS	EWS3_C7D150_120-277V	Evolve LED Area Light - Scalable - Wall Pack - EWS3	LED	4959 849	0.9	41
⊙	OB	18	GE LIGHTING SOLUTIONS	EALP03_Q2AN750 WITH ELS EAL WBL BLCK	EALP03 EVOLVE LED AREA	LED	65158	0.9	570
⊙	OC	26	GE LIGHTING SOLUTIONS	EALP03_P3SW750	EALP03 EVOLVE LED AREA	LED	80000	0.9	940
⊙	OD	18	GE LIGHTING SOLUTIONS	EALP03_Q3AW750 WITH ELS EAL WBL BLCK	EALP03 EVOLVE LED AREA	LED	65600	0.9	570
☐	OF	4	GE LIGHTING SOLUTIONS	EFH101_EE76750	EFH101 EVOLVE LED FLOOD	LED	Absolute	0.9	297


STATISTICS					
DESCRIPTION	SYMBOL	AVG	MAX	MIN	AVGMIN
Calc Zone #1	+	48.7	3	160.7	32.7
EMPLOYEE/IN SERVICE	X	0	23	90.7	31.7
FRONT ROW PARKING	X	25.9	48.2	9.7	3.9
GENERAL	X	16.3	47.9	1.0	16.3




REVISION DATE

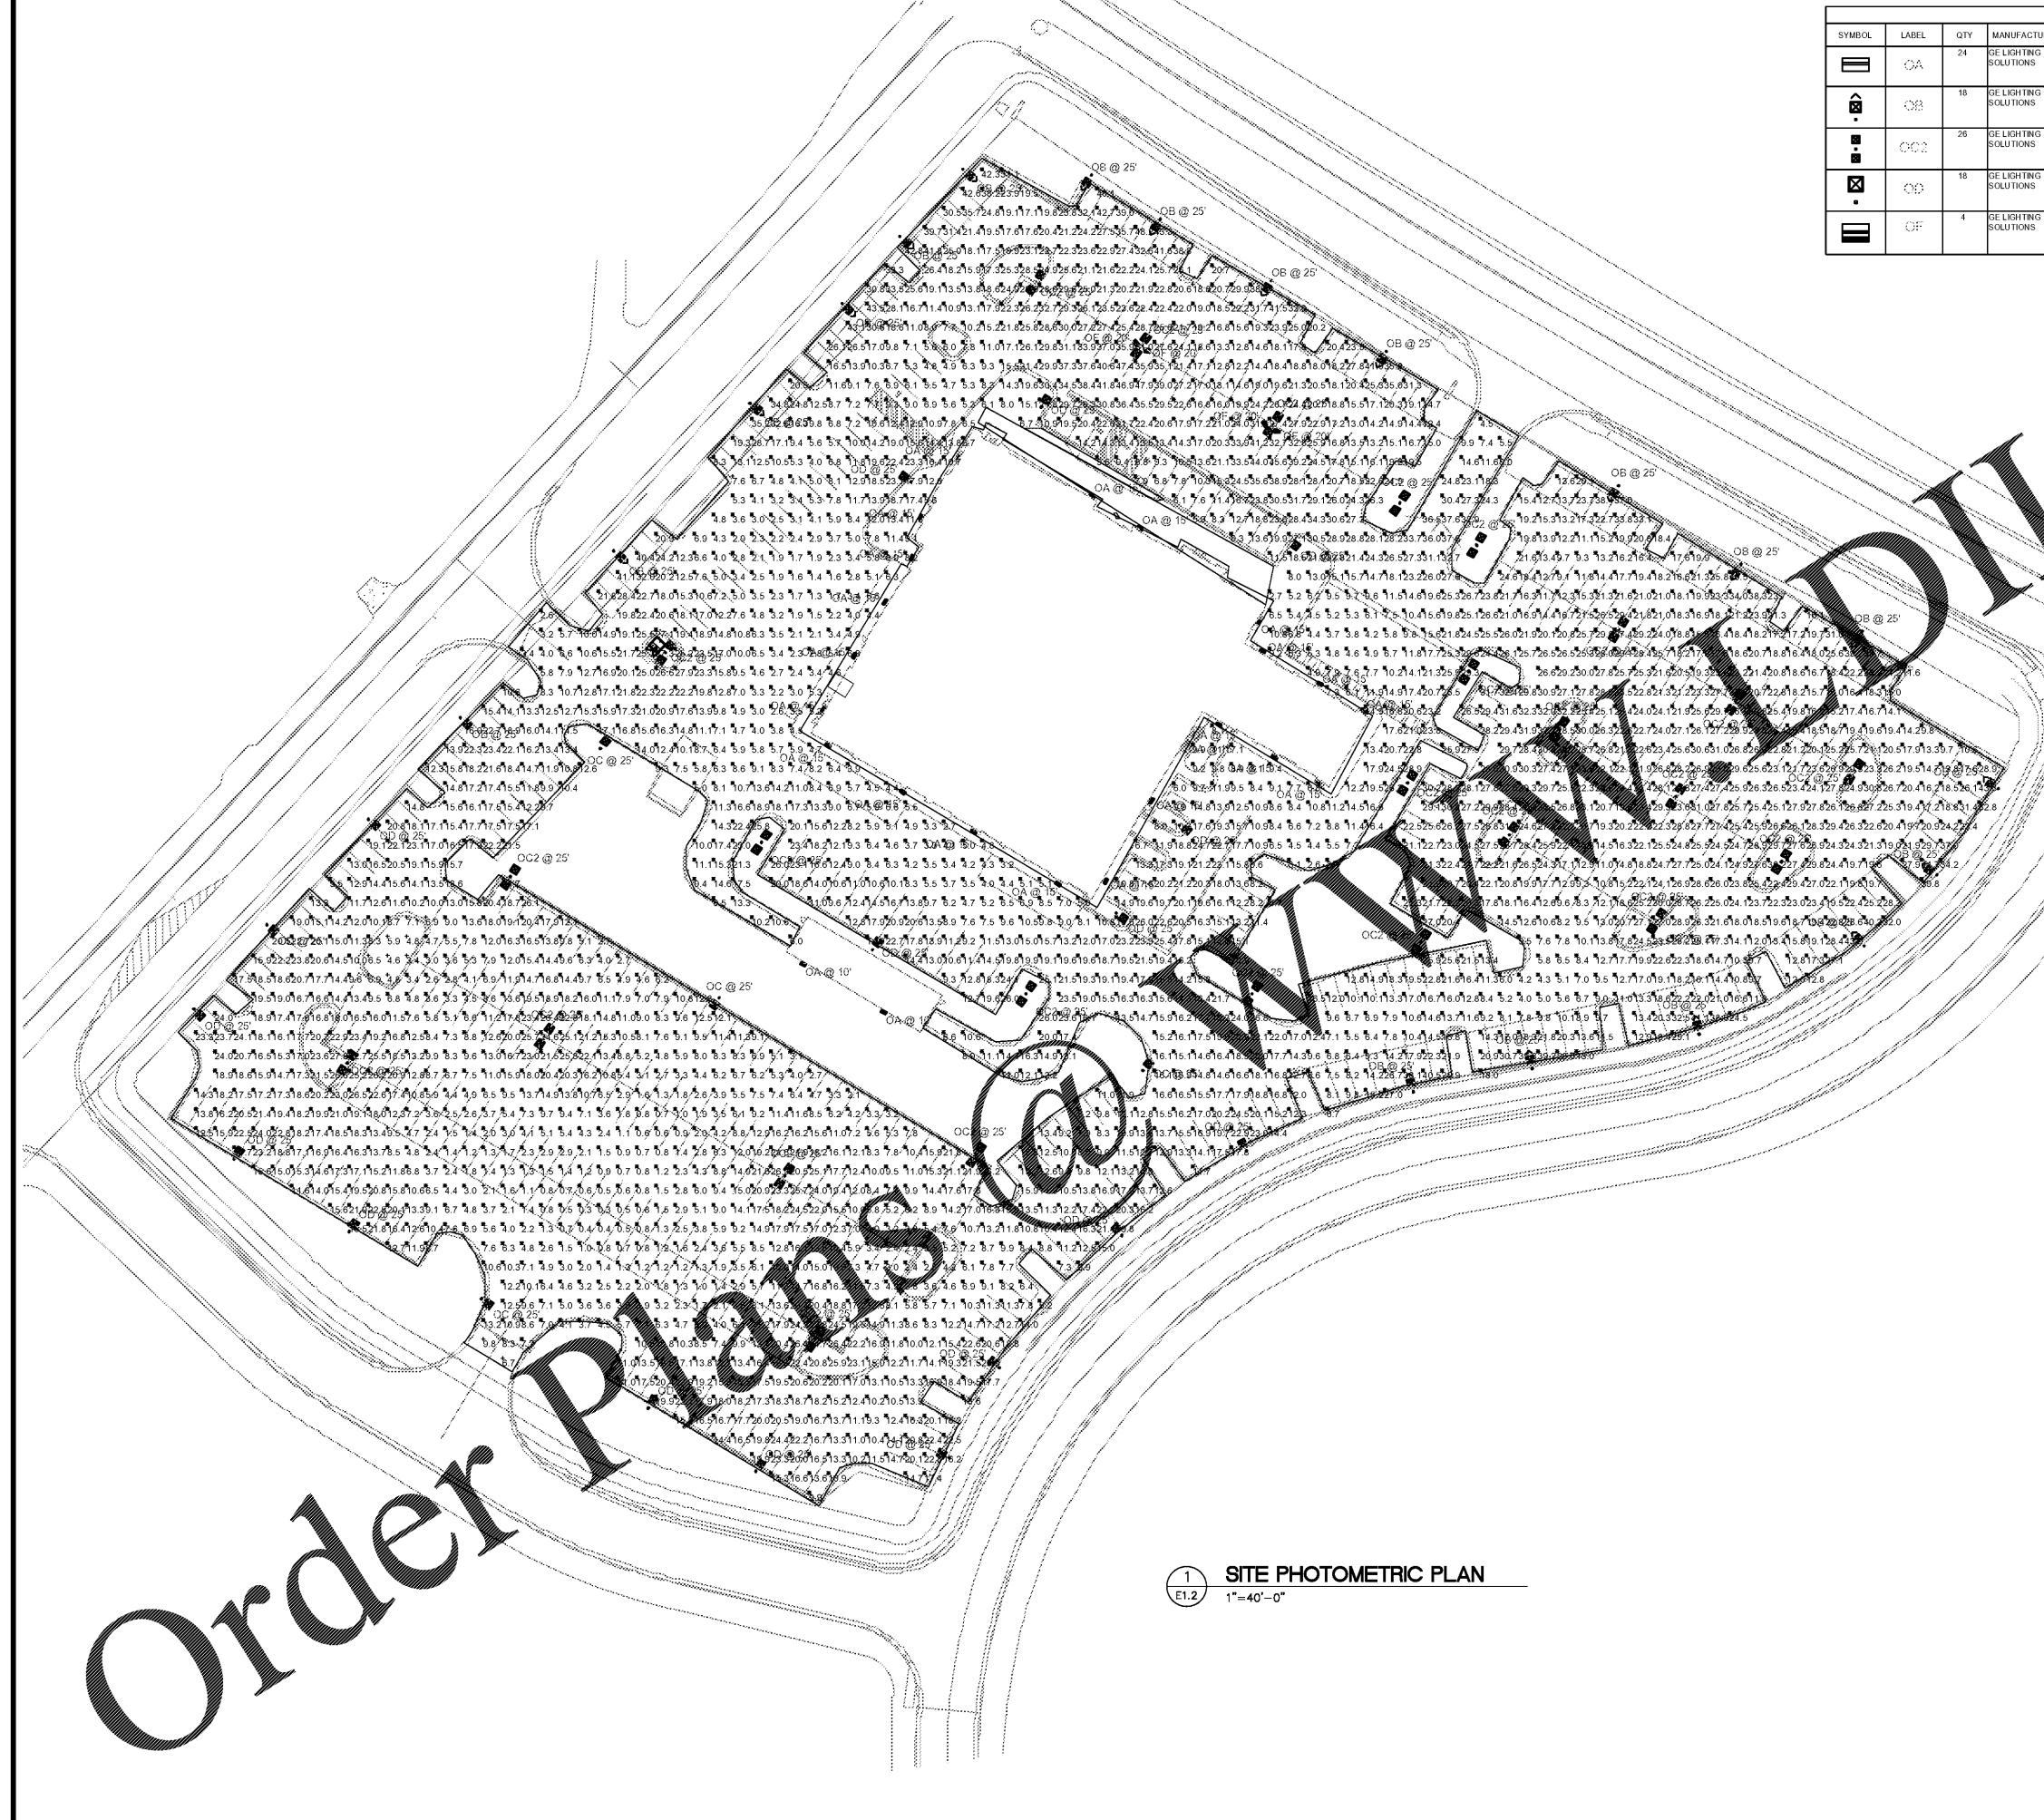

1 SITE PHOTOMETRIC PLAN
1" = 40'-0"

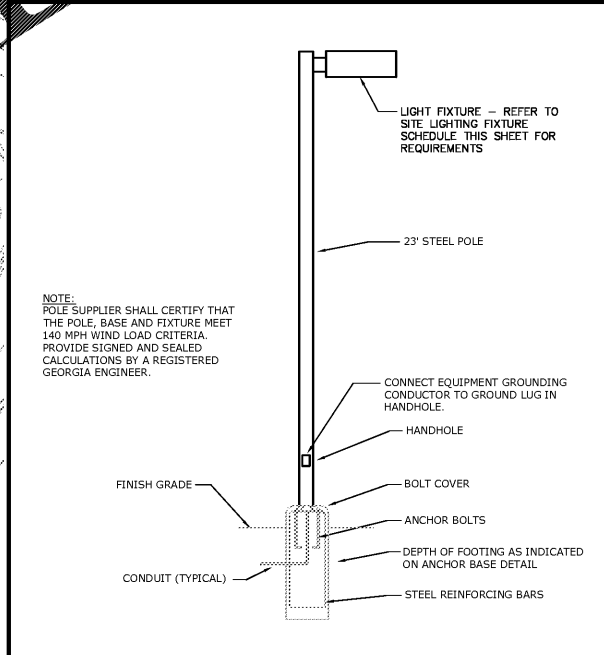

POLE DETAIL-TYPICAL
NOT TO SCALE

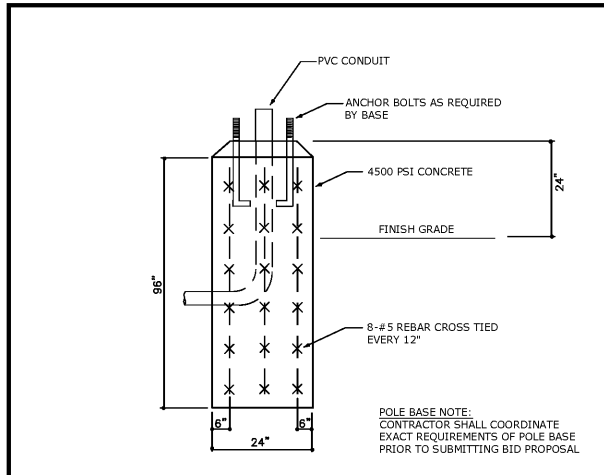

POLE ANCHOR BASE DETAIL
NOT TO SCALE

ELLSWORTH ARCHITECTS
3136 LANIER DRIVE
ATLANTA, GEORGIA 30319
PHONE: 404.949.9351

PRO BUILDING SYSTEMS
DESIGN BUILD CONTRACTORS
3678 North Peachtree Road
Atlanta, Georgia 30341
(770) 455-1791 / Fax 455-4123
www.probuildingsystems.com

GINN CHRYSLER - DODGE - RAM AND JEEP
I-20 ACCESS ROAD
COVINGTON GEORGIA 30040

DATE: 11.06.2018
SCALE: AS SHOWN
BY: GD
JOB ID:

SITE PHOTOMETRIC PLAN
DRAWING TITLE

PROMUS
SCOTT MERIWETHER, P.E.
GEORGIA LICENSE #30780
518 BLACK CANYON PARK
CANTON, GA 30114
PROJECT MANAGER: GEORGE DAVIDOV
PHONE 678.246.5146

E1.2
SHEET 4 OF 14

Order Plans