


OVERRIDE SWITCH SCHEDULE			
SWITCH CONTROL AREA	# BUTTONS	BUTTON DESCRIPTION	BRANCH CIRCUITS CONTROLLED
JEEP SHOWROOM RECEPTION / SALES LOUNGE / CORRIDOR	6	SHWRM-PERIMETER	H10A-42
		SHWRM-CAR	H10A-42
		RECEPTION / SALES LOUNGE / CORRIDOR	H10A-42
		WAITING	H10A-42
		SPARE *	
CDR SHOWROOM RECEPTION / SALES LOUNGE / CORRIDOR	6	SHWRM-LEFT	H10A-40
		SHWRM-RIGHT	H10A-40
		RECEPTION / SALES LOUNGE / CORRIDOR	H10A-40
		WAITING	H10A-42
		SPARE *	
SERVICE WRITE-UP	2	SERVICE WRITE-UP	H10A-38
		SPARE *	
SERVICE RECEPTION	2	SERVICE RECEPTION	H10A-38
		SPARE *	
PARTS	2	PARTS	H10A-32,34
		SPARE *	
SERVICE SHOP CORRIDOR	6	SERVICE SHOP-TOP	HSA-37
		SERVICE SHOP-AISLE	HSA-39
		SERVICE SHOP-BOTTOM CORRIDOR	HSA-39,41
		SPARE *	
		SPARE *	

- NOTE:**  
REFER TO FLOOR PLAN FOR SWITCH QUANTITIES AND LOCATIONS. \*\* DIMMABLE CONTROL
- PROVIDE MASTER BUTTON FOR ENTIRE BUILDING CONTROL (ALL INTERIOR SWITCHED LIGHTING BRANCH CIRCUITS TO BE TURNED OFF) AT SWITCH LOCATION THAT IS ADJACENT TO ALARM KEYPAD. COORDINATE EXACT LOCATION OF KEYPAD WITH ALARM CONTRACTOR AND/OR OWNER.
- KEY NOTES**
- WIRE CIRCUIT THRU LIGHTING CONTROL RELAY PANEL "RPOA". WIRE EMERGENCY / EXIT / NIGHT LIGHTS / LOCALLY CONTROLLED AREAS AHEAD OF RELAY. REFER TO OVERRIDE SWITCH SCHEDULE THIS SHEET.
  - WIRE CIRCUIT THRU LIGHTING CONTROL RELAY PANEL "RPSA". WIRE EMERGENCY / EXIT / NIGHT LIGHTS / LOCALLY CONTROLLED AREAS AHEAD OF RELAY. REFER TO OVERRIDE SWITCH SCHEDULE THIS SHEET.
  - WIRE CIRCUIT THRU LIGHTING CONTROL RELAY PANEL "RPSA". CIRCUIT CONTROLLED SEPARATELY FOR DUSK/DAWN OPERATION.
  - PROPOSED LOCATION OF RELAY PANEL OVERRIDE SWITCH. REFER TO SWITCH SCHEDULE THIS SHEET FOR ASSIGNED LIGHTING CONTROL ZONES.
  - COORDINATE ALL LIGHTING IN PARTS AREA WITH PARTS BIN SUPPLIER AND INSTALLER PRIOR TO ROUGH IN. LIGHTING TO BE CENTERED IN PARTS BIN ROWS.
  - JUNCTION BOX FOR ELECTRICAL CONNECTION TO BUILDING SIGNAGE. BRANCH PANEL CIRCUIT BREAKER WITH LOCKABLE CLIP SHALL SERVE AS DISCONNECTING MEANS FOR BUILDING SIGNAGE PER NEC ARTICLE 600.6(A)(3)(3).

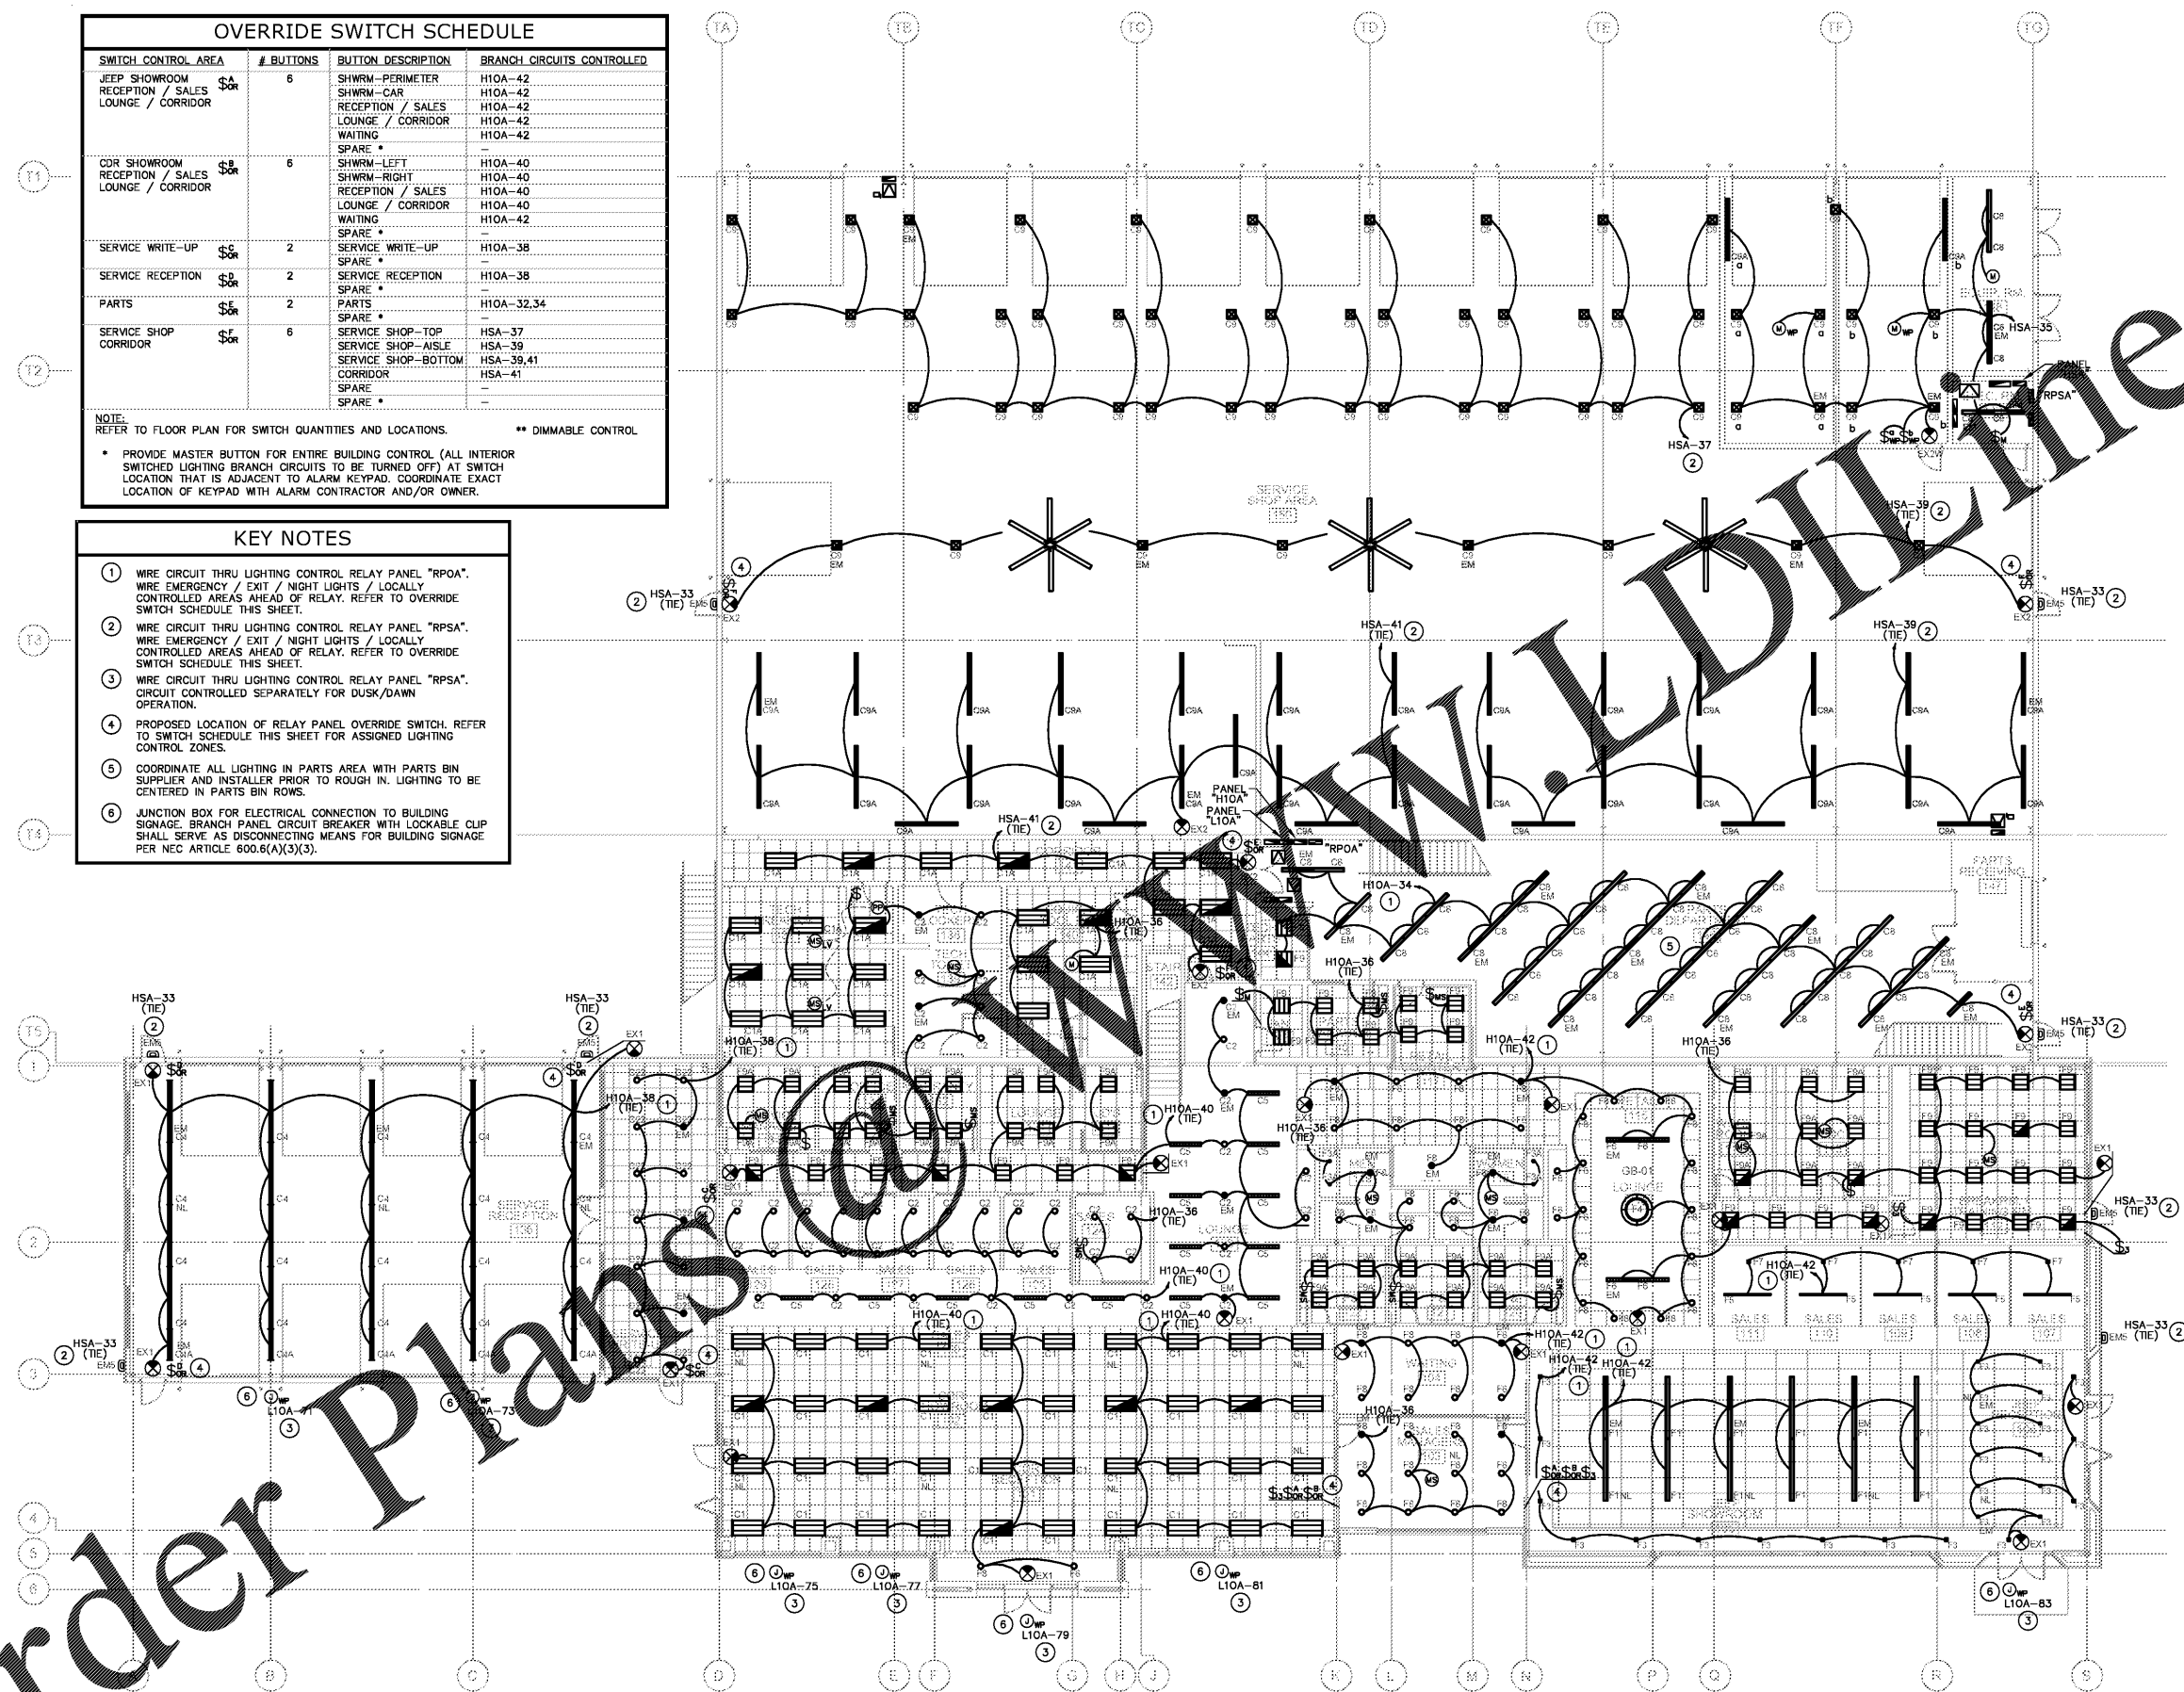

**1 FIRST FLOOR LIGHTING PLAN**  
E2.1 3/32"=1'-0"



REVISION	DATE

**ELLSWORTH ARCHITECTS**  
3136 LANIER DRIVE  
ATLANTA, GEORGIA 30319  
PHONE: 404.949.9351

**PRO BUILDING SYSTEMS**  
DESIGN BUILD CONTRACTORS  
3678 North Peachtree Road  
Atlanta, Georgia 30341  
(770) 455-1791 / Fax 455-4123  
www.probuildingsystems.com

**GINN CHRYSLER - DODGE - RAM AND JEEP**  
I-20 ACCESS ROAD  
COVINGTON GEORGIA 30040

DATE: 11.06.2018  
SCALE: AS SHOWN  
BY: GD  
JOB ID:

LIGHTING PLAN  
DRAWING TITLE

**E2.1**  
SHEET 5 OF 14

**PROMUS**  
SCOTT MERIWETHER, P.E.  
GEORGIA LICENSE #30780  
518 BLACK CANYON PARK  
CANTON, GA 30114  
PROJECT MANAGER: GEORGE DAVIDOV  
PHONE 678.246.5146

Order Plans