

Order Plans @ www.LDILine.com




REVISION DATE

ELLSWORTH ARCHITECTS
 3136 LANIER DRIVE
 ATLANTA, GEORGIA 30319
 PHONE: 404.949.9351

PRO BUILDING SYSTEMS
 DESIGN BUILD CONTRACTORS
 3678 North Peachtree Road
 Atlanta, Georgia 30341
 (770) 455-1791 / Fax 455-4123
 www.probdgsystems.com

GINN CHRYSLER - DODGE - RAM AND JEEP
 I-20 ACCESS ROAD
 COVINGTON GEORGIA 30040

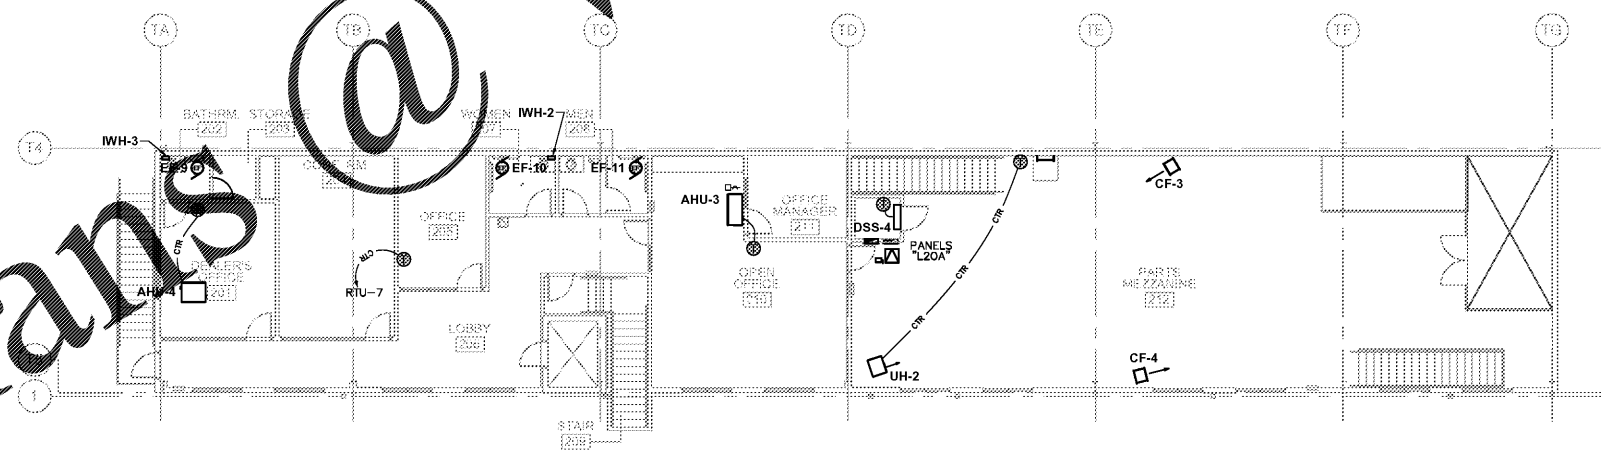

1 SECOND FLOOR MECHANICAL POWER PLAN
 3/32"=1'-0"

GENERAL MECHANICAL POWER NOTE

REFER TO SHEET E7.1, MECHANICAL EQUIPMENT-ELECTRICAL SCHEDULE, FOR POWER REQUIREMENTS TO ALL MECHANICAL EQUIPMENT / MOTORIZED DAMPERS INDICATED ON THIS SHEET.

DATE: 11.06.2018

SCALE: AS SHOWN

BY: GD

JOB ID:

SECOND FLOOR MECHANICAL POWER PLAN

DRAWING TITLE

E4.2

SHEET 9 OF 14

PROMUS
 SCOTT MERIWETHER, P.E.
 GEORGIA LICENSE #30780
 518 BLACK CANYON PARK
 CANTON, GA 30114
 PROJECT MANAGER: GEORGE DAVIDOV
 PHONE 678.246.5146