 




REVISION DATE

ELLSWORTH ARCHITECTS
 3136 LANIER DRIVE
 ATLANTA, GEORGIA 30319
 PHONE: 404.949.9351



PRO BUILDING SYSTEMS
 DESIGN-BUILD CONTRACTORS

3678 North Peachtree Road
 Atlanta, Georgia 30341
 (770) 455-1791 / Fax 455-4123
 www.probdgsystems.com


GINN CHRYSLER - DODGE - RAM AND JEEP
 I-20 ACCESS ROAD
 COVINGTON GEORGIA 30040

DATE: 11.06.2018
 SCALE: AS SHOWN
 BY: GD
 JOB ID:

ROOF MECHANICAL POWER PLAN
 DRAWING TITLE

E4.3

SHEET 10 OF 14

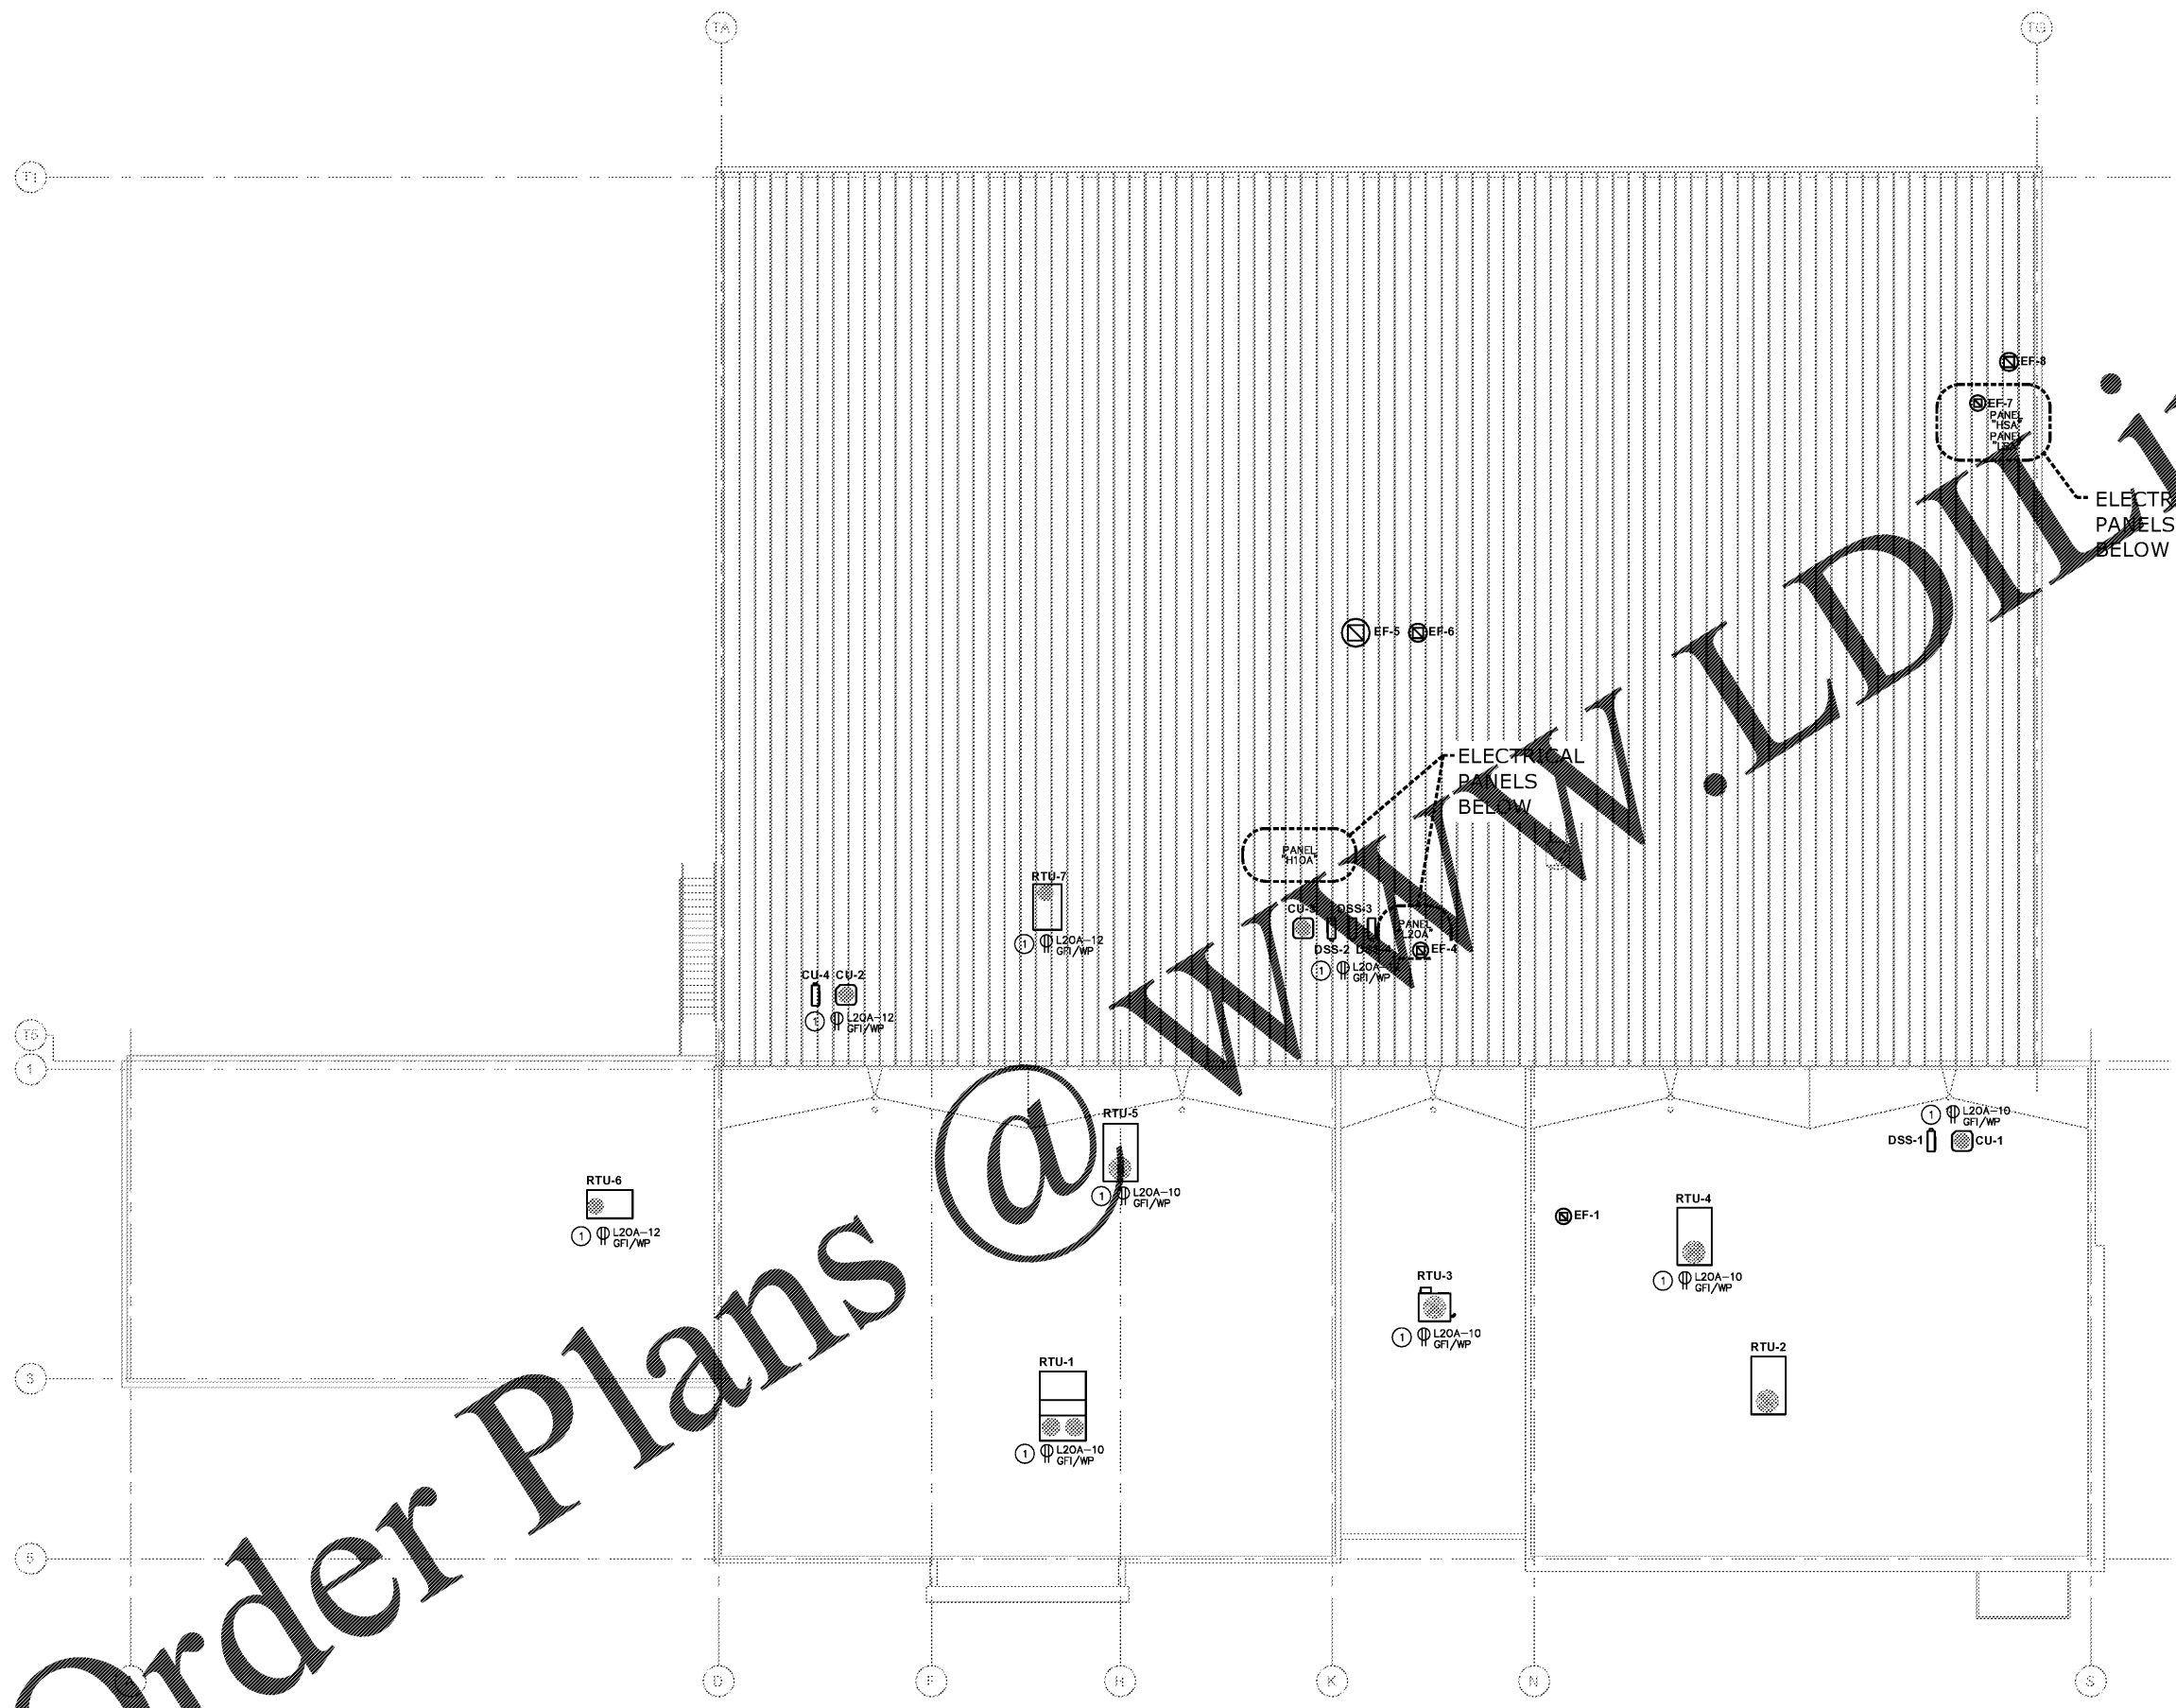

KEY NOTE

① RECEPTACLE LOCATED ON MECHANICAL ROOFTOP EQUIPMENT, AVOID ACCESS PANELS AND LOUVERS.

GENERAL MECHANICAL POWER NOTE

REFER TO SHEET E7.1, MECHANICAL EQUIPMENT-ELECTRICAL SCHEDULE, FOR POWER REQUIREMENTS TO ALL MECHANICAL EQUIPMENT / MOTORIZED DAMPERS INDICATED ON THIS SHEET.

Order Plans @ www.lldivline.com

1 ROOF MECHANICAL POWER PLAN
 E4.3 3/32"=1'-0"

PROMUS
 SCOTT MERIWETHER, P.E.
 GEORGIA LICENSE #30780
 518 BLACK CANYON PARK
 CANTON, GA 30114
 PROJECT MANAGER: GEORGE DAVIDOV
 PHONE 678.246.5146