


IPC 2012 TABLE 1106.3	
1/8 UNIT VERTICAL IN 12 UNITS HORIZONTAL (1-PERCENT SLOPE)	RAINFALL RATE (INCHES/HR) 4
SIZE OF HORIZONTAL PIPING (INCHES)	HORIZONTALLY PROJECTED ROOF AREA (SQ. FT.)
3	827
4	1,800
6	3,000
8	11,000
10	20,700
12	33,300



REVISION	DATE

 
- KEY NOTES**
- GAS LINE FROM SHOWROOM. SEE SHEET P3.1 FOR CONTINUATION.
 - PROVIDE GAS CONNECTION WITH PRESSURE REGULATOR FROM 2.0 PSI TO 0.5 PSI (TYPICAL OF ALL). SEE GAS CONNECTION DETAIL ON SHEET P001.
 - TERMINATE 3/4" CONDENSATE LINE OVER SPLASHBLOCK ON ROOF.

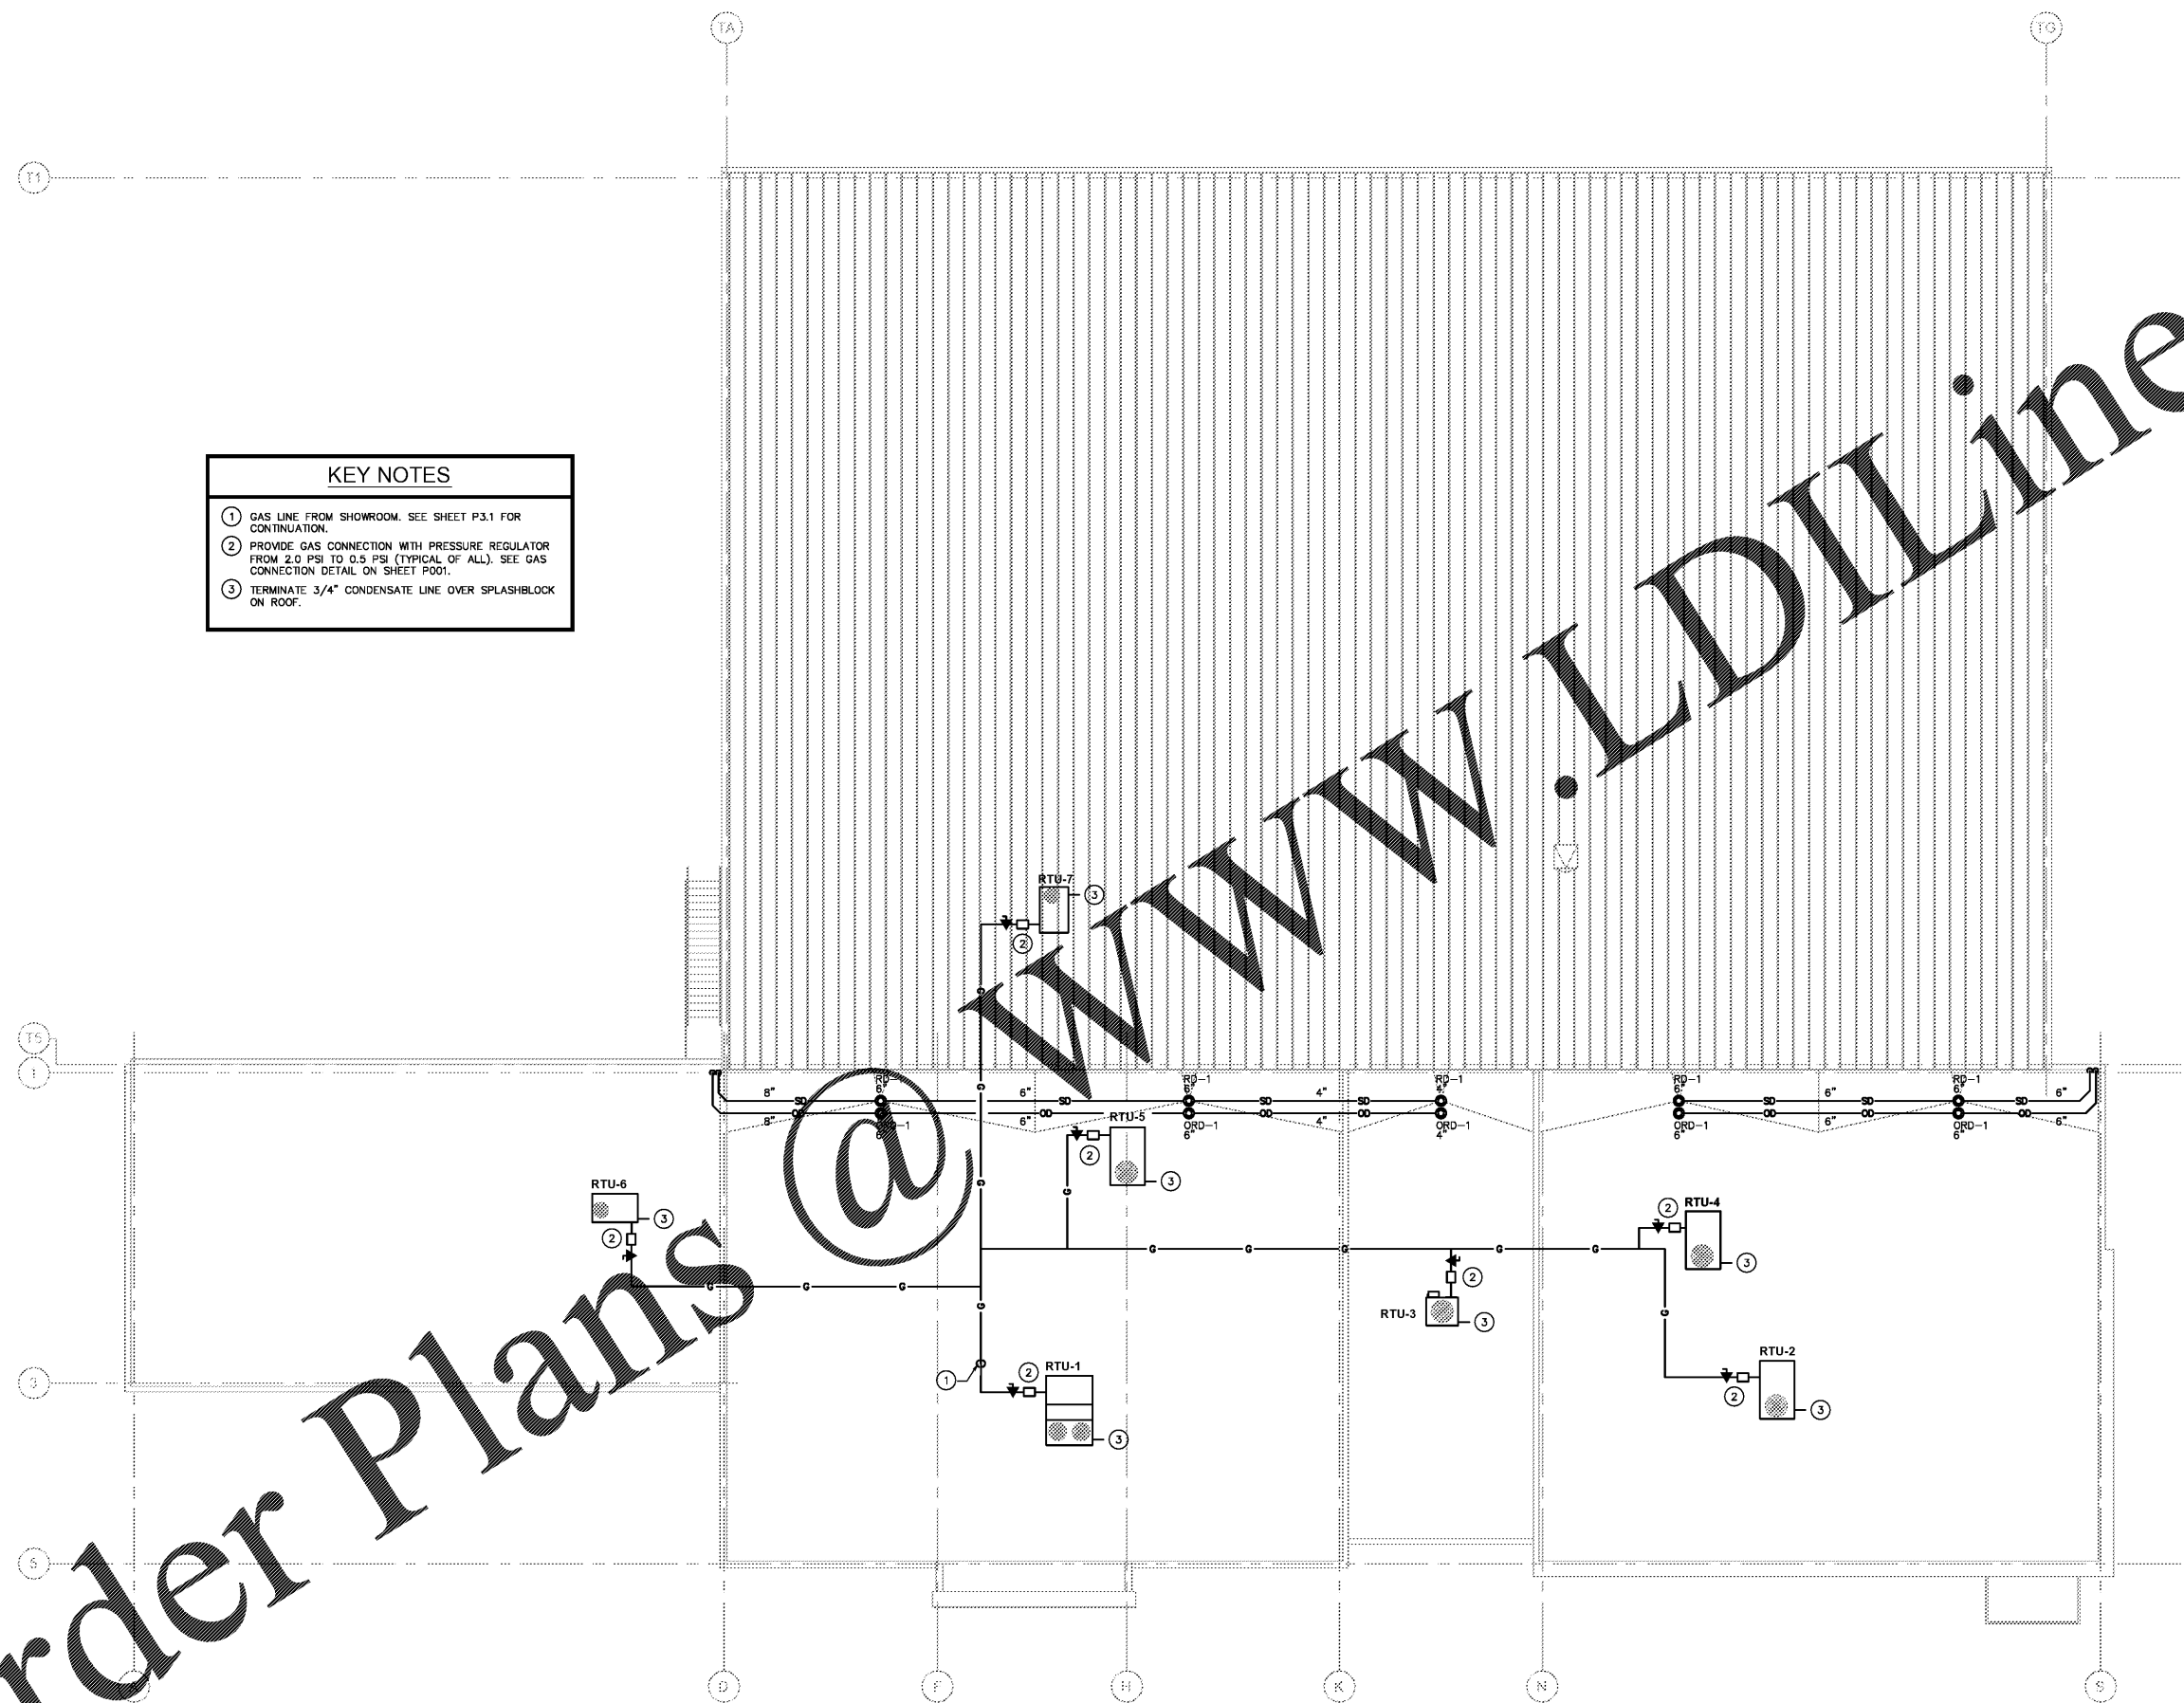

Order Plans @

1 ROOF PLUMBING PLAN
3/32"-1'-0"

ELLSWORTH ARCHITECTS
3136 LANIER DRIVE
ATLANTA, GEORGIA 30319
PHONE: 404.949.9351



PRO BUILDING SYSTEMS
DESIGN BUILD CONTRACTORS
3678 North Peachtree Road
Atlanta, Georgia 30341
(770) 455-1791 / Fax 455-4123
www.probuildingsystems.com

GINN CHRYSLER - DODGE - RAM AND JEEP
1-20 ACCESS ROAD
COVINGTON GEORGIA 30040

DATE: 11.06.2018
SCALE: AS SHOWN
BY: GD
JOB ID:

ROOF PLUMBING PLAN
DRAWING TITLE

PROMUS
SCOTT MERIWETHER, P.E.
GEORGIA LICENSE #30780
518 BLACK CANYON PARK
CANTON, GA 30114
PROJECT MANAGER: GEORGE DAVIDOV
PHONE 678.246.5146

P2.3
SHEET 5 OF 8