 




REVISION DATE

ELLSWORTH ARCHITECTS
 3136 LANIER DRIVE
 ATLANTA, GEORGIA 30319
 PHONE: 404.949.9351



PRO BUILDING SYSTEMS
 DESIGN BUILD CONTRACTORS

3678 North Peachtree Road
 Atlanta, Georgia 30341
 (770) 455-1791 / Fax 455-4123
 www.probdgsystems.com

GINN CHRYSLER - DODGE - RAM AND JEEP
 I-20 ACCESS ROAD
 COVINGTON GEORGIA 30040

DATE: 11.06.2018

SCALE: AS SHOWN

BY: GD

JOB ID:

FIRST FLOOR DOMESTIC WATER PLAN

DRAWING TITLE


P3.1

SHEET 6 OF 8

- KEY NOTES**
- 2" COLD WATER LINE BELOW GRADE. SEE CIVIL PLANS FOR CONTINUATION.
 - 6" FIRE SPRINKLER LINE BELOW GRADE. SEE CIVIL PLANS FOR CONTINUATION.
 - 2" COLD WATER RISER. SEE WATER SERVICE ENTRANCE DETAIL ON SHEET P0.1.
 - 6" FIRE SPRINKLER RISER.
 - COLD WATER LINE TO SECOND FLOOR. SEE SHEET P2.2 FOR CONTINUATION.
 - HIGH PRESSURE GAS LINE BELOW GRADE BY GAS COMPANY.
 - GAS METER AND MAIN SHUT OFF VALVE.
 - GAS LINE TRANSITIONS DOWN TO FIRST FLOOR CEILING.
 - GAS LINE TRANSITIONS UP TO HIGHER CEILING.
 - GAS LINE TO PARTS SECOND FLOOR. SEE SHEET P2.2 FOR CONTINUATION.
 - WATER LINE TRANSITIONS UP TO HIGHER CEILING.
 - GAS LINE TO ROOF. SEE SHEET P2.3 FOR CONTINUATION.
 - PROVIDE GAS CONNECTION WITH PRESSURE REGULATOR FROM 2.0 PSI TO 0.5 PSI (TYPICAL OF ALL). SEE GAS CONNECTION DETAIL, ON SHEET P001.
 - RPZ BACKFLOW PREVENTOR.
 - PROVIDE WATER CONNECTION FOR PRESSURE WASHER. COORDINATE EXACT REQUIREMENTS WITH SHOP EQUIPMENT VENDOR.
 - INSTALL WATER HEATER ON PLATFORM ABOVE SINK. SEE SHEET P0.1 FOR DETAIL.
 - PROVIDE FILTERED COLD WATER CONNECTION FOR COFFEE MAKER. PROVIDE UNDERCOUNTER HOSHIZAKI H9320-51 WATER FILTER WITH REPLACEMENT CARTRIDGE. PROVIDE BUANN 0171.0001 CHECK VALVE. COORDINATE EXACT LOCATION WITH ARCHITECTURAL DRAWINGS.
 - PROVIDE CHILLER FOR DRINKING FOUNTAIN ABOVE ACCESSIBLE CEILING. SEE PLUMBING FIXTURE SCHEDULE ON SHEET P0.1.

GENERAL NOTE

ALL PLUMBING RISERS IN SERVICE/FINISHED AREAS TO BE CONCEALED IN WALL.

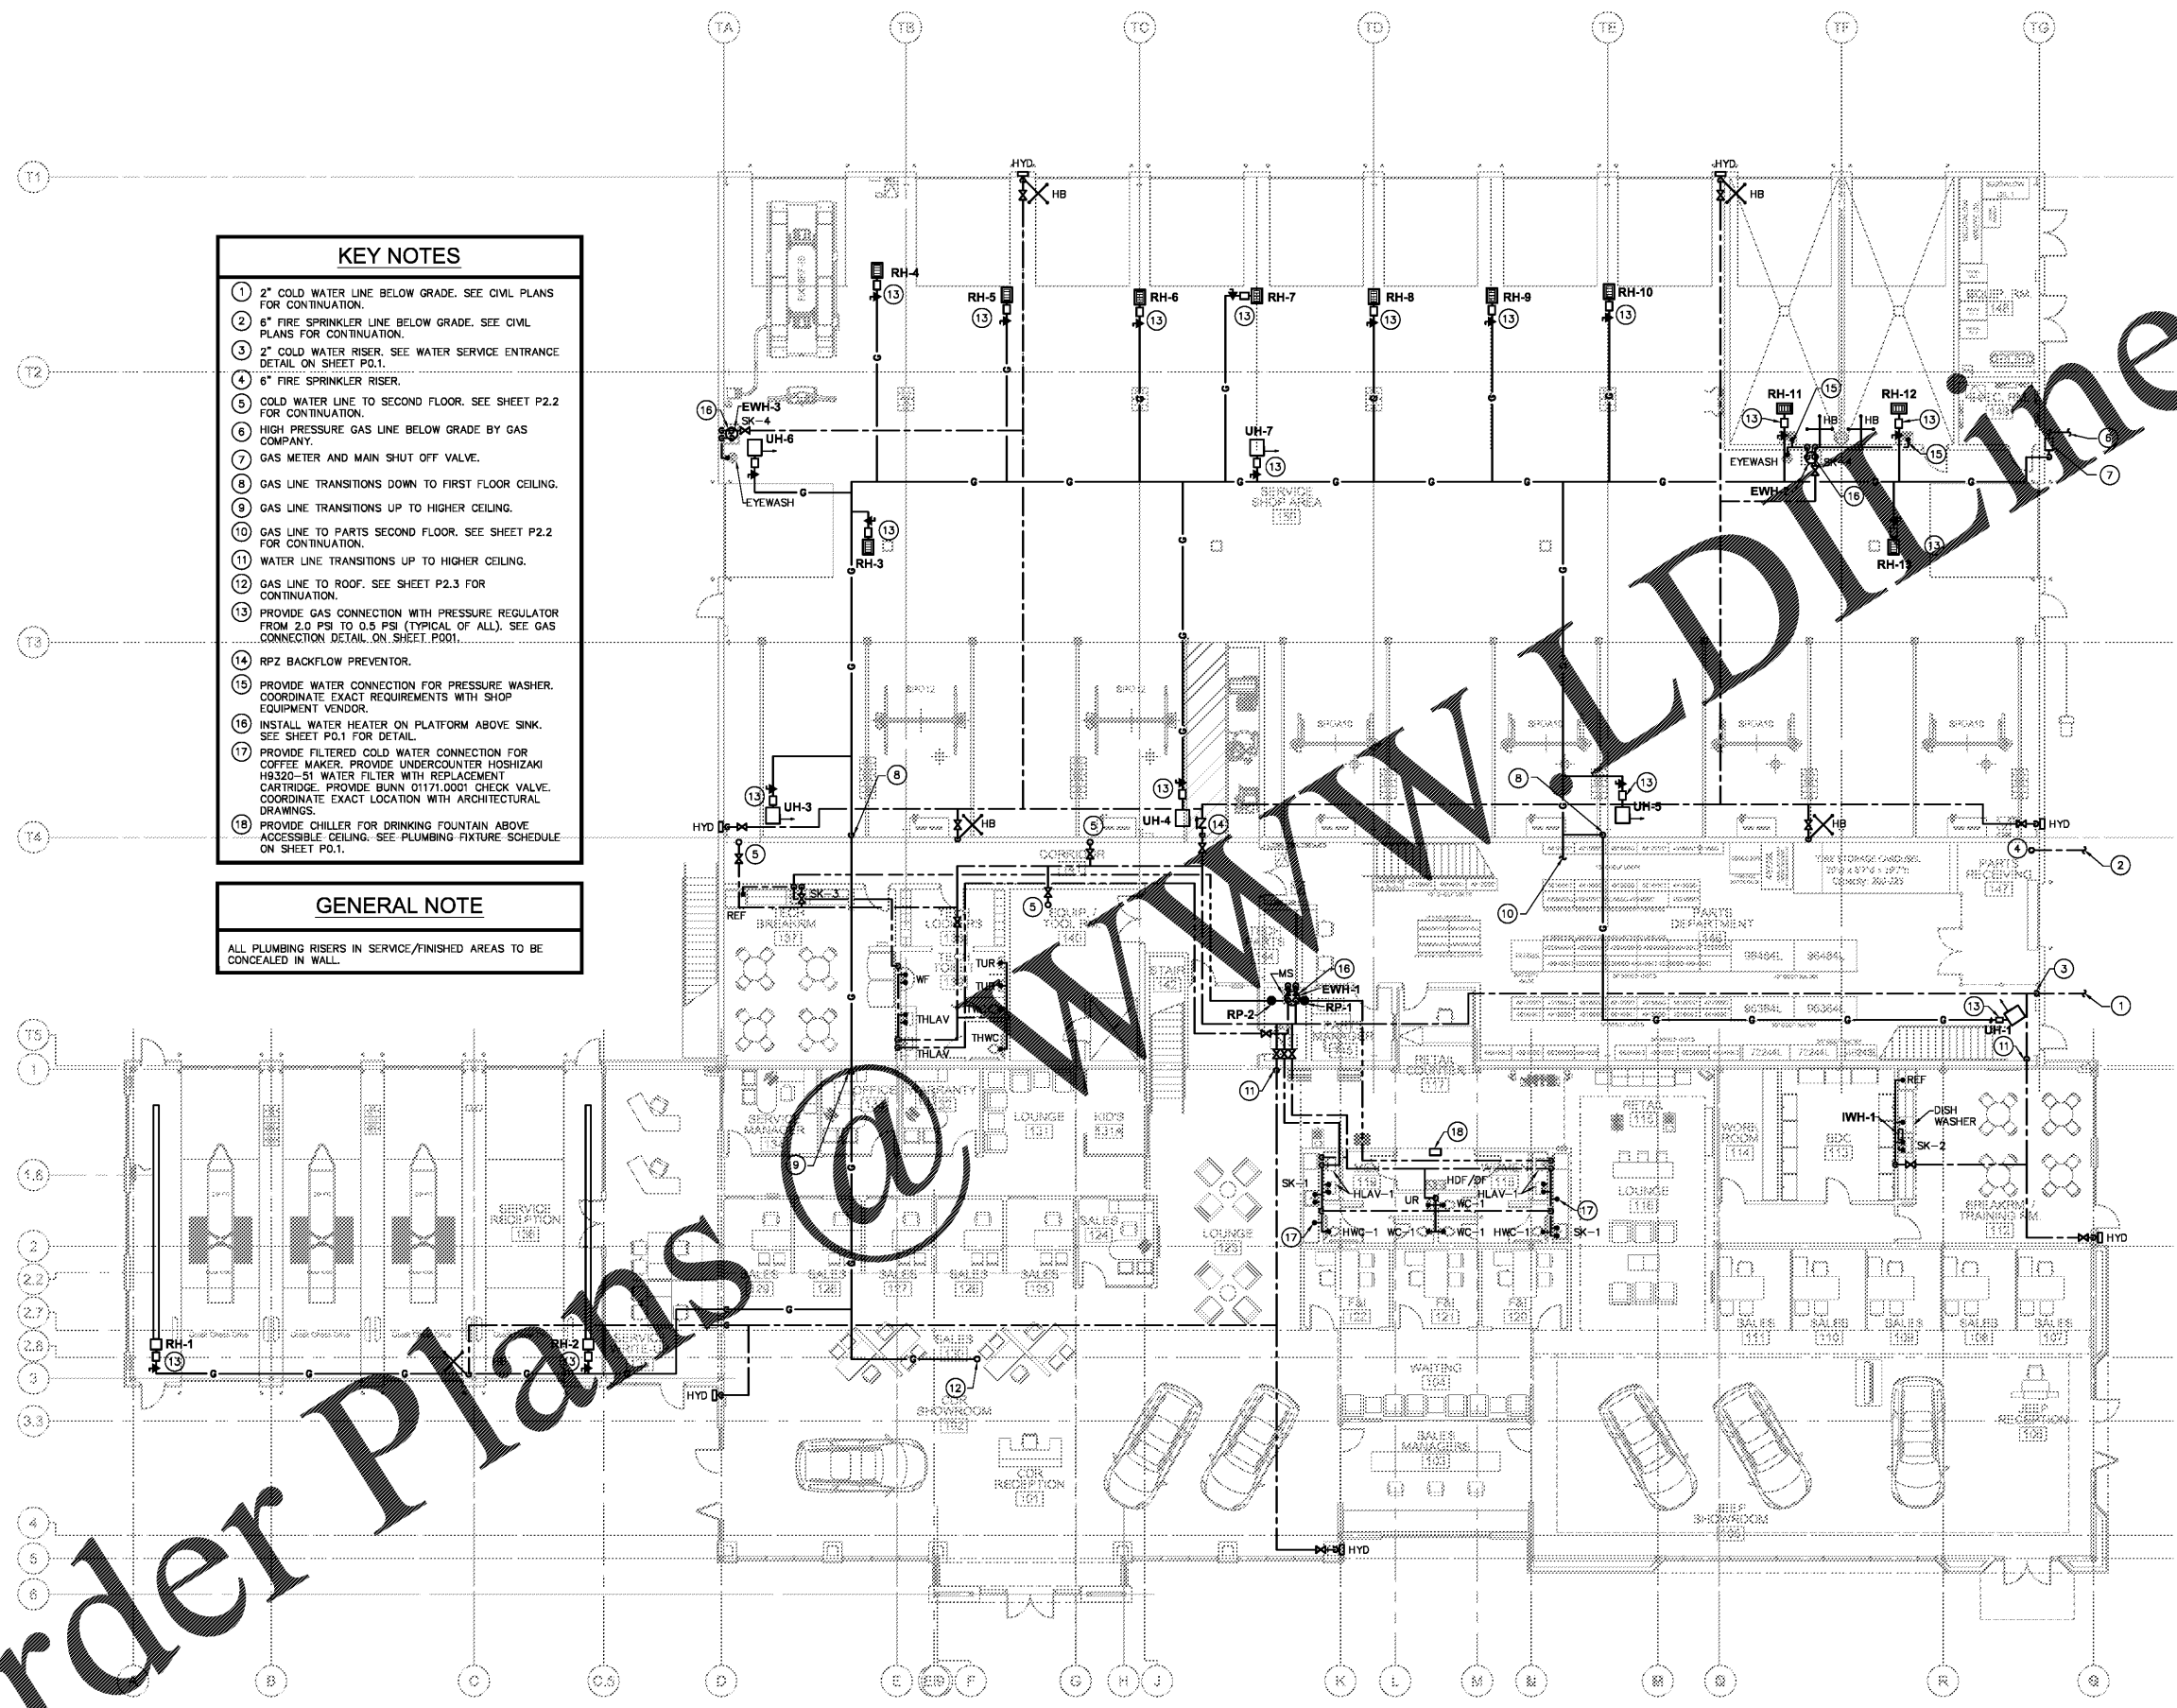

1 FIRST FLOOR DOMESTIC WATER PLAN
 P3.1 3/32"=1'-0"

PROMUS
 SCOTT MERIWETHER, P.E.
 GEORGIA LICENSE #30780
 518 BLACK CANYON PARK
 CANTON, GA 30114
 PROJECT MANAGER: GEORGE DAVIDOV
 PHONE 678.246.5146

Order Plans @