




12000 Peachtree Dunwoody Rd. Suite 100  
Atlanta, Georgia 30328  
404.251.1111  
865.544.1111  
www.dollarandfurs.com

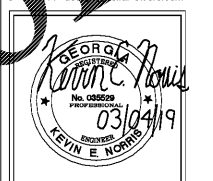

NO.	REVISIONS

A With-in-the-Walls Remodel for:

# KROGER STORE #GA-483 SNELLVILLE

1670 STATE HWY 124, SUITE 'F', SNELLVILLE, GEORGIA 30078

## LIGHTING PLAN


**COPYRIGHT**  
 All drawings, specifications and computer programs are the property of D&E Dollar & Furs, Inc. and shall remain the property of D&E Dollar & Furs, Inc. No part of this drawing may be reproduced or transmitted in any form or by any means, electronic, mechanical, photocopying, recording, or by any information storage and retrieval system, without the prior written permission of D&E Dollar & Furs, Inc. This drawing is to be used only for the project and location specified herein. Any other use is prohibited. © 2019 D&E Dollar & Furs, Inc.

**COPYRIGHT**

ISSUE DATE: March 04, 2019  
 PROJECT NO: 219206 / 19001  
 SHEET NUMBER: **E1.1**

- GENERAL ELECTRICAL NOTES:**
- ALL WIRING FOR THIS PROJECT SHALL BE INSTALLED IN A MINIMUM OF 3/4" EMT CONDUITS WITH #10 AND "THIN" COPPER PHASE, NEUTRAL AND GROUND CONDUCTORS UNLESS NOTED OTHERWISE. DO NOT COMBINE CONDUITS AS INDICATED ON THE ELECTRICAL DRAWINGS.
  - ALL WIRING SHALL BE CONCEALED WITH-IN EXISTING WALLS UNLESS NOTED OTHERWISE.
  - ALL EXPOSED CONDUITS IN SALES AREA SHALL INSTALL SQUARE TO THE EXISTING BUILDING FRAME AND BE PAINTED WITH A MINIMUM OF TWO COATS FOR PAINT TO MATCH EXISTING WALLS AND CEILING.
  - CONTRACTOR SHALL SCHEDULE POWER OUTAGE FOR INSTALLATION OF NEW BREAKERS WITH IN EXISTING PANELS WITH KROGER PROJECT MANAGER AND STORE MANAGER AND MINIMUM OF SIX DAYS BEFORE PERFORMING ELECTRICAL WORK TO EXISTING PANELS.

- LIGHTING PLAN NOTES:**
- NEW "B2" SIX LAMP 4' X 4' RECENT HIGH BAY FIXTURES WITH 100% BALLAST FOR OUTSIDE LAMPS AND 100% BALLAST FOR INSIDE LAMPS SHALL BE SPLIT WIRED PER DETAIL ON SHEET E-1.1.
  - EXISTING "T8" AND "T5" CIRCULATORS SHALL REMAIN IN EXISTING PANELS AND THE PANEL SHALL CONTROL THE INSIDE LAMPS.
  - EXISTING TRANSFORMERS SHALL BE RELOCATED TO NEW LOCATIONS AS SHOWN. SEE HANGING DETAILS AND ESD-00A.
  - CONTRACTOR SHALL CONNECT NEW LIGHTING CONTROLS TO EXISTING "CPC" CONTROL SYSTEM AS PER ESD-01-3.
  - CONNECT NEW 2X4 LAY-IN FIXTURES OVER SERVICE CASES IN MEAT/SEAFOOD AND DELI/BAKERY TO EXISTING SWITCHED LIGHTING 277 VOLT LIGHTING CIRCUIT AS REQUIRED.
  - ALL NEW AND EXISTING LIGHTS CONNECTED TO PANEL "N01" ARE CONNECTED TO NEW GENERATOR VIA AUTOMATIC TRANSFER SWITCH "ATS".
  - ALL TYPE "B" FIXTURES ARE EXISTING FIXTURES RELOCATED TO NEW LOCATIONS AS SHOWN. RECONNECT TO EXISTING LIGHTING CIRCUITS AS REQUIRED.
  - ALL TYPE "EY" FIXTURES ARE EXISTING FIXTURES TO REMAIN AS IS.
  - ALL "EXIT" SIGNS ARE PHOTO LUMINESCENT TYPE. SEE SPECIFICATION SECTION 14.43. ALL "EXIT" SIGNS ARE FURNISHED AND INSTALLED BY GENERAL CONTRACTOR.

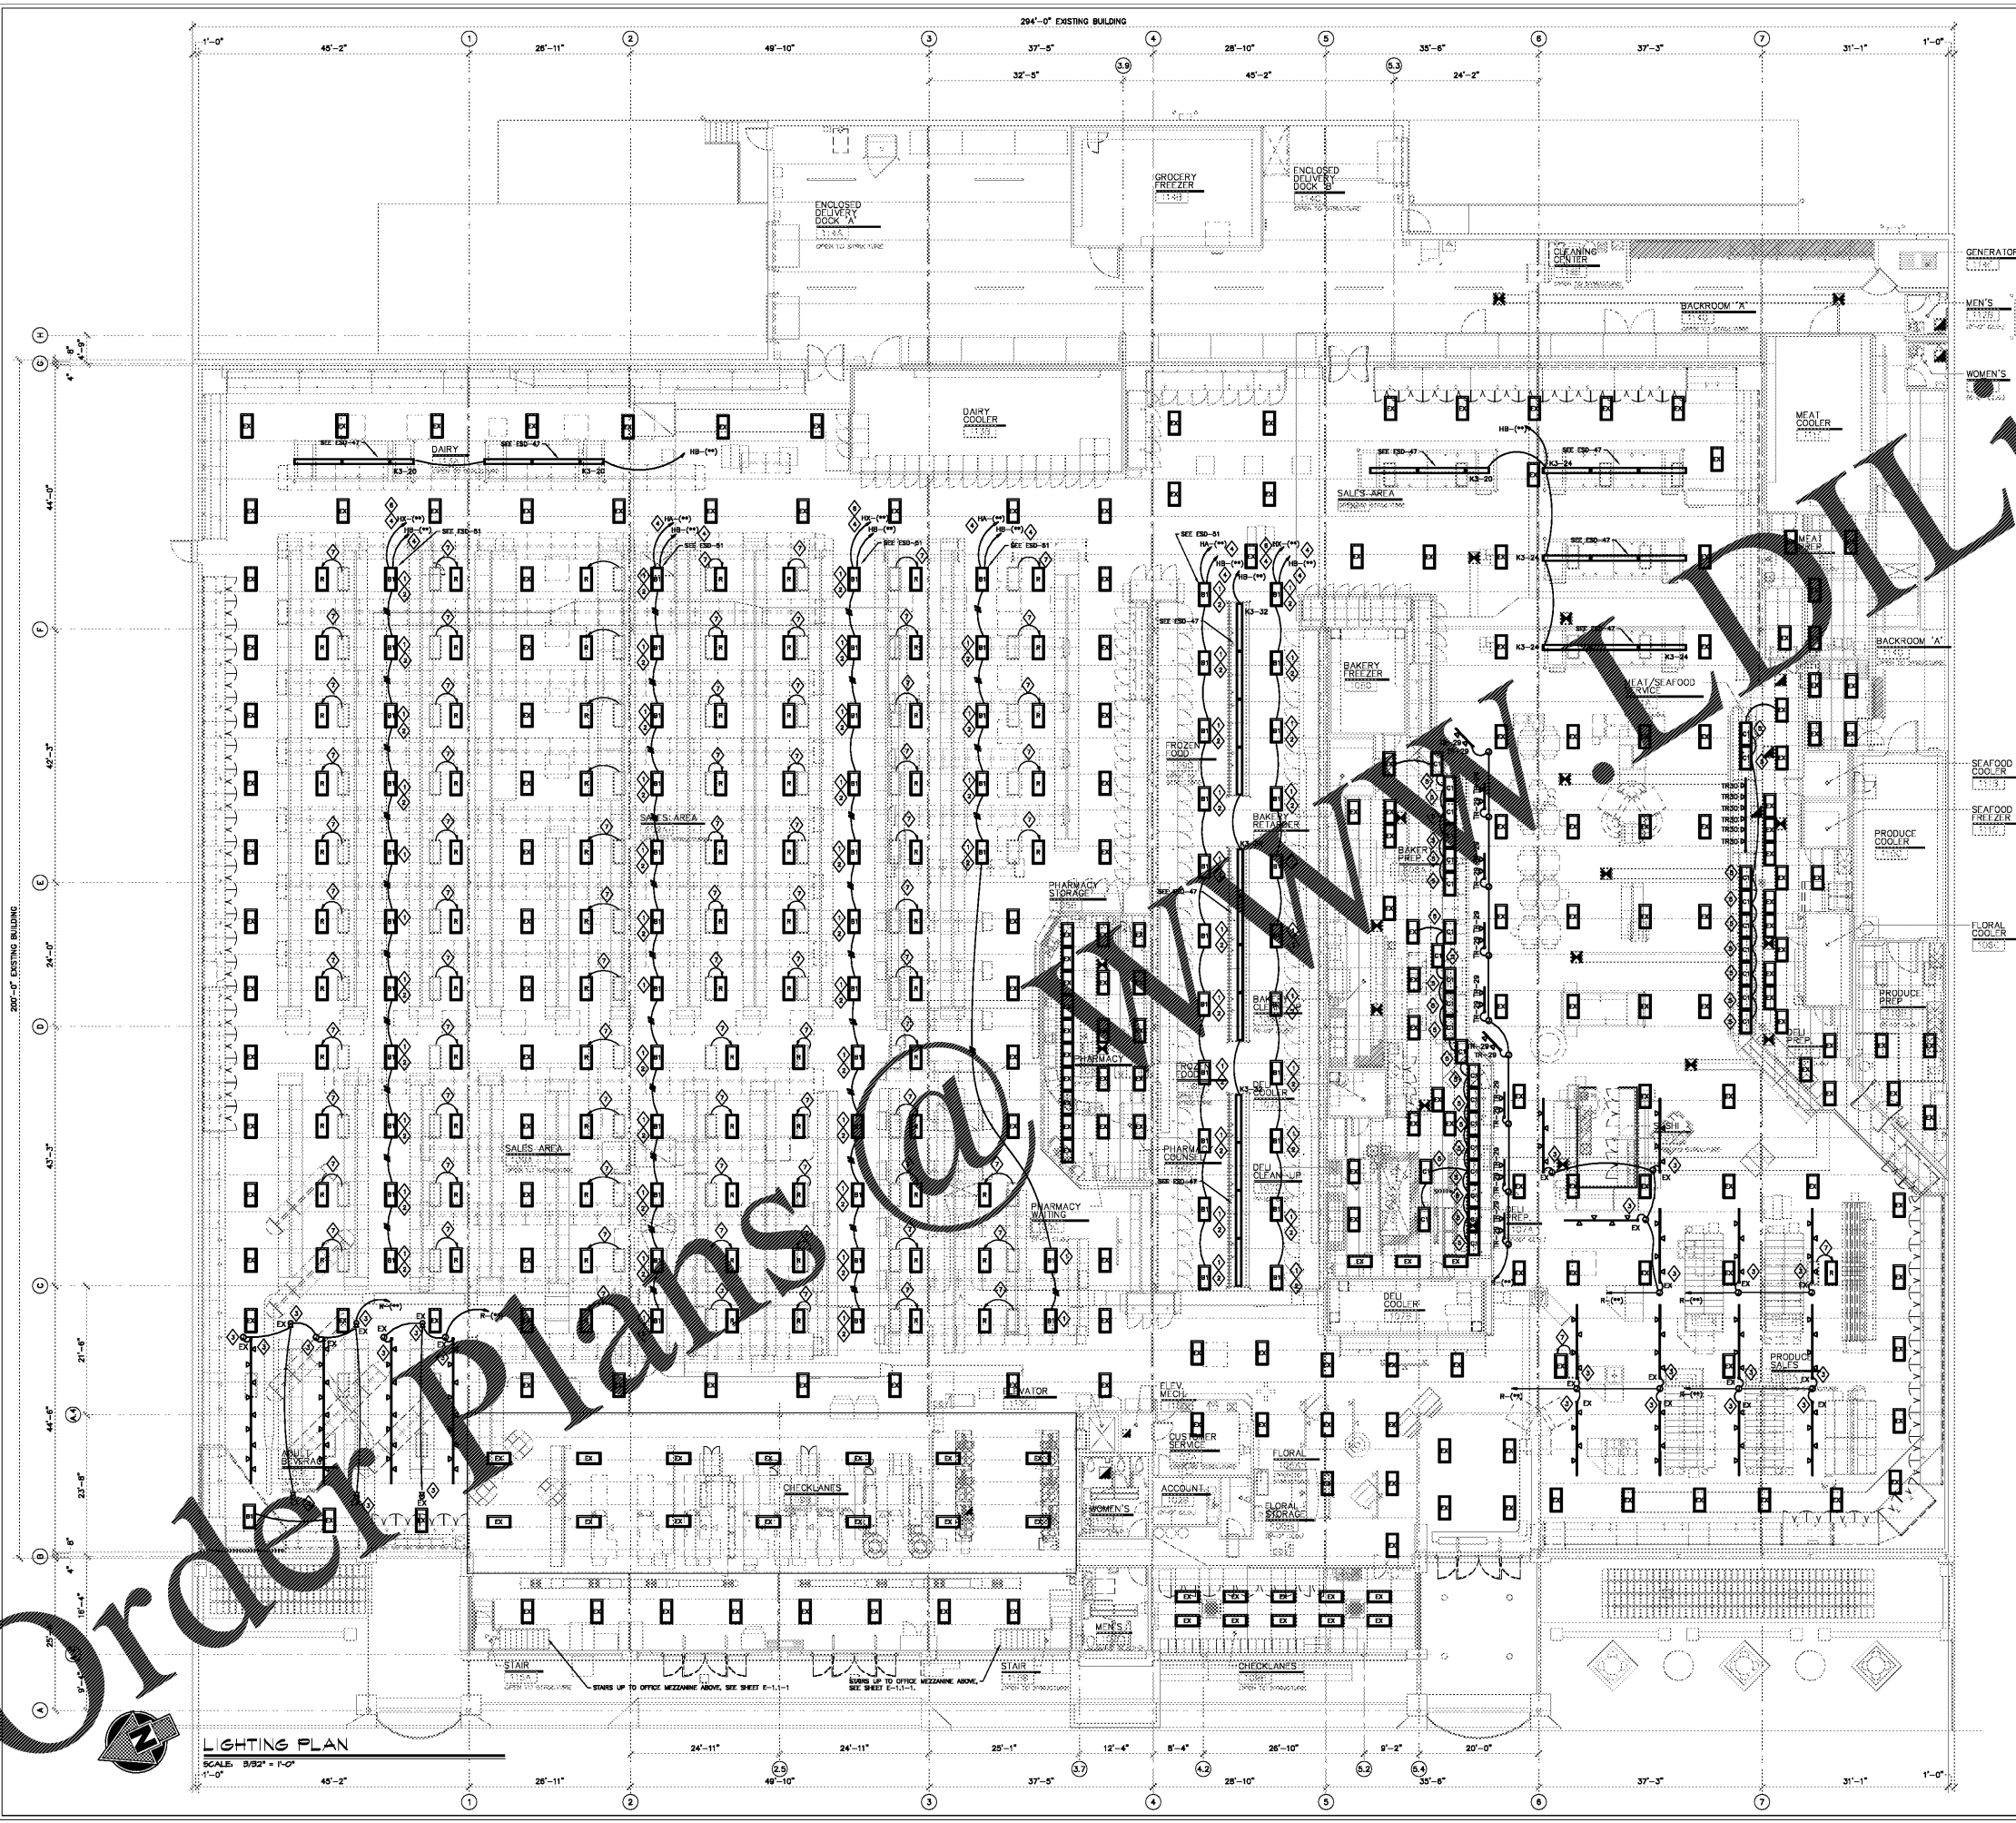

**LIGHTING PLAN**  
 SCALE: 3/32" = 1'-0"

KEVIN E. NORRIS  
 ELECTRICAL ENGINEER

5518 WALLWOOD ROAD  
 KNOXVILLE, TN 37912  
 PHONE: (615) 584-3063

Order Plans @ WWW.DOLLARANDFURS.COM