



Order Plans @ www.LDIIline.com

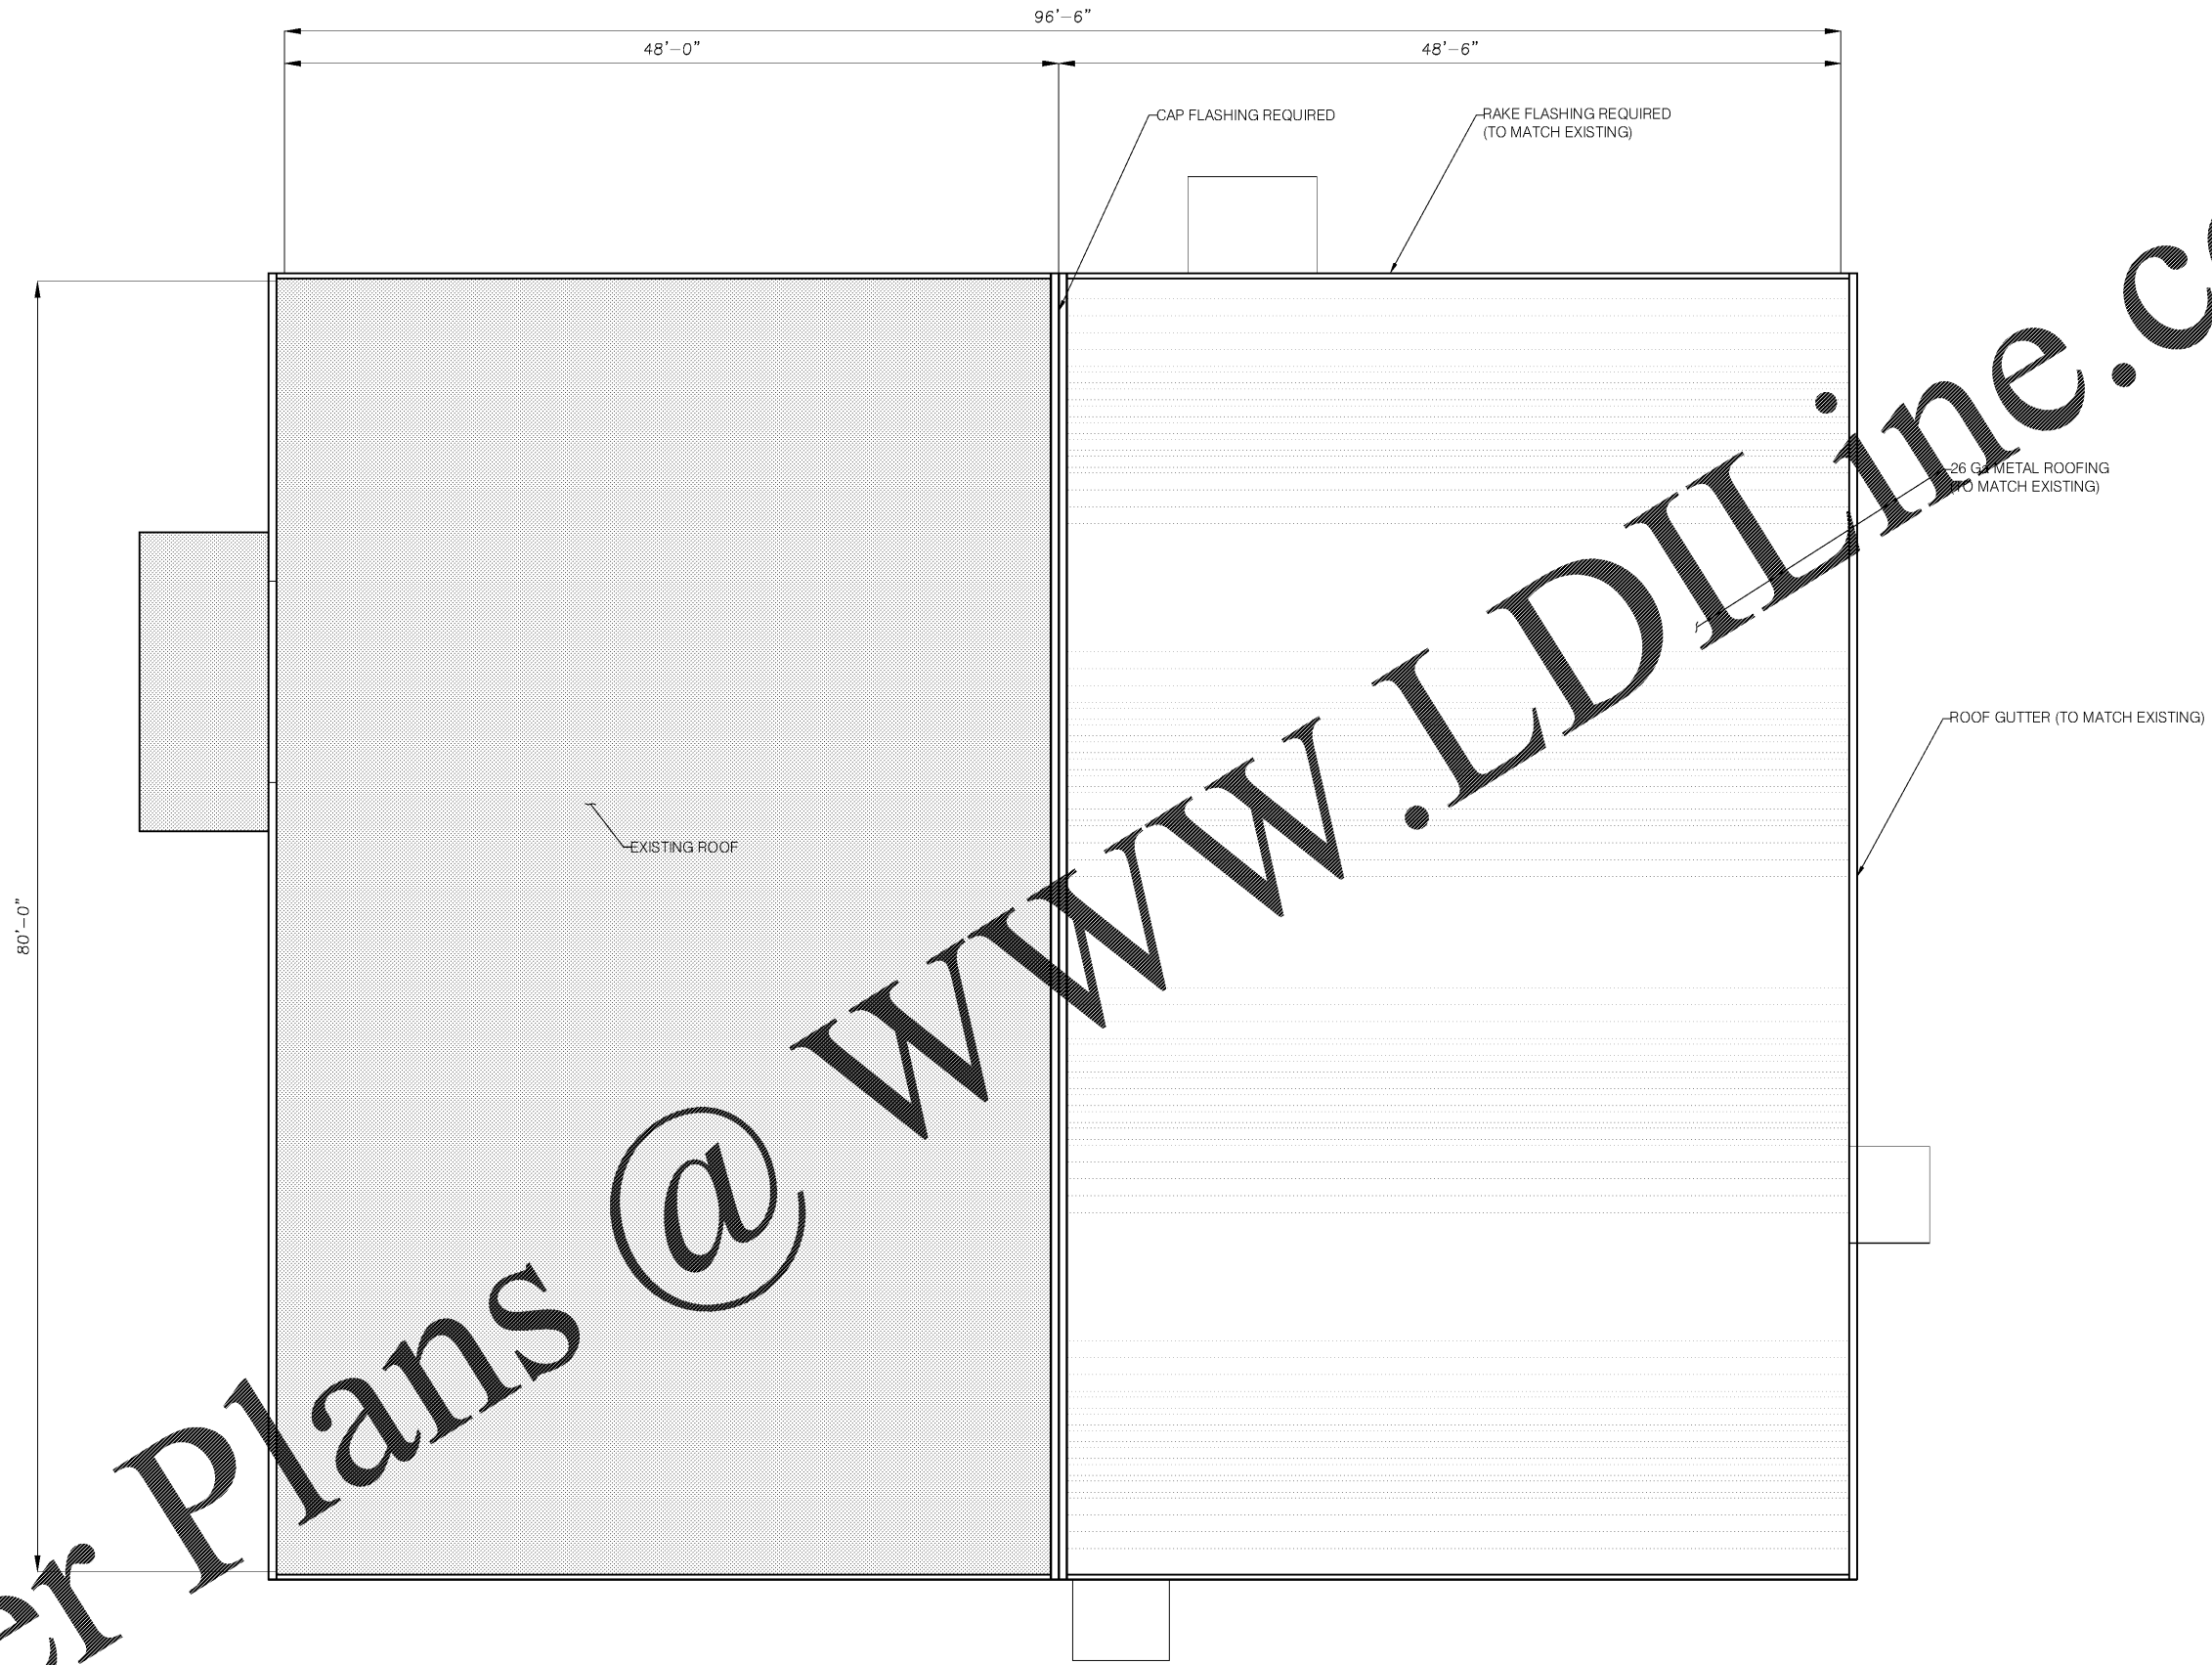

PROPOSED ROOF PLAN
SCALE: 3/16" = 1'-0"

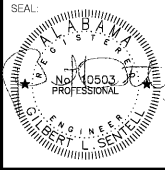

SENNELL
 ENGINEERING
 CIVIL · STRUCTURAL · ENVIRONMENTAL · SURVEYING
 639 Black Bears Way
 Tuscaloosa, AL 35401
 Phone: (205) 752-5564
 www.sennell.net

JEFFERSON COUNTY
 BRIGHTON COMMUNITY CENTER PROJECT
 BRIGHTON, ALABAMA 35020

NO.	DATE	DESCRIPTION

DRAWN: GLS
 CHECKED: GLS
 DATE: 8/31/2018
 JOB NO: 18-119
 SHEET: S2