


Order Plans @


www.LDOnline.com

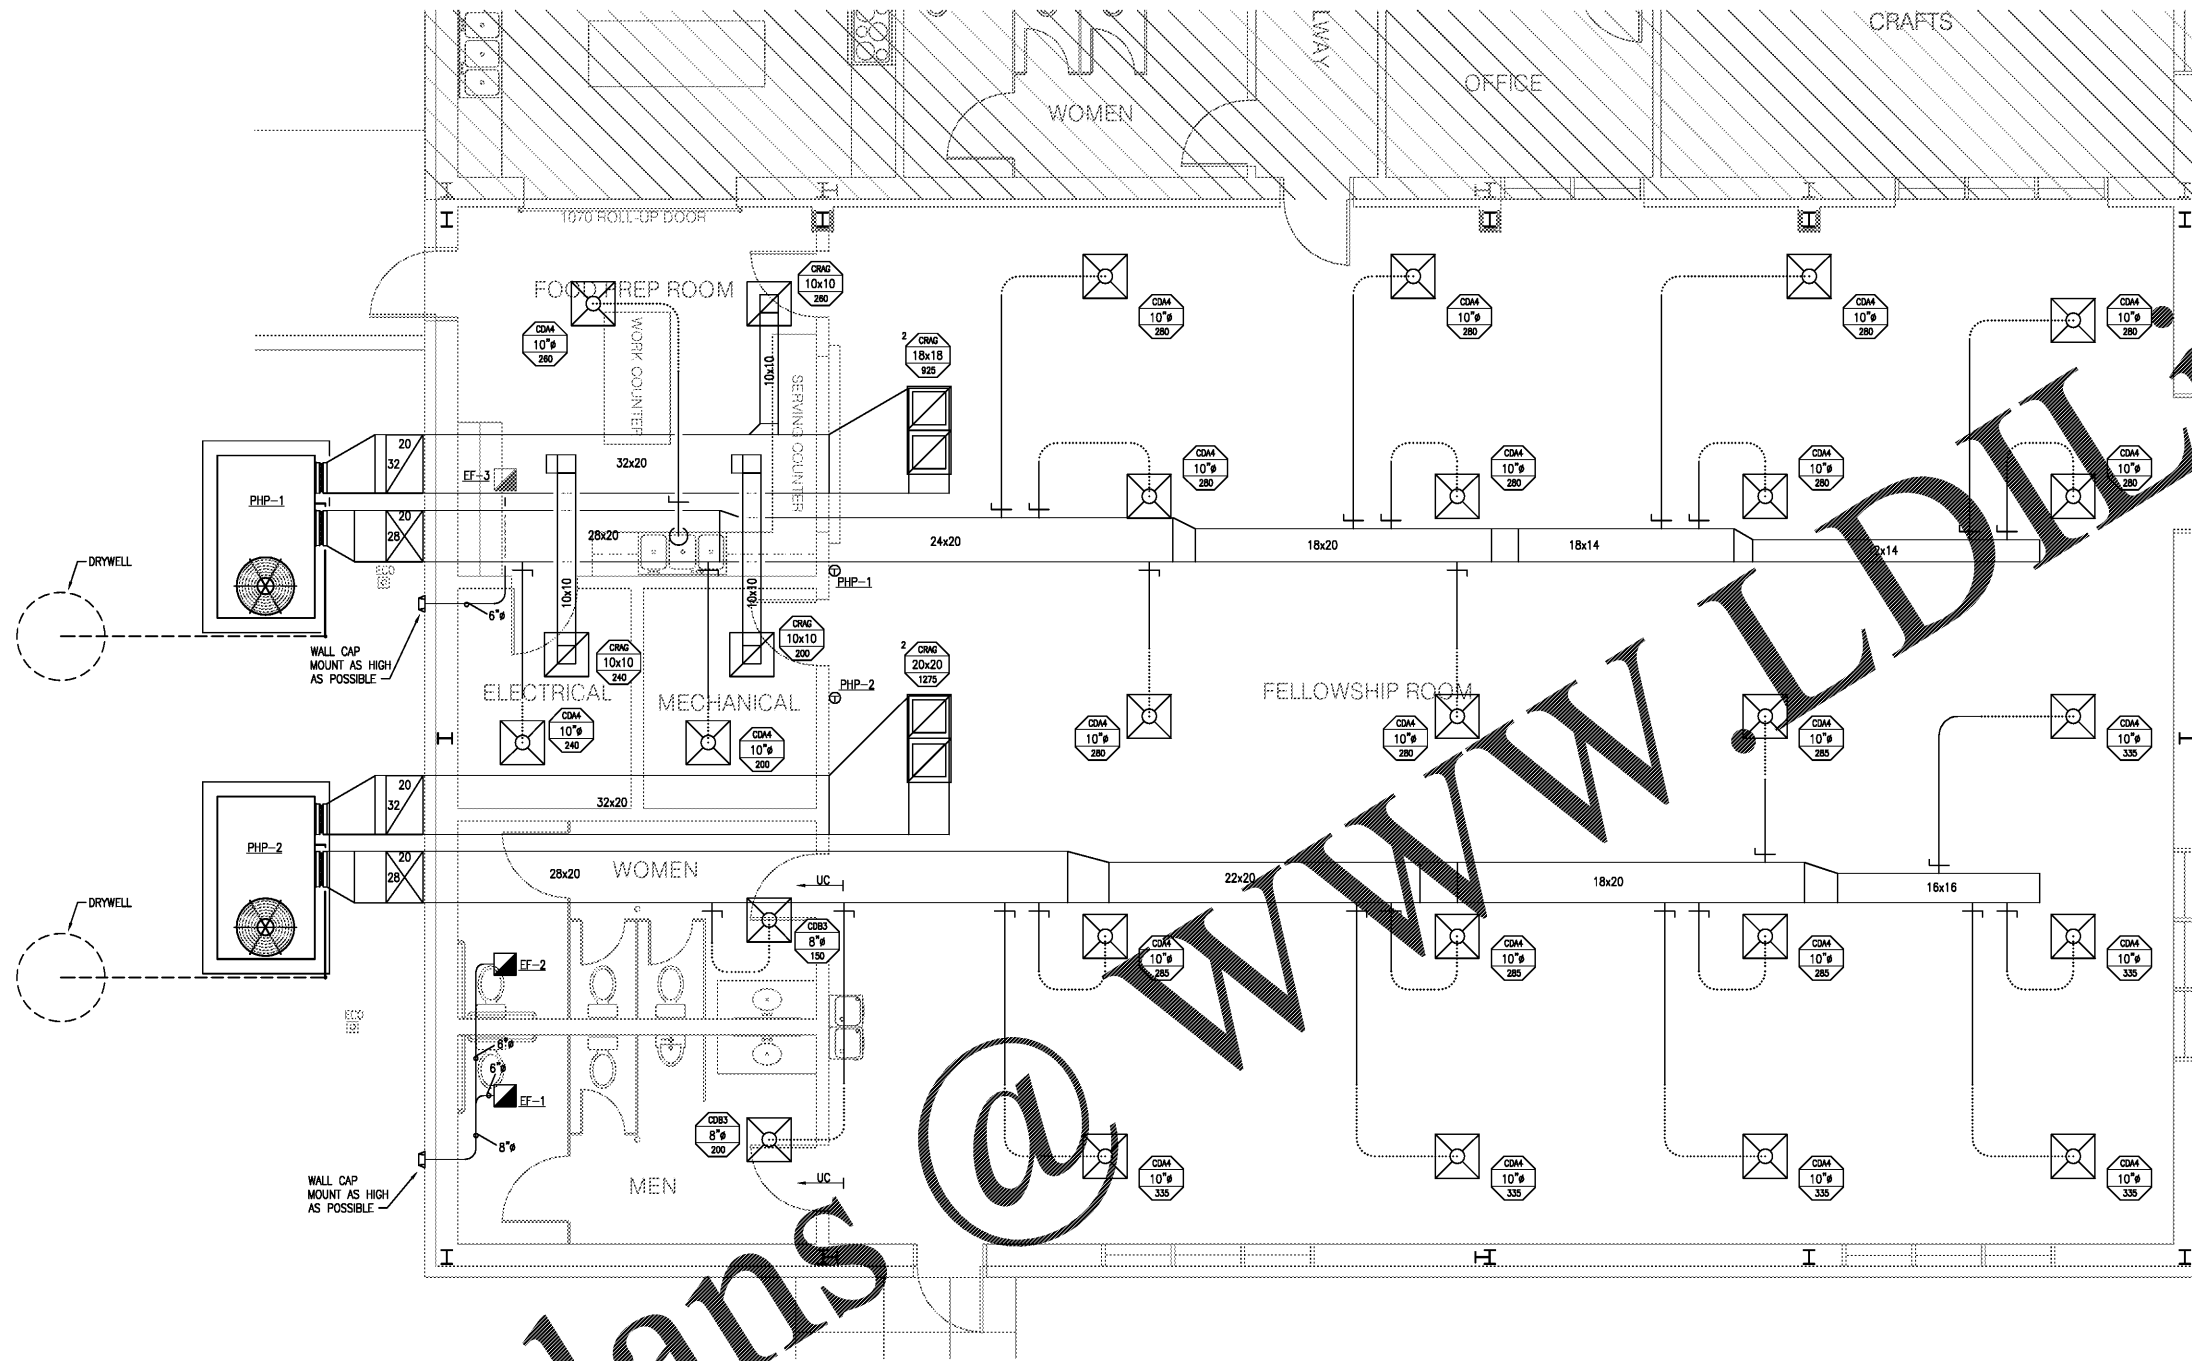

1 HVAC PLAN
M101 1/4" = 1' - 0"



SENTINELL
CIVIL - STRUCTURAL - ENVIRONMENTAL - SURVEYING
ENGINEERING

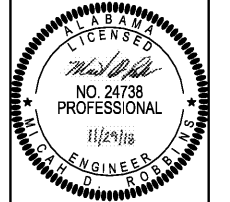

BRIGHTON COMMUNITY CENTER
BLOCK 17 OF OAKDALE SURVEY, MAP BOOK 2, PAGE XX
SECTION 27, TOWNSHIP 18 SOUTH, RANGE 4 WEST
JEFFERSON COUNTY, ALABAMA

NO.	DATE:	DESCRIPTION:

ROBBINS
Engineering
Company, LLC

Mechanical & Electrical
5945 Knight Ave, Suite B, Tuscaloosa, Alabama 35405
Phone: (205) 391-7049
http://www.ro-engineers.com

VERIFY SCALES
BUT IS ONE INCH
ON ORIGINAL, INC.
IF NOT ONE INCH
ON THIS SHEET
ADJUST SCALE
ACCORDINGLY

HVAC PLAN
DATE: 11-29-18
JOB NO: 18-119
SHEET: M101

Permit Drawings REC Project 18092