


Order Plans

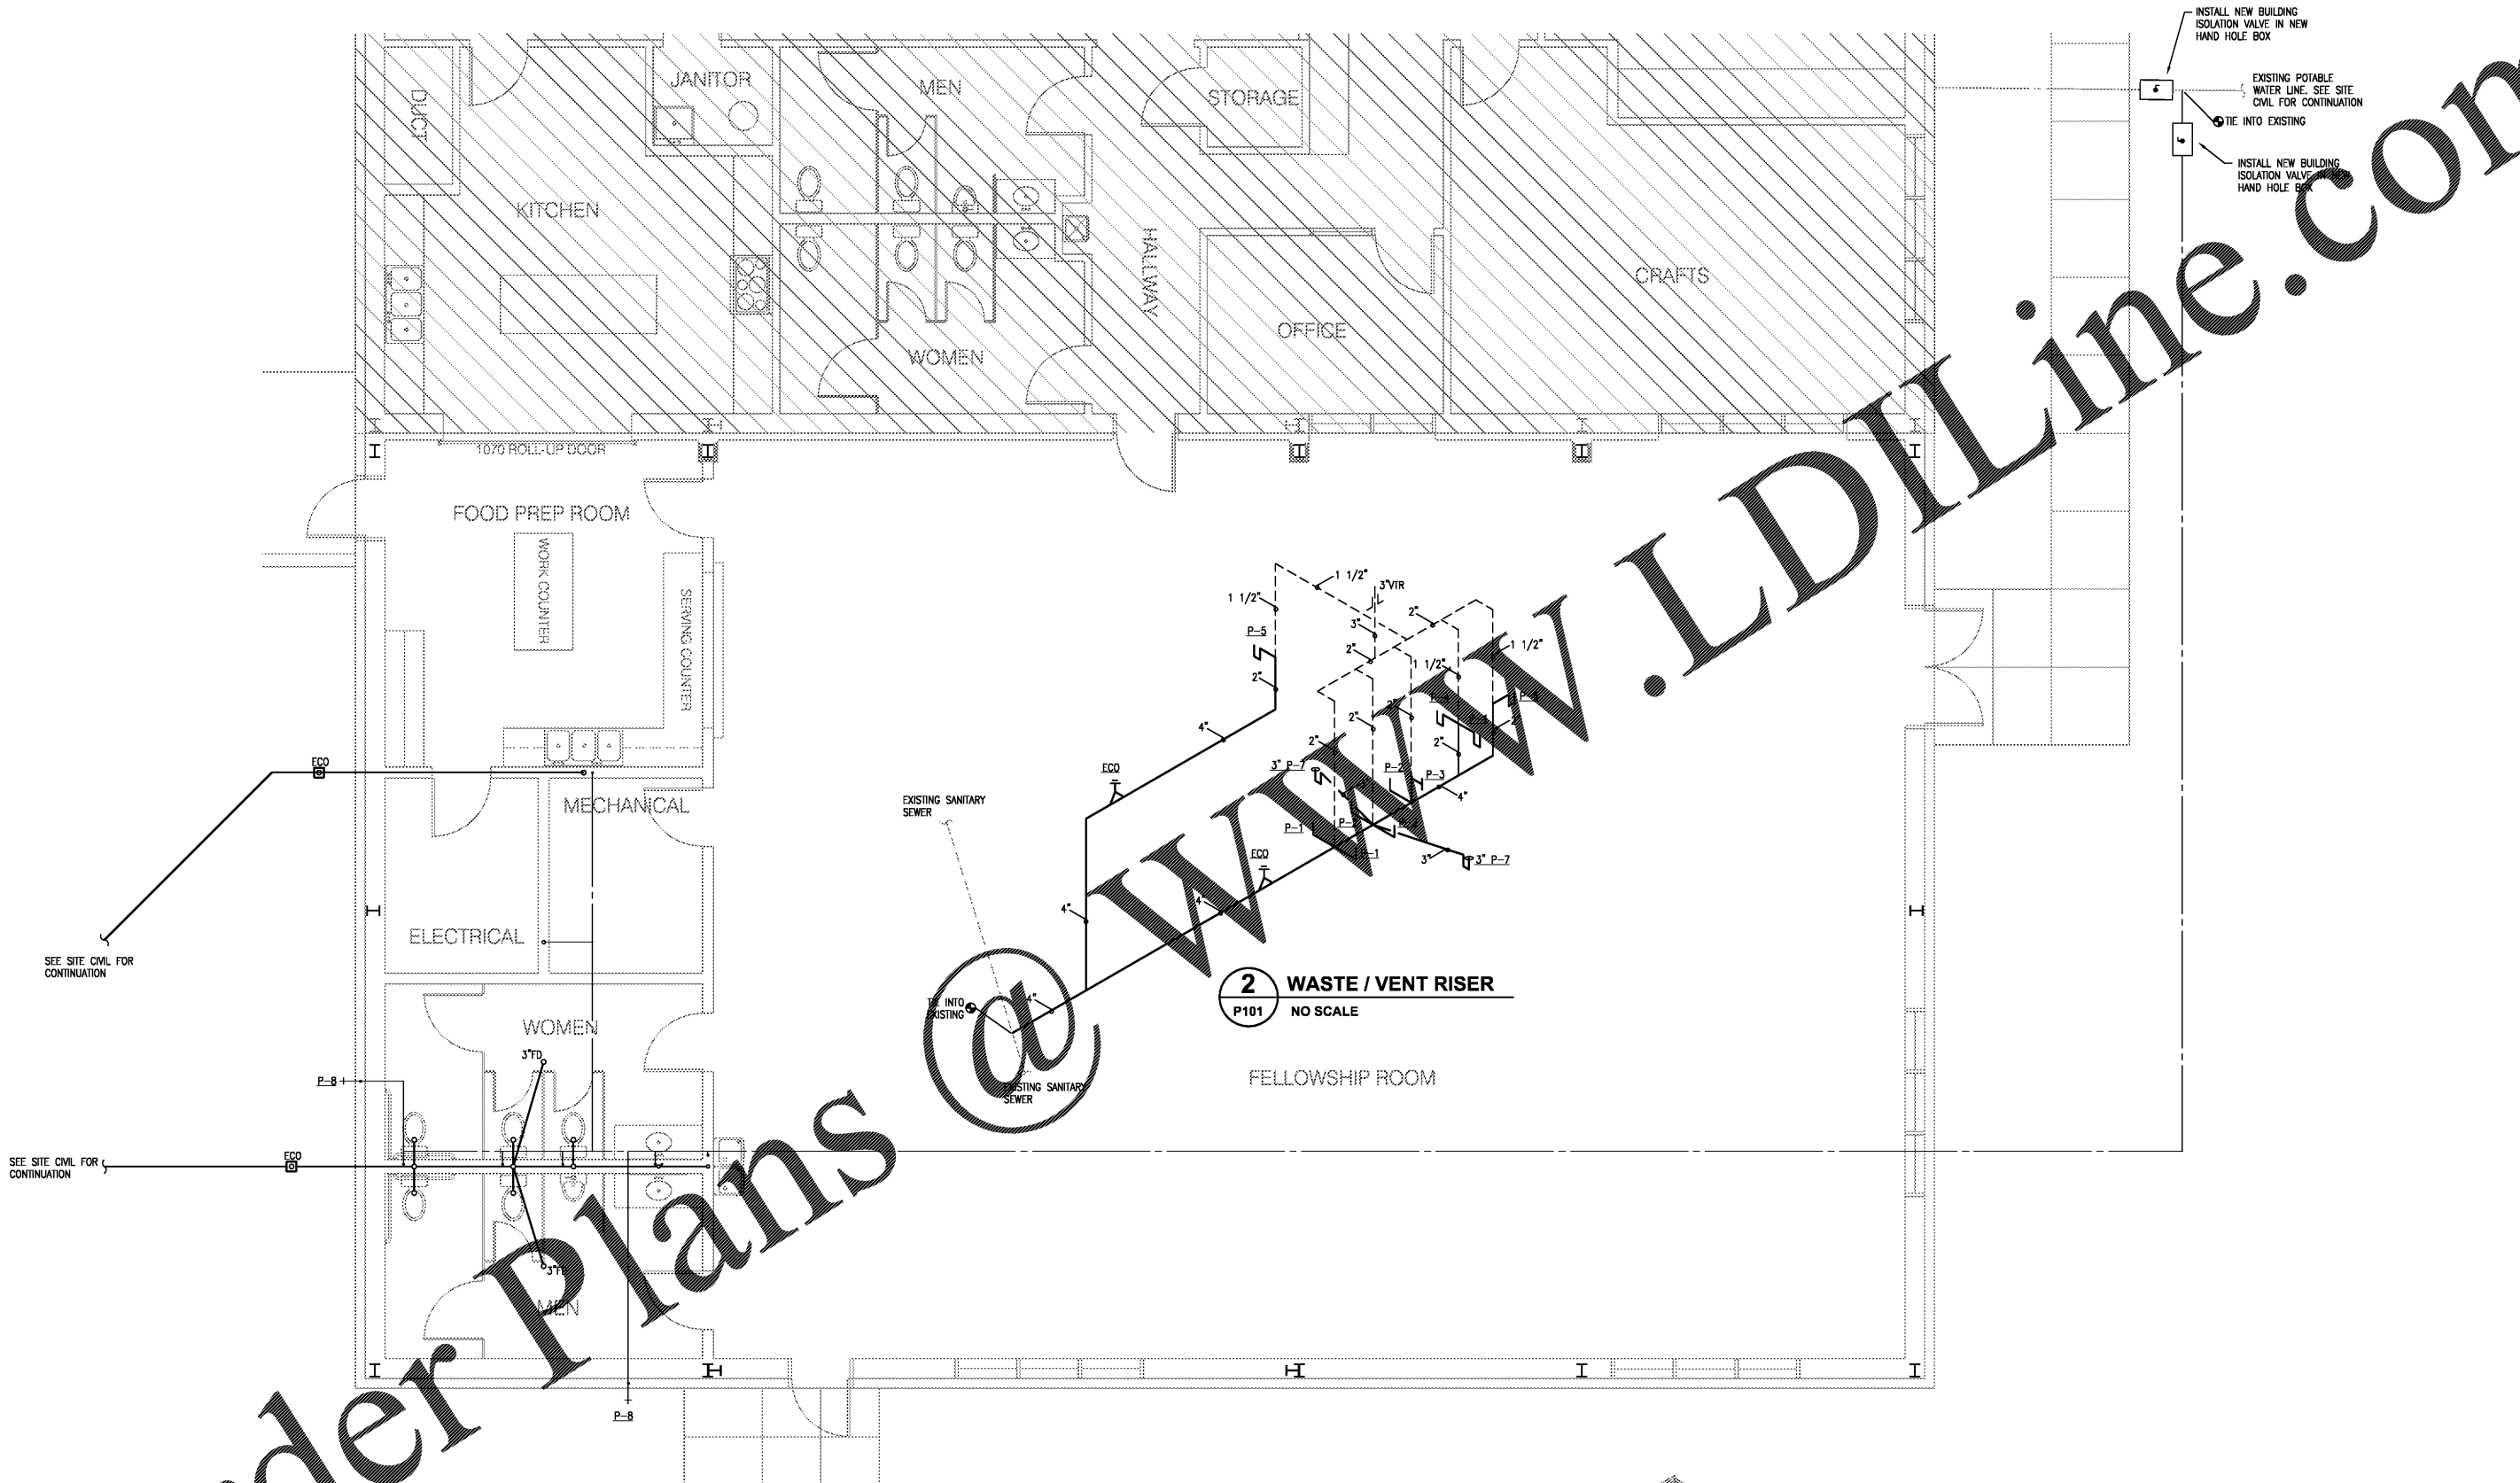


**1 UNDERGROUND PLUMBING PLAN**  
P101 1/4" = 1' - 0"



**2 WASTE / VENT RISER**  
P101 NO SCALE

**SENTINELL**  
CIVIL - STRUCTURAL - ENVIRONMENTAL - SURVEYING  
ENGINEERING

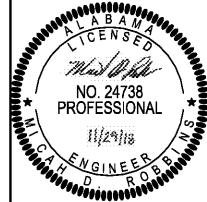

**BRIGHTON COMMUNITY CENTER**  
BLOCK 17 OF OAKDALE SURVEY, MAP BOOK 2, PAGE XX  
SECTION 27, TOWNSHIP 18 SOUTH, RANGE 4 WEST  
JEFFERSON COUNTY, ALABAMA

NO.	DATE:	DESCRIPTION:

UNDERGROUND PLUMBING PLAN  
DATE: 11-29-18  
JOB NO: 18-119  
SHEET: P101

VERIFY SCALES  
BUT IS ONE INCH  
ON ORIGINAL PLOT  
IF NOT ONE INCH  
ON THIS SHEET  
ADJUST SCALE  
ACCORDING

**ROBBINS**  
Engineering  
Company, LLC  
Mechanical & Electrical  
5945 Knight Ave, Suite B, Tuscaloosa, Alabama 35405  
Phone: (205) 391-7049  
http://www.ro-engineers.com

Permit Drawings REC Project 14092