



Order Plans @

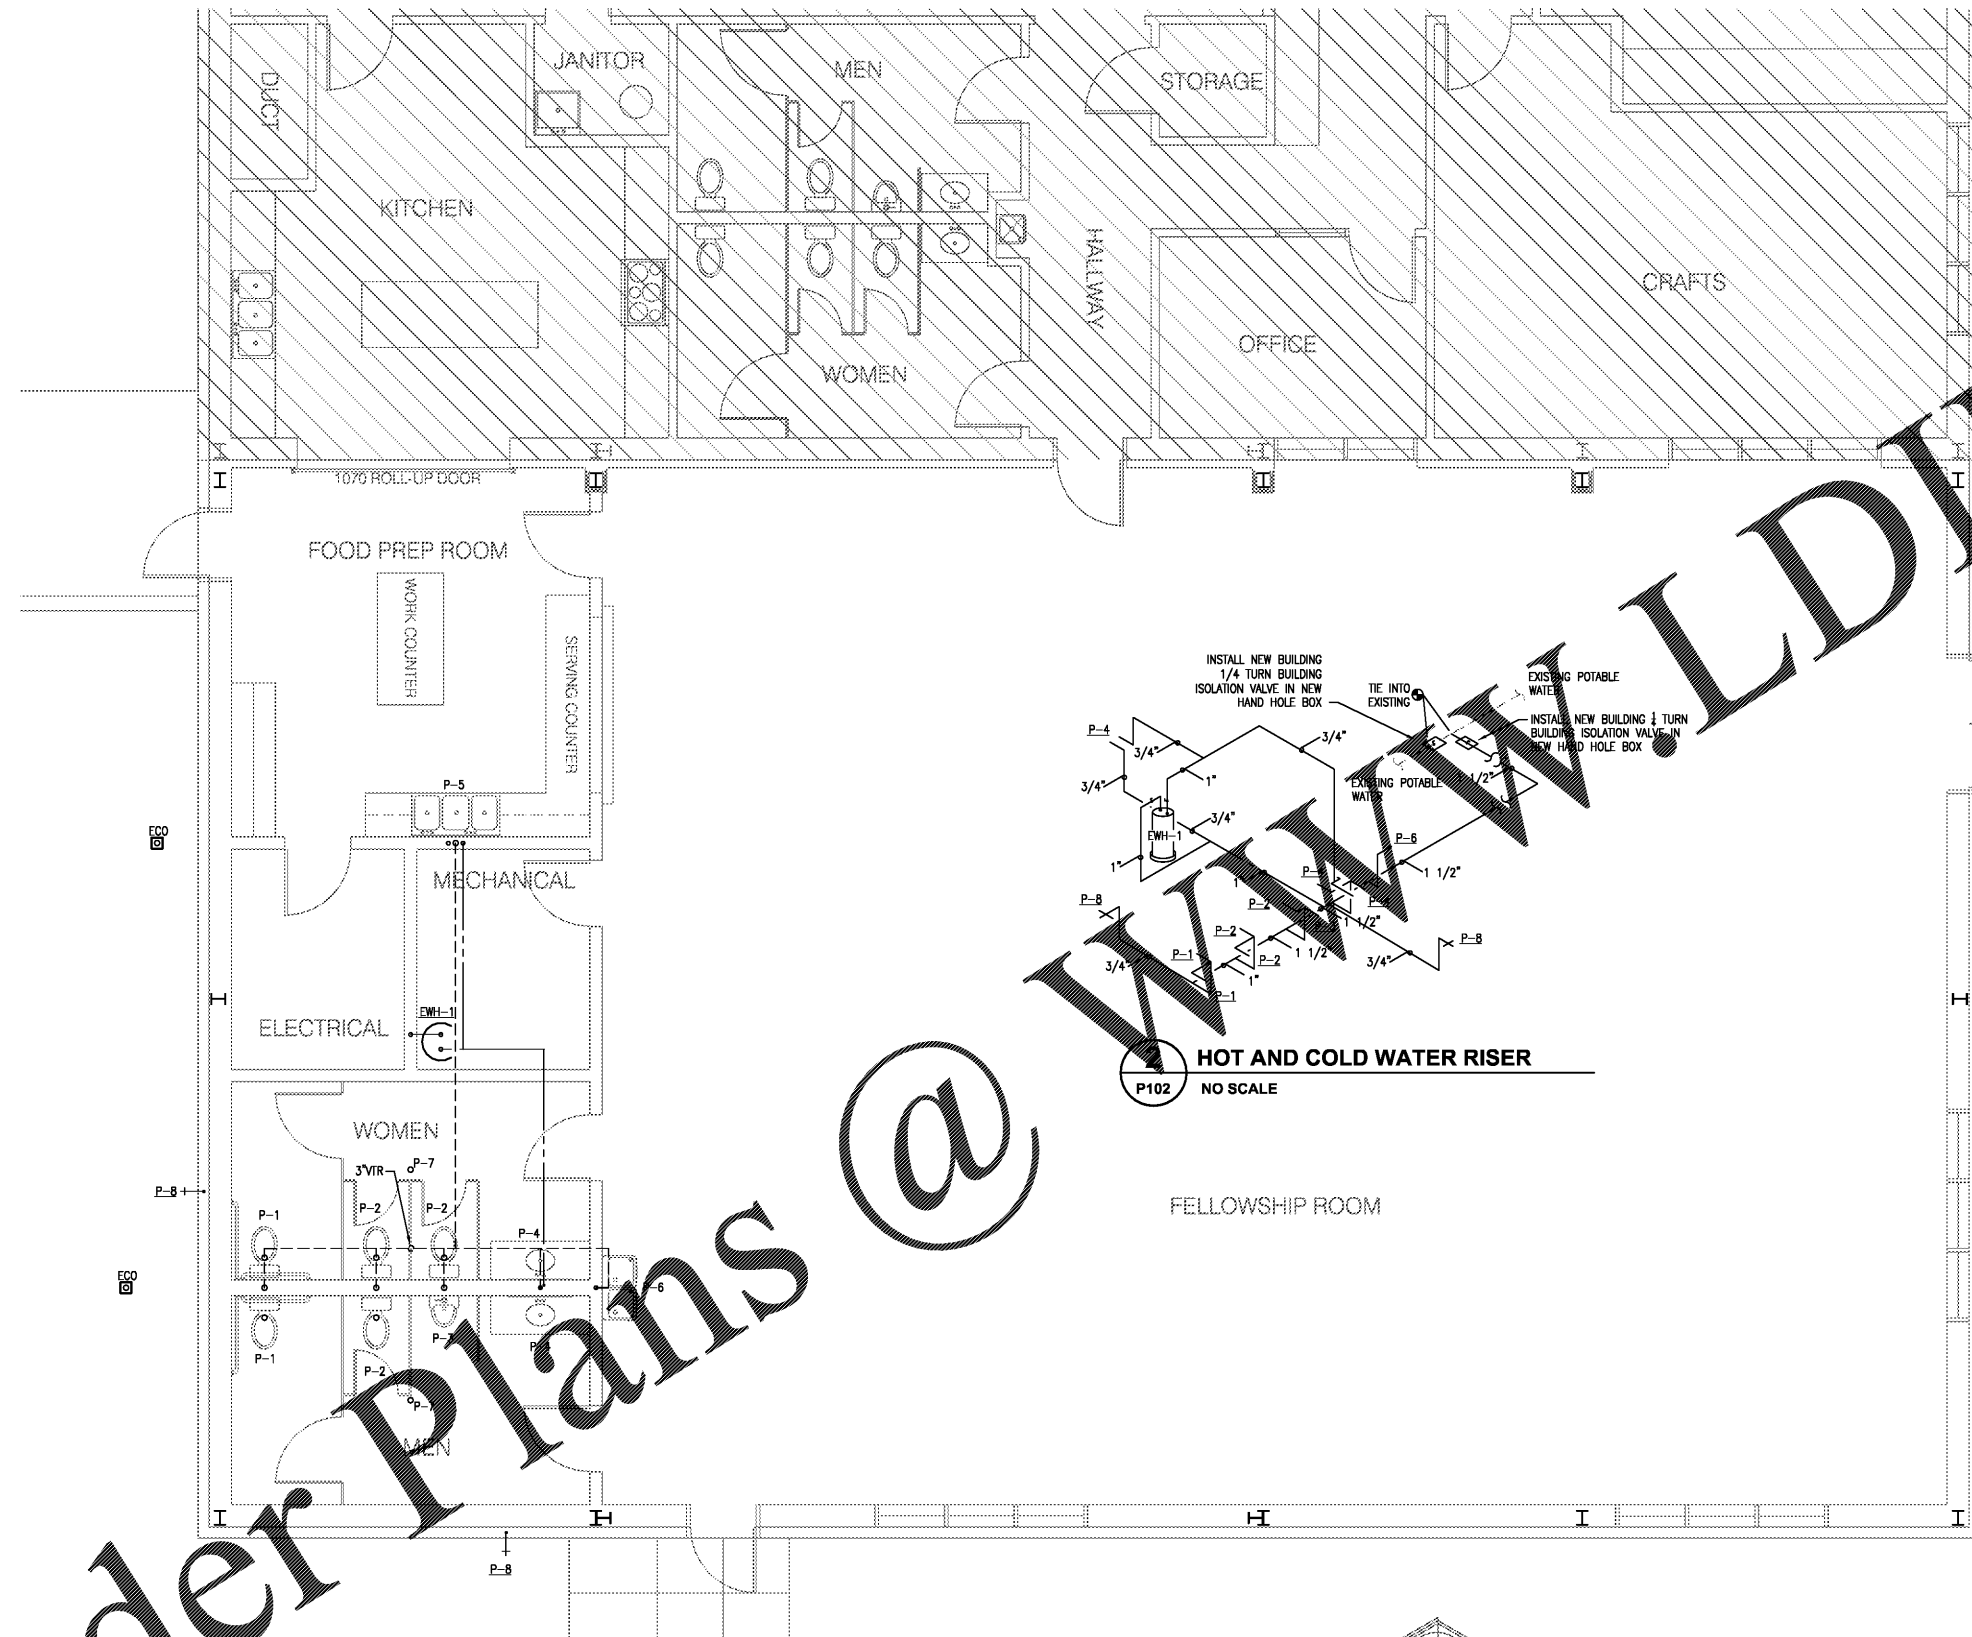

1 PLUMBING PLAN
P102 1/4" = 1' - 0"

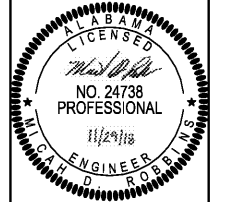

NO.	DATE	DESCRIPTION

PLUMBING PLAN
DATE: 11-29-18
JOB NO: 18-119
SHEET: P102

VERIFY SCALES
BUT IS ONE INCH
OF ORIGINAL, ETC.
IF NOT ONE INCH
ON THIS SHEET
ADJUST SCALE
ACCORDING

ROBBINS
Engineering
Company, LLC
Mechanical & Electrical
3945 Knight Ave, Suite B, Tuscaloosa, Alabama 35403
Phone: (205) 391-7049
http://www.ro-engineers.com
Permit Drawings REC Project 18092