



STORM SEWER STRUCTURES						
STRUCTURE NO.	TYPE	RIM/GRATE ELEV.	WEIR THROAT ELEV.	INV.(IN) ELEV.	INV.(OUT) ELEV.	REMARKS
A-0	FLARED END SECTION	286.79	285.00	285.00(N)		Reinforced Concrete
A-1	HOODED BACK TRAP	291.00	291.00	287.00(N)	286.51	Reinforced Concrete
A-2	GRATE INLET (TRAFFIC)	291.08	291.08	288.00(N) 288.00(W)	287.59	Reinforced Concrete
A-2.1	HOODED BACK TRAP	290.16	290.16		288.40	Reinforced Concrete
A-3	GRATE INLET (YARD)	293.82	293.82		289.86	Reinforced Concrete
B-0	FLARED END SECTION	286.79	285.17	285.00(E)		Reinforced Concrete
B-1	HOODED BACK TRAP	291.00	291.00	287.44(N)	287.24	Reinforced Concrete
B-2	HOODED BACK TRAP	293.82	293.82	288.73(N)	288.53	Reinforced Concrete
B-3	GRATE INLET (TRAFFIC)	293.75	293.75	289.56(N)	288.36	Reinforced Concrete
B-4	HOODED BACK TRAP	294.00	294.00	290.00		Reinforced Concrete
C-0	FLARED END SECTION	284.79	???	283.00		Reinforced Concrete
OCS-1	OUTLET CONTROL STRUCTURE	291.08	286.00		284.00	Reinforced Concrete

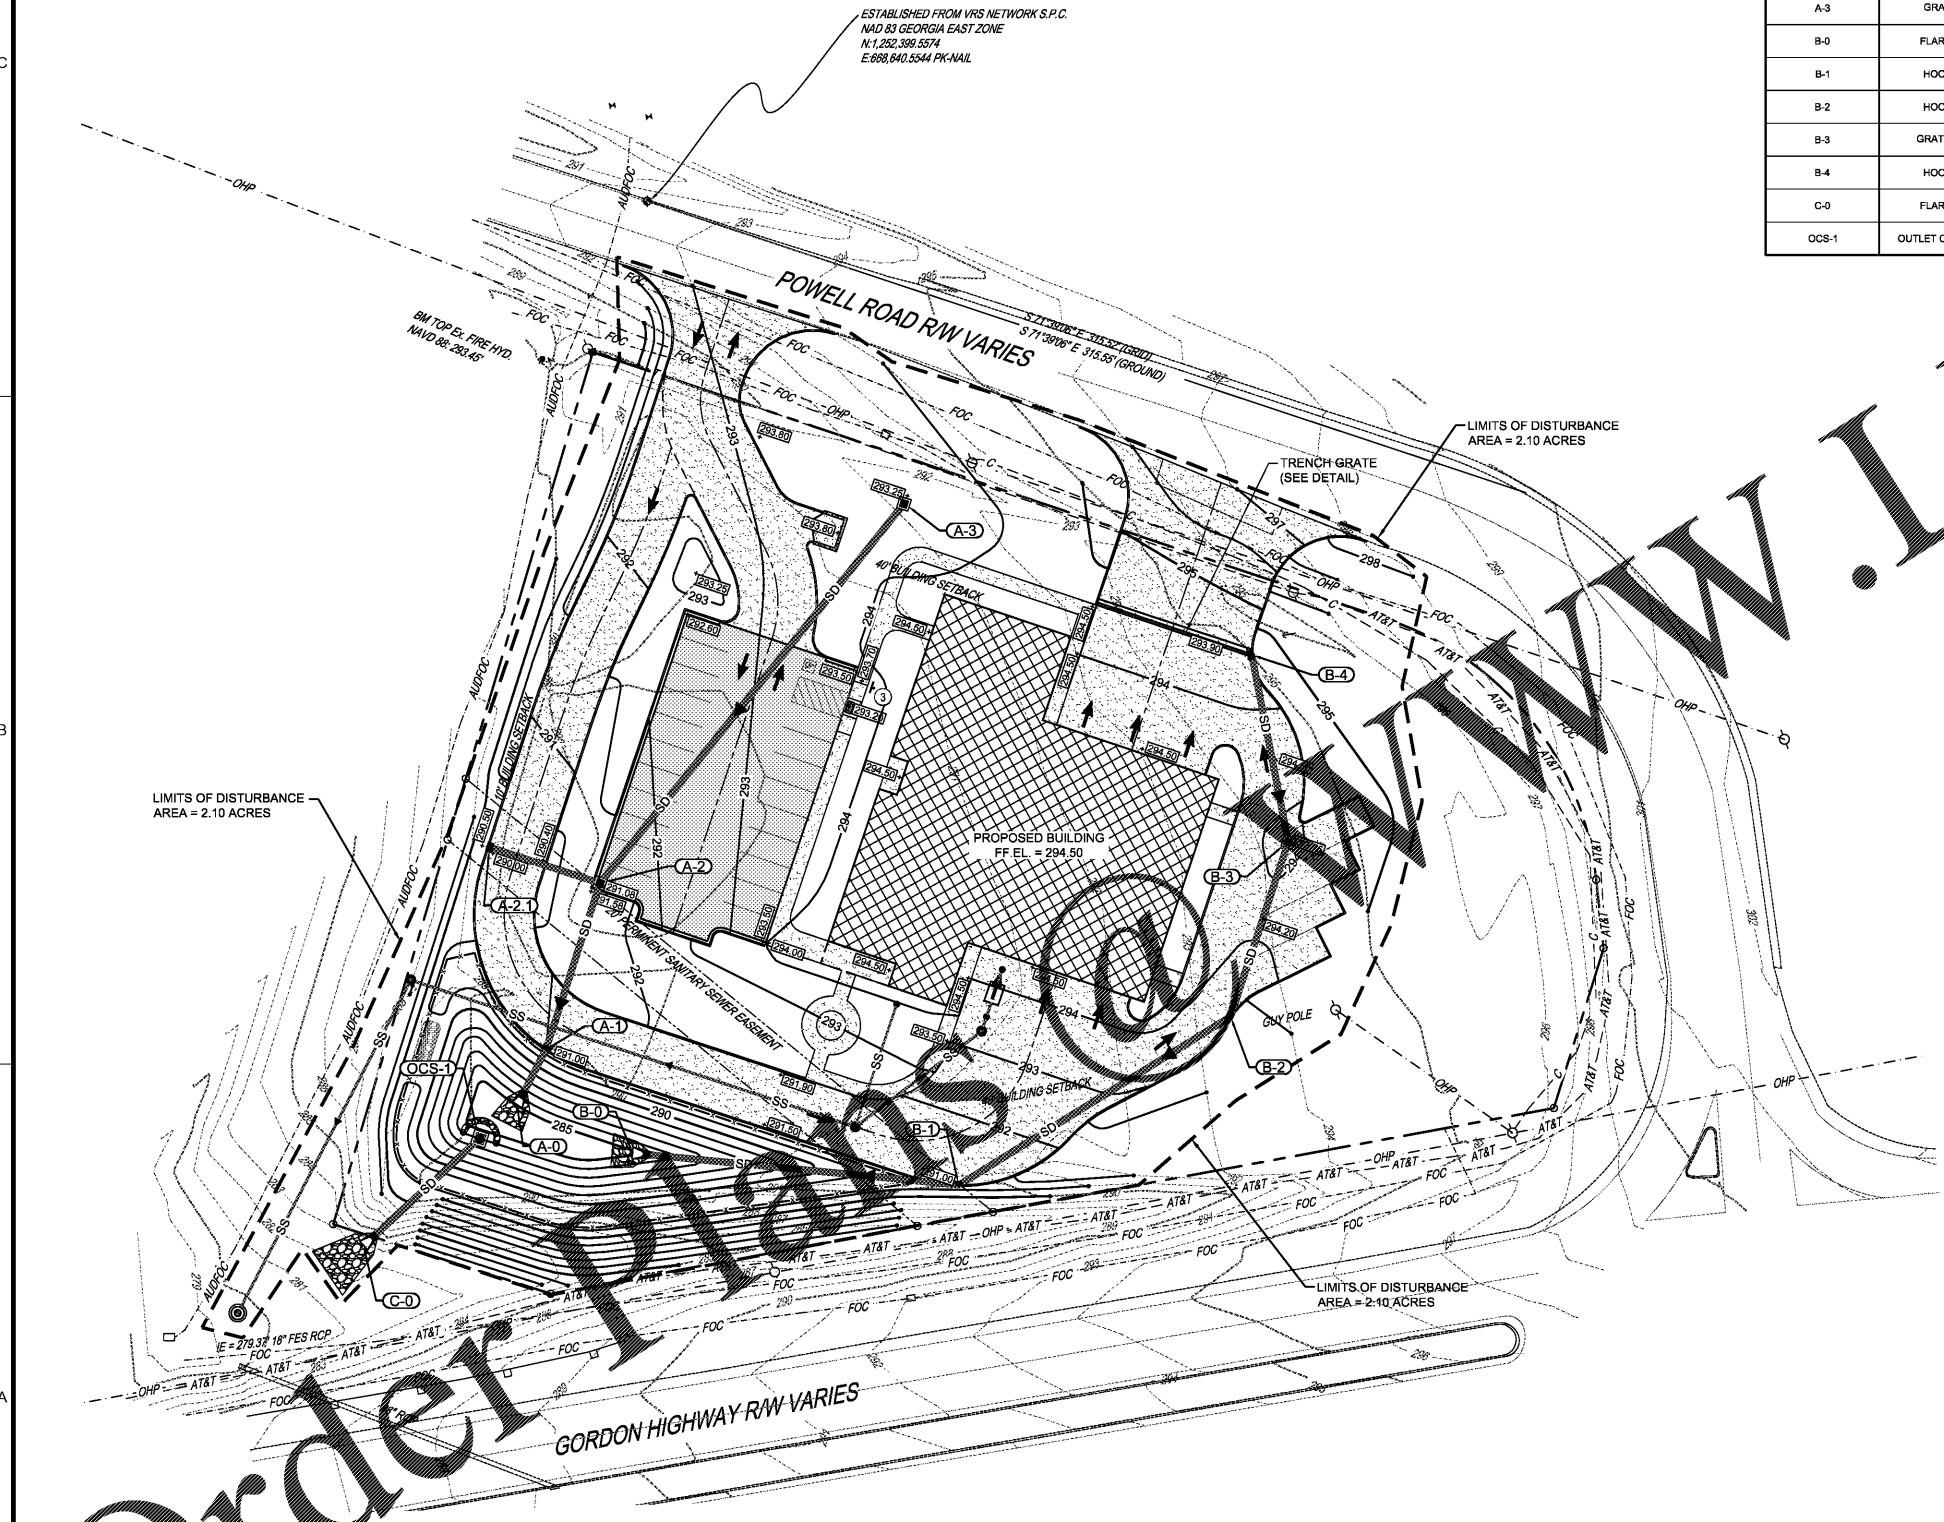

**UTILITY WARNING:**  
Underground utilities shown have been located from field survey and existing drawings. The engineer makes no guarantee that the underground utilities shown comprise all such utilities in the area. Utilities in service or abandoned. The engineer further does not warrant the location of underground utilities shown are in the exact location indicated although he does certify that they are located as accurately as possible from information available. The engineer has not physically located the underground utilities.

UTILITIES PROTECTION CENTER  
**GEORGIA811**  
 Utilities Protection Center, Inc.  
 Know what's below.  
 Call before you dig.  
 THREE WORKING DAYS BEFORE YOU DIG  
 (GEORGIA - 1-800-282-7411)

A1 GRADING AND DRAINAGE PLAN  
 C-201

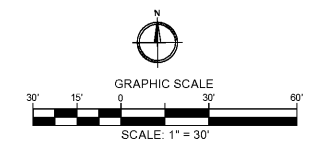

**JLA**  
 1980  
 Architects • Engineers • Landscape Architects  
**JOHNSON, LASCHOBER & ASSOCIATES, P.C.**  
 AUGUSTA, GA • MT. PLEASANT, SC  
 TEL: (706) 724-5756 • TEL: (843) 619-4656  
 FAX: (706) 724-3955  
 WWW.THEJLAGROUP.COM

CLIENT: AUGUSTA, GA  
 535 TELFAIR STREET, AUGUSTA, GA 30901  
 PROJECT NAME: **FIRE STATION #3**  
 PROJECT LOCATION: 2649 GORDON HWY., AUGUSTA, GA 30909

REV	DATE	BY	DESCRIPTION
0	12/27/18	WTB	ISSUED FOR BID

PROJECT NO. 3042.1604  
 DRAWN BY: DRWN  
 CHECKED BY: CHK  
 DATE: 10/18/17  
 SHEET TITLE:  
**GRADING AND DRAINAGE PLAN**  
 SCALE: 1" = 30'  
 DRAWING NO. **C-201** REV. 0

This document is the property of Johnson, Laschobar & Associates, P.C. The unauthorized reproduction, copying or otherwise use of this document is strictly prohibited and any infringement thereupon may be subject to legal action.