



CEILING LEGEND

	ACOUSTICAL CEILING TILE 2X2 LAY-IN CEILING PANEL WITH SUSPENDED GRID		CEILING CAP/ SOUND BARRIER INSULATION PLATE ABOVE CEILING (2'-0" FROM PERIMETER WALLS)
	HARD CEILING ETR- PAINTED (GYP) GYPSUM BOARD PAINTED		SURFACE MOUNT/ LAY- IN FIXTURE 1 X 4 LIGHT FIXTURE
	EXPOSED STRUCTURE PAINTED		LAY- IN FIXTURE 2 X 4 LIGHT FIXTURE
	EXIT LIGHT		LAY- IN FIXTURE 2 X 2 LIGHT FIXTURE
	HVAC RETURN SEE HVAC DWGS.		DOWN LIGHT
	HVAC DIFFUSER SEE HVAC DWGS.		EMERGENCY FIXTURE


NOTES:
1. SEE ELECTRICAL AND MECHANICAL DRAWINGS FOR ALL RELATED ITEMS.
2. SEE ELECTRICAL DRAWINGS FOR FIXTURE SCHEDULE.

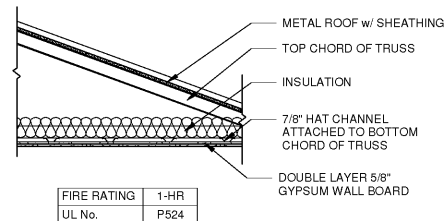


2
A-201
1-HR CEILING ASSEMBLY
SCALE: 1/2" = 1'-0"

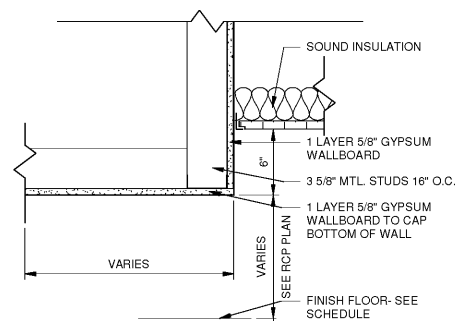

3
A-201
BULKHEAD DETAIL
SCALE: 1 1/2" = 1'-0"

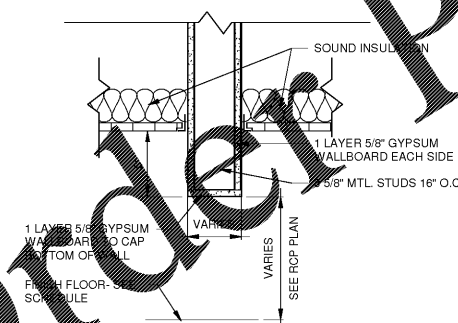


4
A-201
BULKHEAD DETAIL 2
SCALE: 1 1/2" = 1'-0"

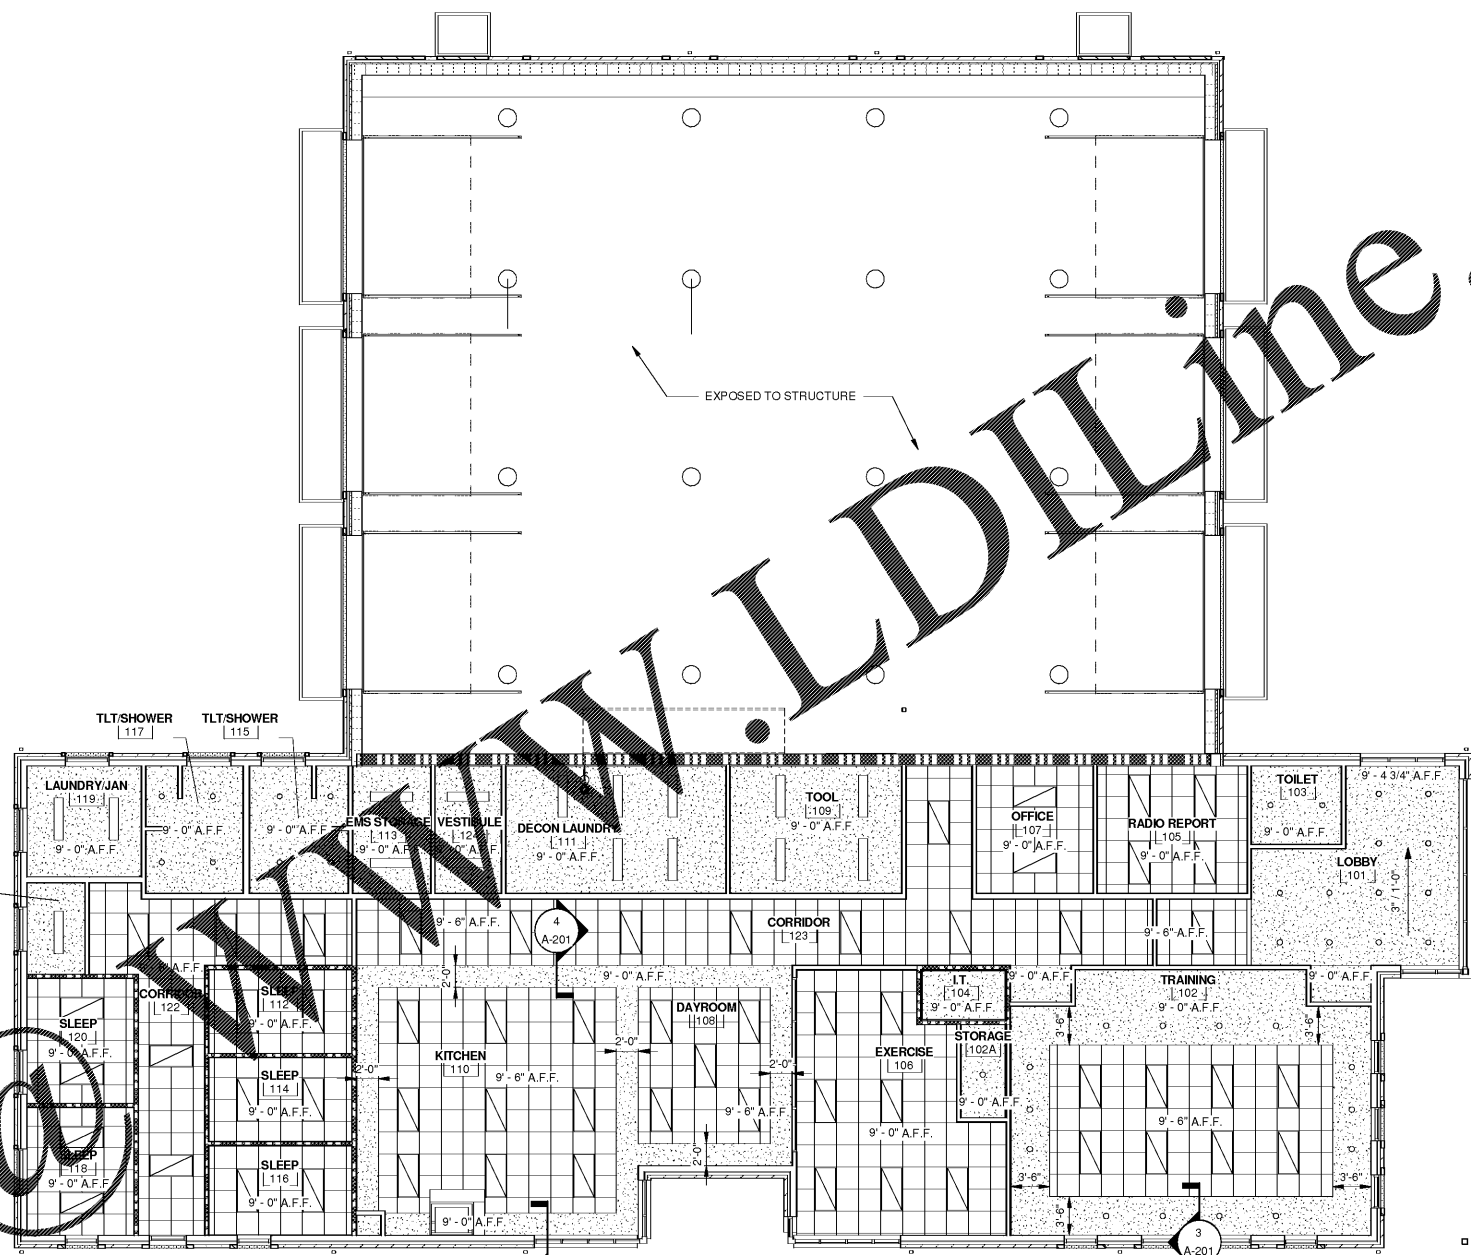


NOTE:
ALL SLEEP ROOMS (112, 114, 116, 118, 120) TO HAVE A 1-HR RATED CEILING

1
A-201
REFLECTED CEILING PLAN
SCALE: 1/8" = 1'-0"

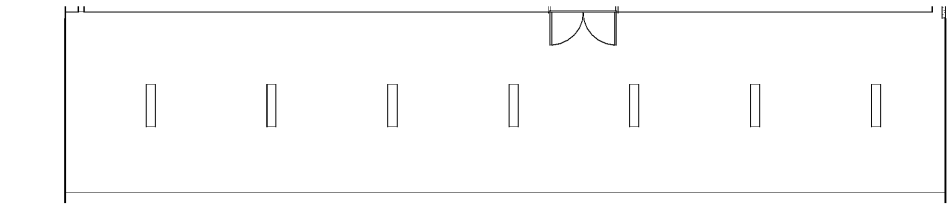

5
A-201
MEZZANINE PLAN
SCALE: 1/8" = 1'-0"

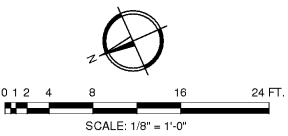

1980
Architects • Engineers • Planners • Architects
JOHNSON, LASCOBOR & ASSOCIATES, P.C.
100 W. GA. • MT. PLEASANT, SC
TEL: (706) 724-5756 • TEL: (843) 619-4656
FAX: (706) 724-3935
WWW.THEJLAGROUP.COM

CLIENT: AUGUSTA, GA
535 TELFAIR STREET, AUGUSTA, GA 30901

PROJECT NAME: **FIRE STATION #3**

PROJECT LOCATION: 2649 GORDON HWY., AUGUSTA, GA 30909

NO.	DATE	BY	ISSUED FOR	DESCRIPTION
0	12/21/18	JAP	ISSUED FOR BID	

PROJECT NO.	3042.1604
DRAWN BY:	JAP
CHECKED BY:	WLD
DATE:	8/10/18
SHEET TITLE:	REFLECTED CEILING PLAN

SCALE	AS NOTED
DRAWING NO.	A-201
REV.	0

Order Plans