


1


2

3


4

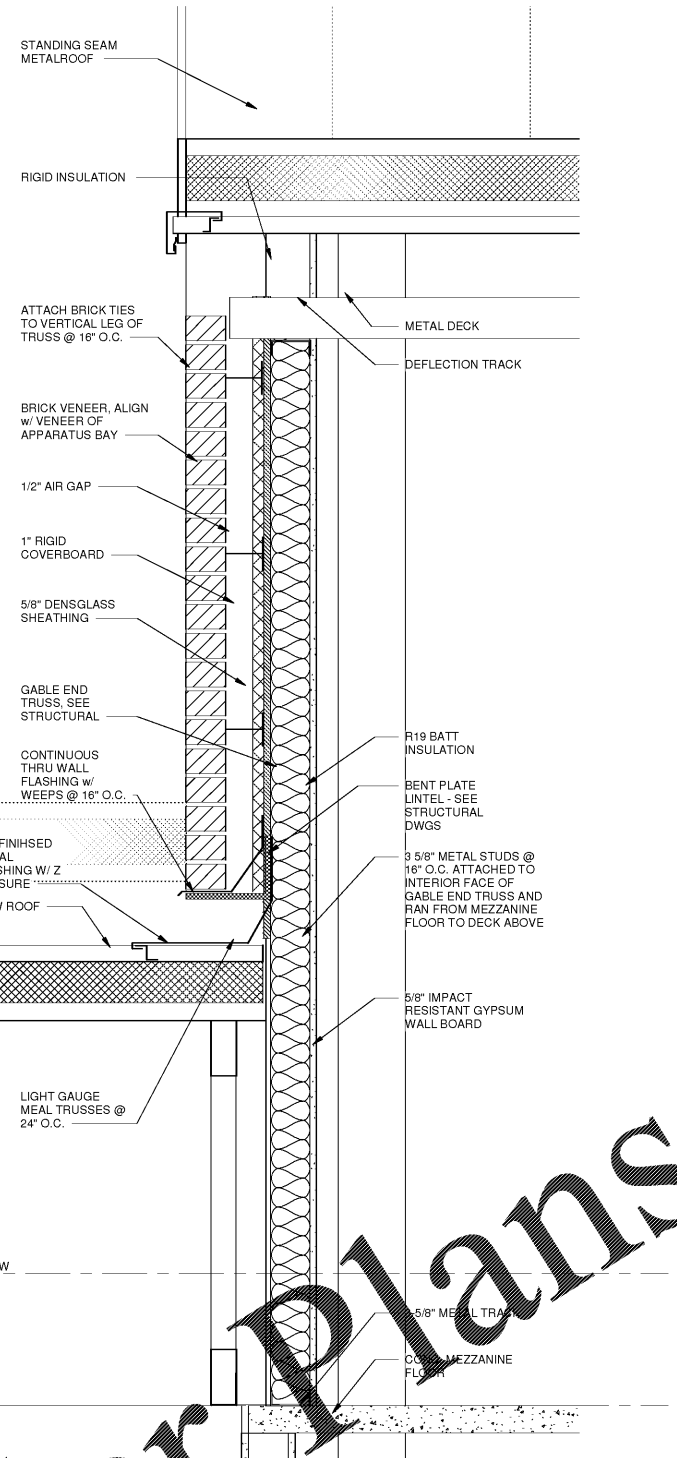


1 SECTION
A-602 SCALE: 1/4" = 1'-0"

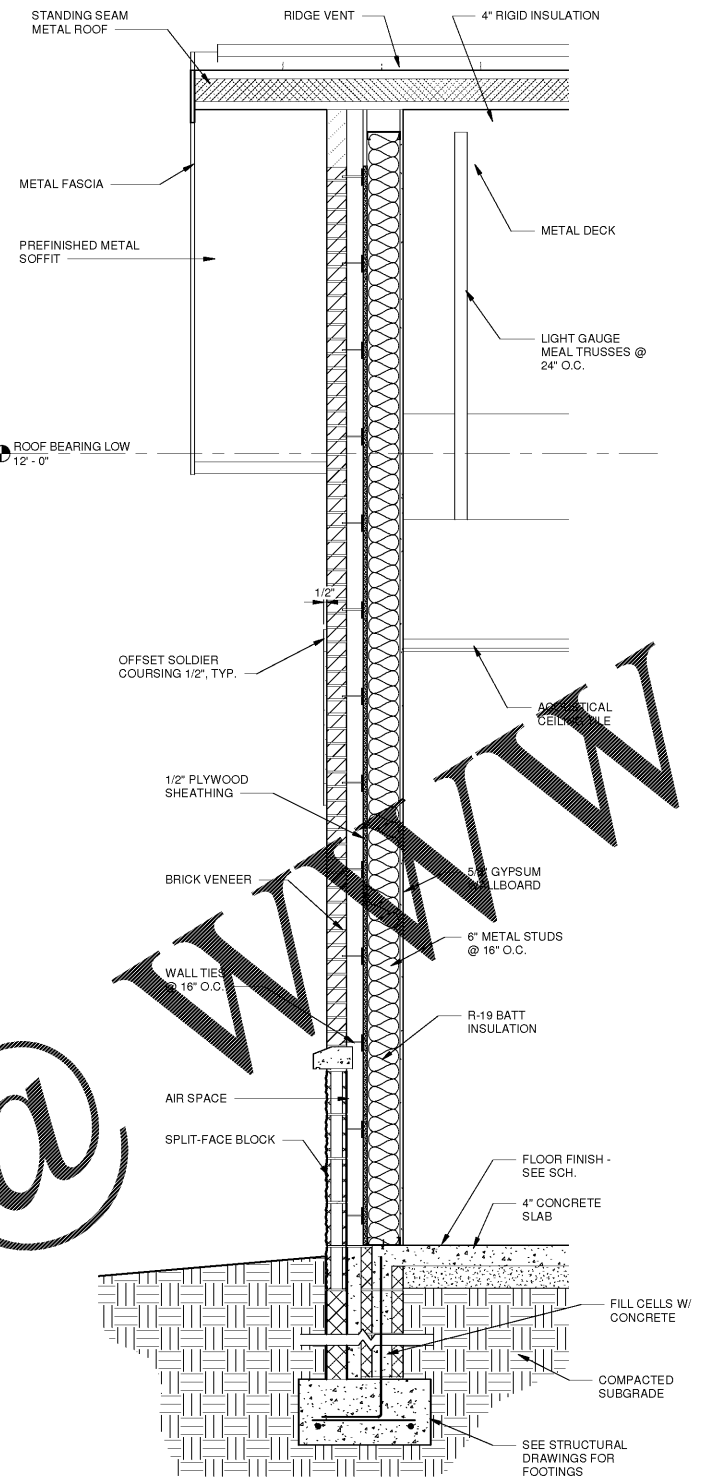

2 SECTION
A-602 SCALE: 3/4" = 1'-0"

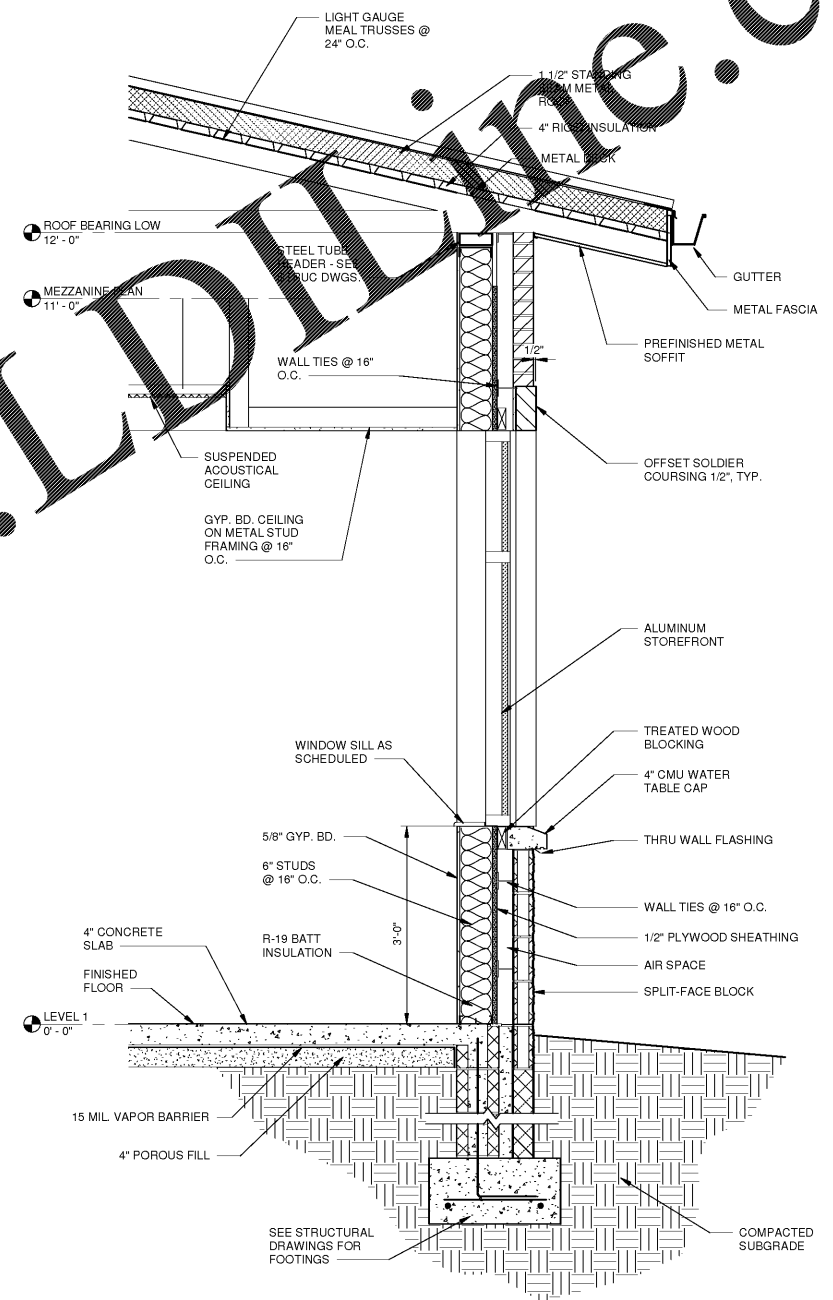

3 SECTION
A-602 SCALE: 3/4" = 1'-0"

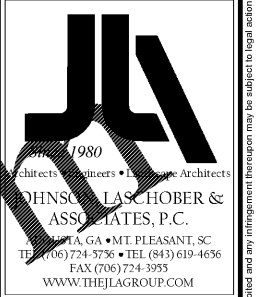

CLIENT: AUGUSTA, GA
535 TELFAIR STREET, AUGUSTA, GA 30901
PROJECT NAME: FIRE STATION #3
PROJECT LOCATION: 2849 GORDON HWY., AUGUSTA, GA 30909

REV	DATE	BY	DESCRIPTION
0	12/21/18		ISSUED FOR BID

PROJECT NO. 3042.1604
DRAWN BY: CBW/CTH
CHECKED BY: WLD
DATE: 8/10/18
SHEET TITLE: WALL SECTIONS & DETAILS
SCALE: AS NOTED
DRAWING NO. A-602
REV. 0

Order Plans @

WWW.LDLINE.COM

This document is the property of Johnson, Lashcober & Associates, P.C. The unauthorized reproduction, copying or otherwise use of this document is strictly prohibited and any infringement thereupon may be subject to legal action.