


- CONSTRUCTION NOTES:
- ① 6"Ø INCOMING FIRE PROTECTION SERVICE BFP, FDC, AND PIV LOCATED OUTSIDE BUILDING. SEE CIVIL DRAWINGS FOR CONTINUATION.
 - ② 6"Ø SERVICE ENTRANCE, 4"Ø RISER (SEE FIRE SPRINKLER RISER SCHEMATIC 1/F-001)


1980
Architects • Engineers • Landscape Architects
JOHNSON, LASCOBER & ASSOCIATES, P.C.
ATLANTA, GA • MT. PLEASANT, SC
TEL: (706) 724-5756 • TEL: (843) 619-4656
FAX: (706) 724-3935
WWW.THEJLAGROUP.COM

SEE CIVIL PLANS FOR CONTINUATION

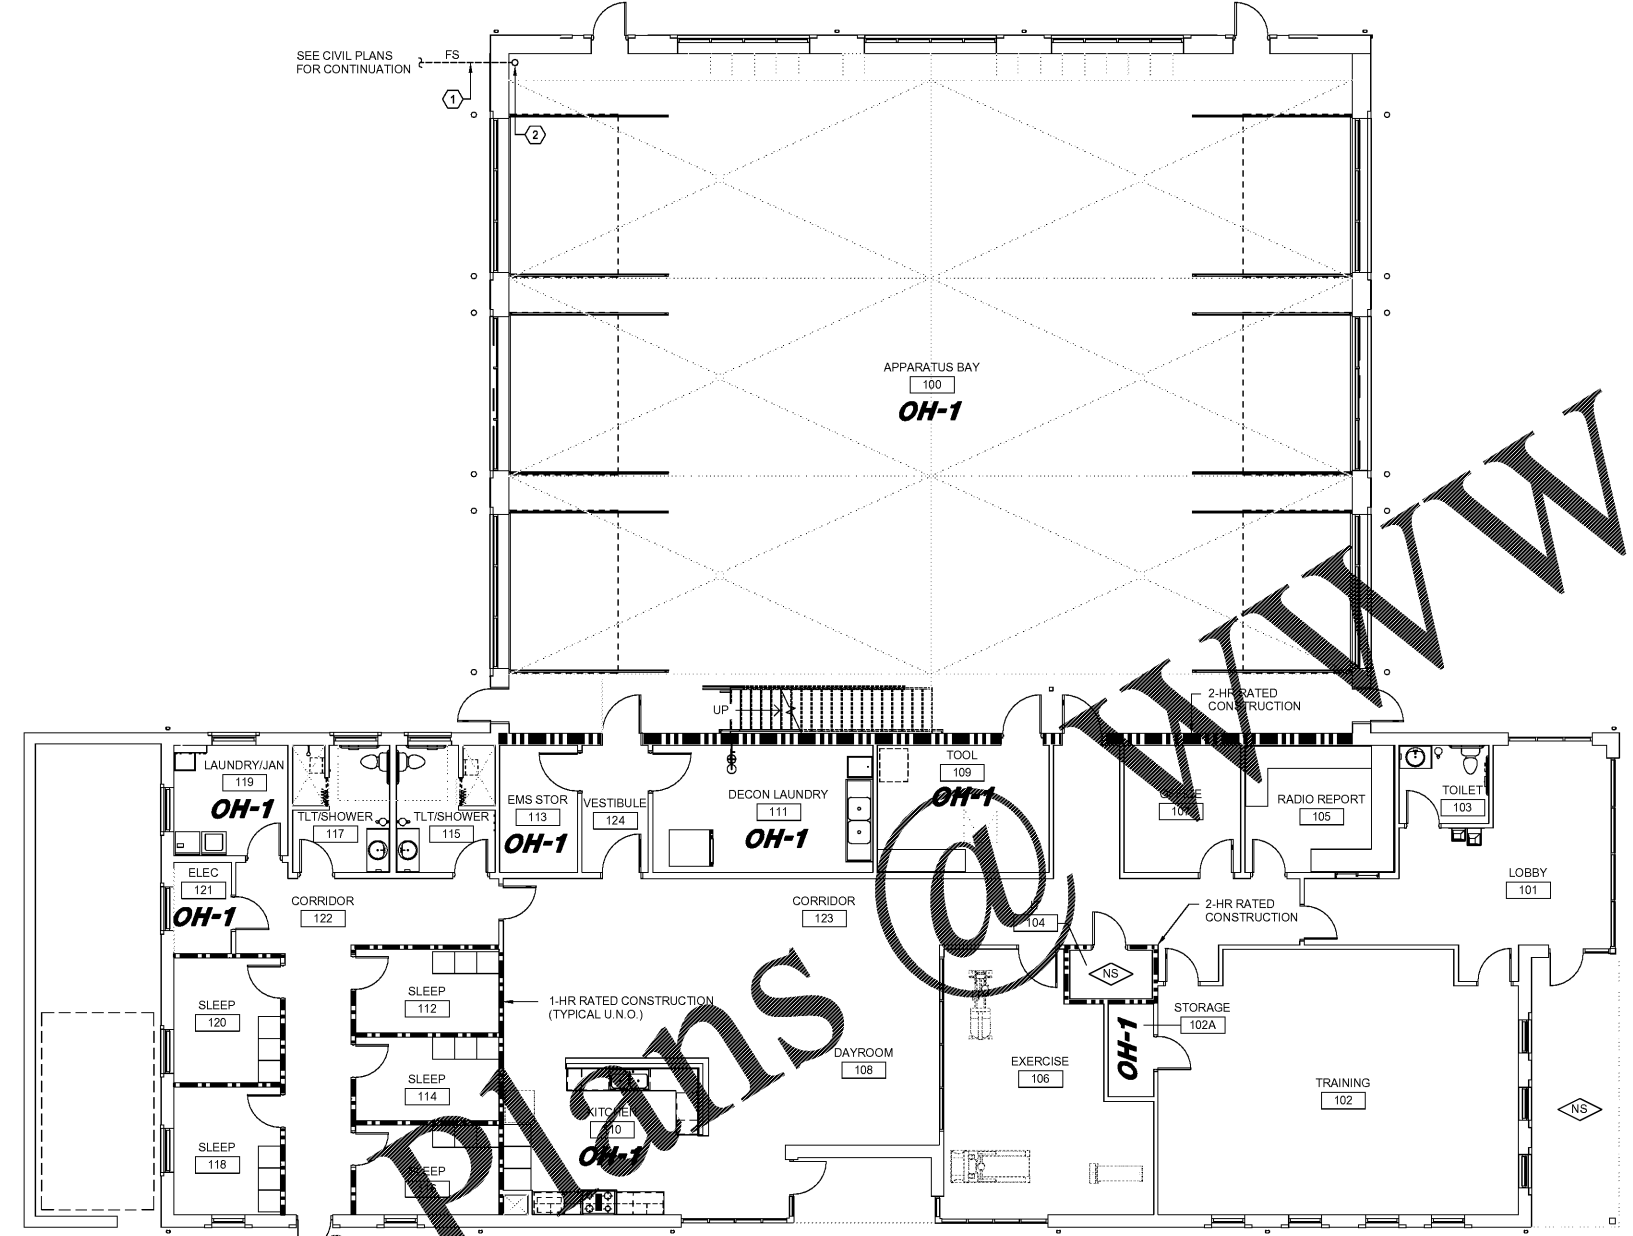

NOTE:
ALL AREAS SHALL BE CONSIDERED LIGHT HAZARD UNLESS NOTED OTHERWISE.

① FIRE PROTECTION PLAN
F-101
SCALE: 1/8" = 1'-0"

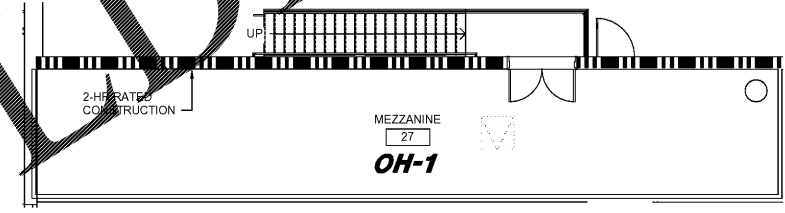

② MEZZANINE FIRE PROTECTION PLAN
F-101
SCALE: 1/8" = 1'-0"

CLIENT: AUGUSTA, GA
535 TELFAIR STREET, AUGUSTA, GA 30901

PROJECT NAME:

FIRE STATION #3

PROJECT LOCATION:
2649 GORDON HWY., AUGUSTA, GA 30909

REV	DATE	BY	DESCRIPTION
0	12/27/18	CVW	ISSUED FOR BID

PROJECT NO. 3042.1604
DRAWN BY: WBR
CHECKED BY: CVW
DATE: 10/18/17

SHEET TITLE:
FIRE PROTECTION PLANS

SCALE: AS NOTED

DRAWING NO. **F-101** REV. 0

Order Plans @ www.LDILine.com