

LIGHTING PLAN CONSTRUCTION NOTES:

- 1. OCCUPANCY SENSOR SWITCHES IN SLEEPING ROOMS SHALL BE PLACED IN VACANCY MODE.
- 2. PROVIDE PHOTOCELL AND TIMECLOCK FOR CONTROL OF EXTERIOR FIXTURES.

LIGHTING PLAN KEYED NOTES:

- ① #10 AWG ENTIRE CIRCUIT. PROVIDE PHOTOCELL AND TIME CLOCK TO CONTROL TYPES J, K, AND M ON THIS CIRCUIT.
- ② PARALLEL OCCUPANCY SENSORS IN THIS ROOM.
- ③ CONTINUE CIRCUIT TO MEZZANINE LIGHTING.
- ④ PROVIDE EMERGENCY BACKUP INVERTER DUAL-LITE LED OR APPROVED EQUAL. LOCATE ON MEZZANINE. COORDINATE LOCATION WITH OWNER.

1980
Architects • Engineers • Interiors Architects
JOHNSON, LASCHOBER &
ASSOCIATES, P.C.
1000 W. GATEWAY BLVD., SUITE 100 • MT. PLEASANT, SC 29566
TEL: (803) 724-5756 • TEL: (843) 619-4656
FAX: (803) 724-3935
WWW.THEJLAGROUP.COM

CLIENT: AUGUSTA, GA
535 TELFAIR STREET, AUGUSTA, GA 30601

PROJECT NAME:

FIRE STATION #3

PROJECT LOCATION:
2649 GORDON HWY., AUGUSTA, GA 30609

REV	DATE	BY	DESCRIPTION
0	12/21/18	FAK	ISSUED FOR BID


PROJECT NO. 3042.1604
DRAWN BY: JAP/JFP
CHECKED BY: FAK
DATE: 10/18/17

SHEET TITLE: LIGHTING PLAN


SCALE: AS NOTED

DRAWING NO. **E-101** REV. **0**


This document is the property of Johnson, Laschober & Associates, P.C. The unauthorized reproduction, copying or otherwise use of this document is strictly prohibited and any infringement thereupon may be subject to legal action.

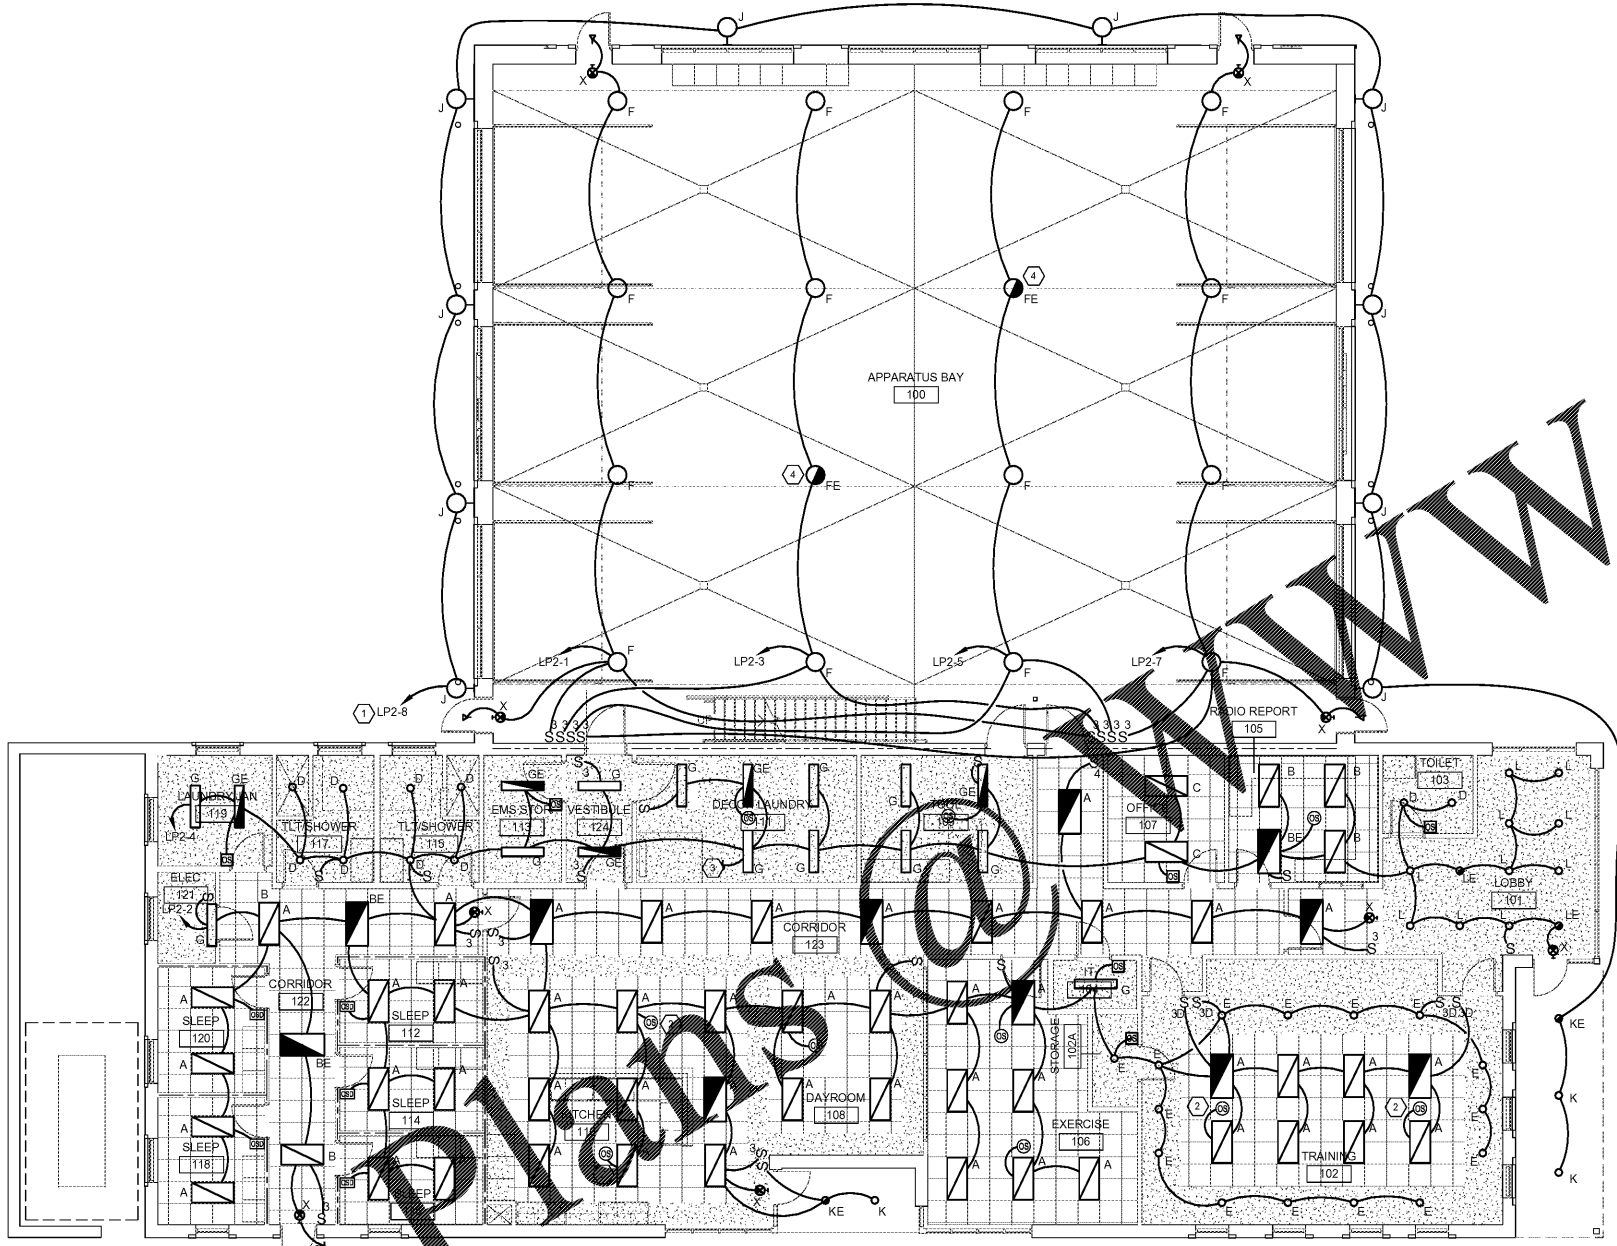

① LIGHTING PLAN
E-101 SCALE: 1/8" = 1'-0"

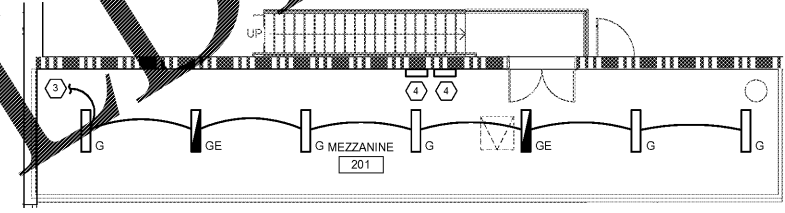

② MEZZANINE LIGHTING PLAN
E-101 SCALE: 1/8" = 1'-0"

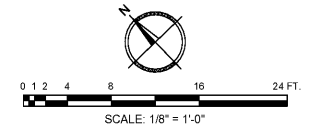

Order Plans