

LIGHTING FIXTURE SCHEDULE

Table with columns: ID, BASIS OF DESIGN (MANUF., MODEL NUMBER), VOLT., WATTS, LAMP TYPE, MOUNTING, REMARKS. Includes items A through Y with various lighting fixture specifications.

LIGHTING FIXTURE SCHEDULE NOTES: COORDINATE ALL FINISH OPTIONS WITH ARCHITECT.

SPECIAL OUTLET SCHEDULE


Table with columns: ID, VOLTAGE, PHASE, WIRE / COND., DESCRIPTION. Lists special outlets for equipment like extractors, dryers, and kitchen hoods.

SPECIAL OUTLET SCHEDULE NOTES: PROVIDE LOCAL DISCONNECTING FOR DEVICES WITHOUT RECEPTACLE. COORDINATE WITH MOCIP.


MOTOR SCHEDULE

Table with columns: ID, VOLTAGE, PHASE, WIRE / COND., DESCRIPTION. Lists various motors for AHU units, OHP units, and bay doors.


MOTOR SCHEDULE NOTES: PROVIDE LOCAL FUSIBLE DISCONNECTING MEANS FOR EACH MOTOR. COORDINATE WITH MOTOR MOCIP.

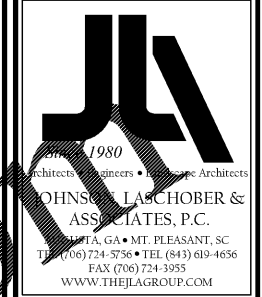


JOHNSON, LASCHOB & ASSOCIATES, P.C. AUGUSTA, GA 30601. PROJECT NAME: FIRE STATION #3. PROJECT LOCATION: 2649 GORDON HWY., AUGUSTA, GA 30609.

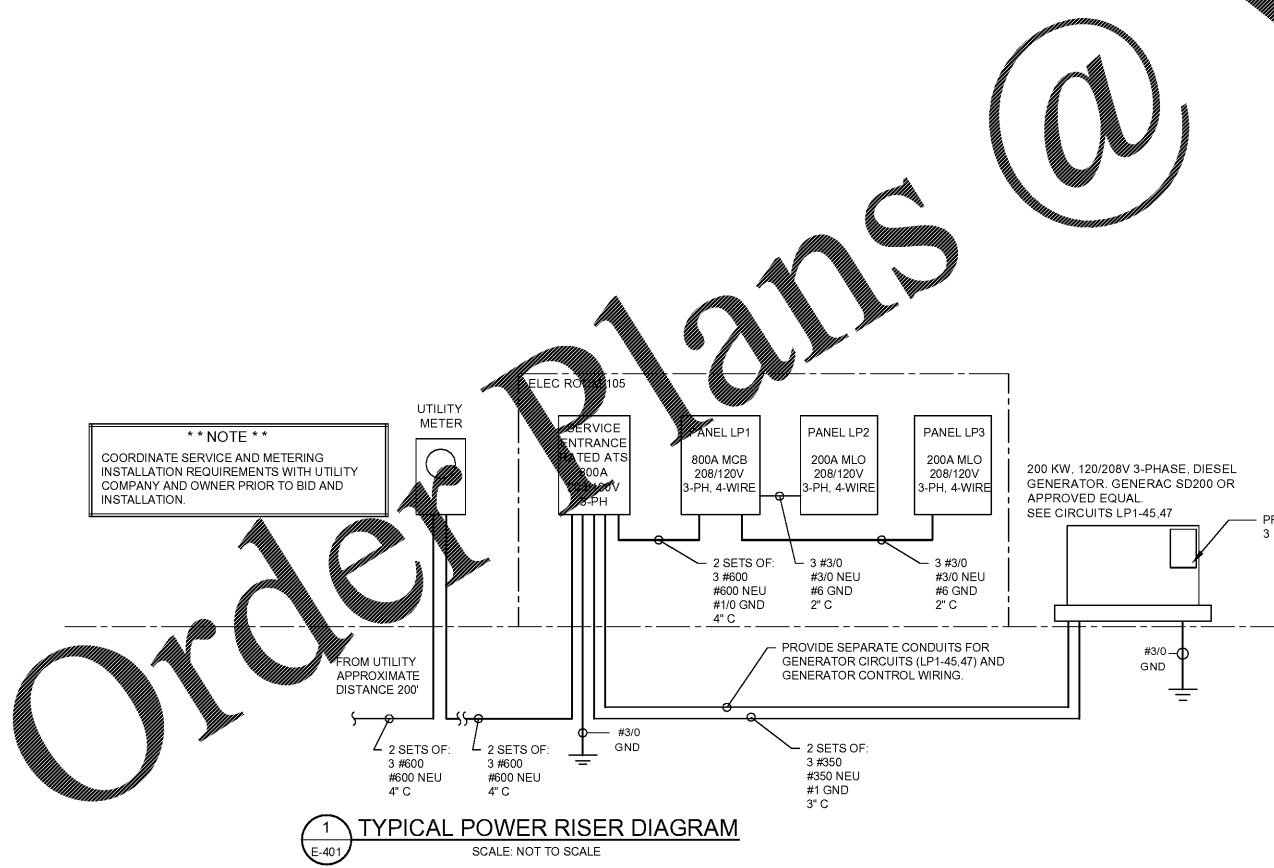

1 TYPICAL POWER RISER DIAGRAM SCALE: NOT TO SCALE

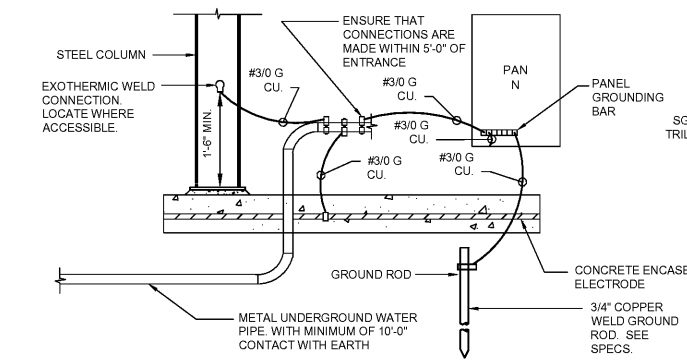

2 ELECTRODE GROUNDING DETAIL SCALE: NOT TO SCALE

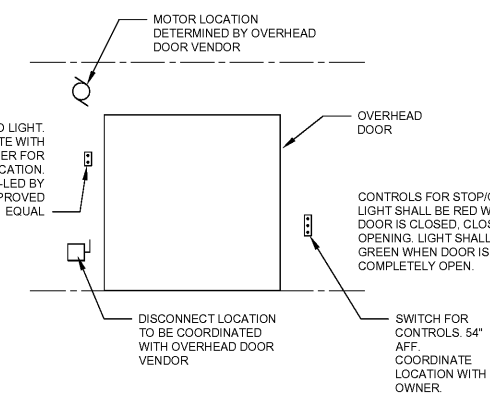

3 OVERHEAD DOOR DETAIL EQUIPMENT LOCATIONS SCALE: NONE

Table with columns: REV, DATE, BY, DESCRIPTION. Revision table for the drawing.

PROJECT NO. 3042.1604. DRAWN BY: JAP/JFP. CHECKED BY: FAK. DATE: 10/18/17. SHEET TITLE: ELECTRICAL SCHEDULES AND DETAILS. SCALE: AS NOTED. DRAWING NO. E-401. REV. 0.

WWW.LDLINE.COM

Order Plans @

Vertical text on the left margin: 11/15/2017

Vertical text on the right margin: This document is the property of Johnson, Laschober & Associates, P.C. The unauthorized reproduction, copying or otherwise use of this document is strictly prohibited and any infringement thereupon may be subject to legal action.