

LIGHTING FIXTURE SCHEDULE

Table with columns: ID, MANUF., MODEL NUMBER, VOLT., WATTS, LAMP TYPE, MOUNTING, REMARKS. Lists various lighting fixtures like architectural recessed LEDs, highbays, and wall sconces.

LIGHTING FIXTURE SCHEDULE NOTES: COORDINATE ALL FINISH OPTIONS WITH ARCHITECT.

SPECIAL OUTLET SCHEDULE


Table with columns: ID, VOLTAGE, PHASE, WIRE / COND., DESCRIPTION. Lists special outlets for equipment like extractors, dryers, and dish washers.

SPECIAL OUTLET SCHEDULE NOTES: PROVIDE LOCAL DISCONNECTING FOR DEVICES WITHOUT RECEPTACLE. COORDINATE WITH MOCP.

MOTOR SCHEDULE

Table with columns: ID, VOLTAGE, PHASE, WIRE / COND., DESCRIPTION. Lists various motors for equipment like AHUs, pumps, and grinders.

MOTOR SCHEDULE NOTES: PROVIDE LOCAL FUSIBLE DISCONNECTING MEANS FOR EACH MOTOR. COORDINATE WITH MOTOR MOCP.

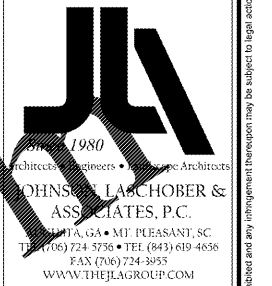

CLIENT: AUGUSTA, GA 535 TELFAIR STREET, AUGUSTA, GA 30901

PROJECT NAME: FIRE STATION #20


PROJECT LOCATION: 2820 OLD HIGHWAY 1, HEPHIZBAH, GEORGIA 30815

Table with columns: REV, DATE, BY, DESCRIPTION. Revision table for the drawing.


PROJECT NO: 3042.1604
DRAWN BY: JAP/JFP
CHECKED BY: FAK
DATE: 8/10/18

SHEET TITLE: ELECTRICAL SCHEDULES AND DETAILS


SCALE: AS NOTED
DRAWING NO: E-401
REV: 0

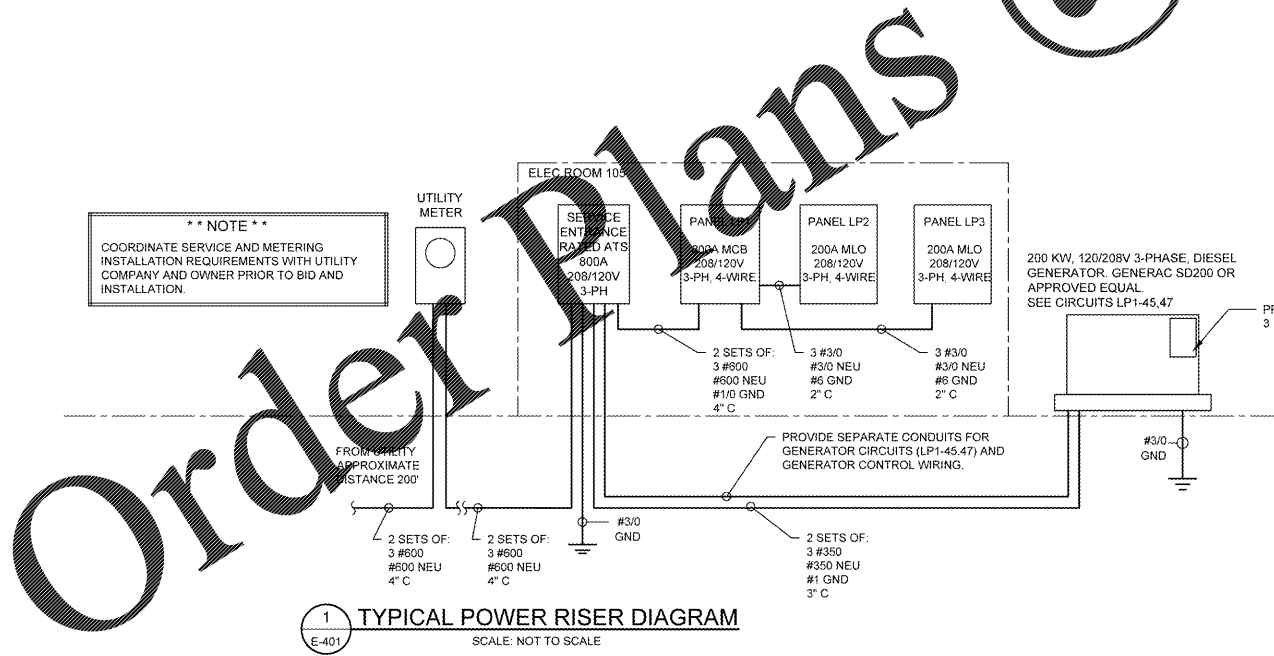

1 TYPICAL POWER RISER DIAGRAM
E-401
SCALE: NOT TO SCALE

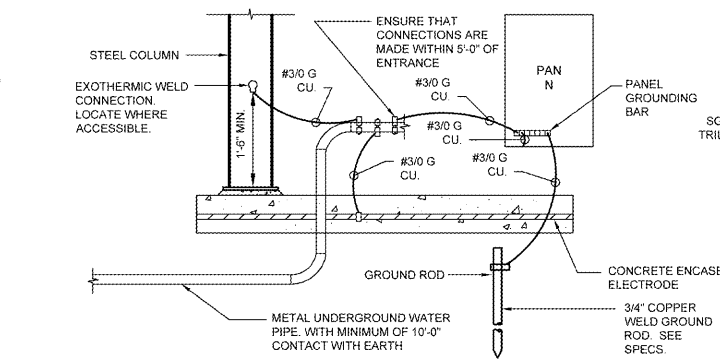

2 ELECTRODE GROUNDING DETAIL
E-401
SCALE: NOT TO SCALE

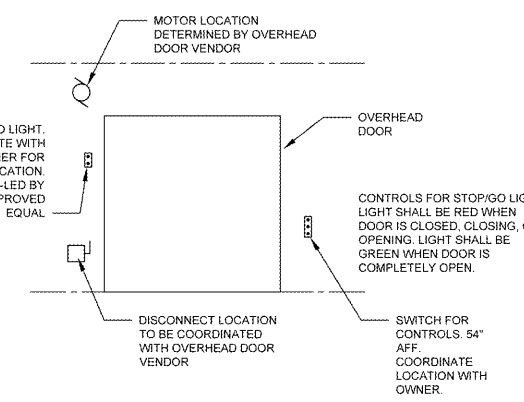

3 OVERHEAD DOOR DETAIL EQUIPMENT LOCATIONS
E-401
SCALE: NONE

WWW.LDMLINE.COM

Order Plans @

Vertical text on the left margin: JOHNSON, LABCHOBBER & ASSOCIATES, P.C.

Vertical text on the right margin: This document is the property of Johnson, Labchober & Associates, P.C. The unauthorized reproduction, copying or otherwise use of this document is strictly prohibited and any infringement thereupon may be subject to legal action.