


Order Plans

@

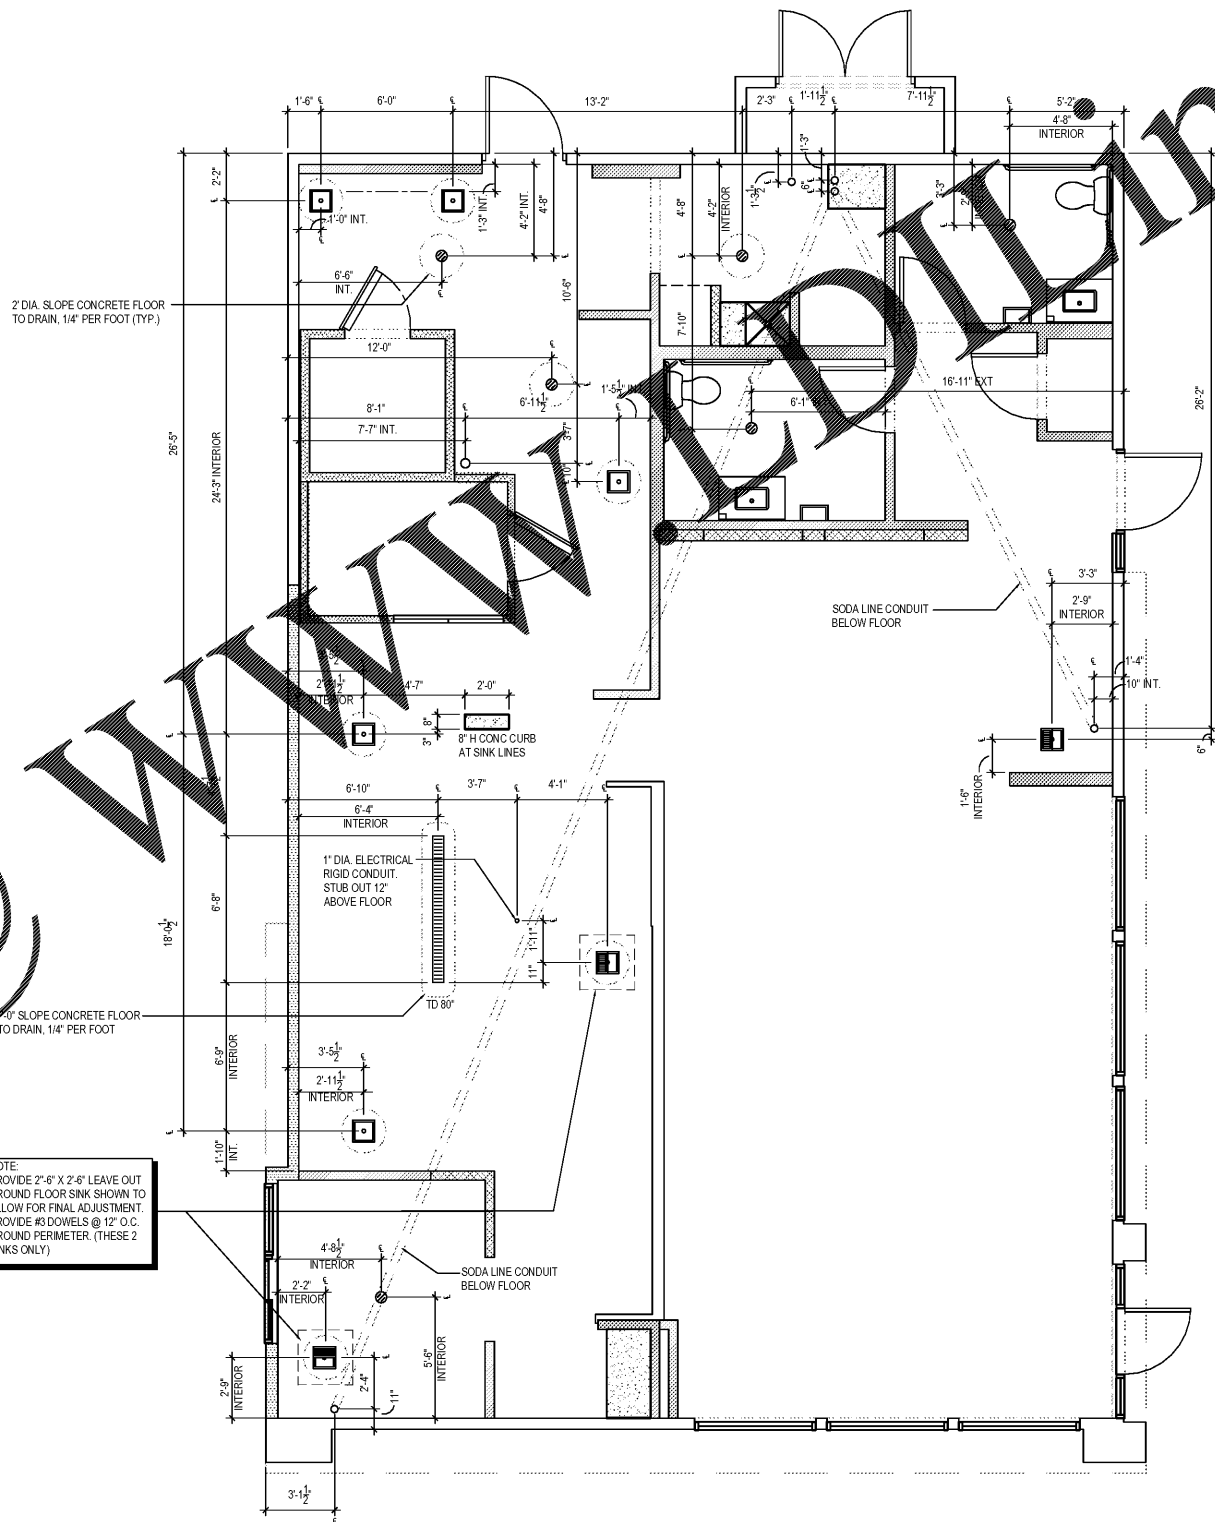

NOTE:
PROVIDE 2'-6" X 2'-6" LEAVE OUT
AROUND FLOOR SINK SHOWN TO
ALLOW FOR FINAL ADJUSTMENT.
PROVIDE #4 DOWELS @ 12" O.C.
AROUND PERIMETER. (THESE 2
SINKS ONLY)

NOT USED 3
Scale= 1 1/2" = 1'-0" A-102

NOT USED 2
Scale= 1 1/2" = 1'-0" A-102

ROUGH - IN PLUMBING PLAN 1
Scale= 1/4" = 1'-0" A-102



PANDA EXPRESS, INC.
1683 Walnut Grove Ave.
Rosemead, California
91770
Telephone: 626.799.9898
Facsimile: 626.372.8288

All ideas, designs, arrangement and plans indicated or represented by this drawing are the property of Panda Express Inc. and were created for use on this specific project. None of these ideas, designs, arrangements or plans may be used by or disclosed to any person, firm, or corporation without the written permission of Panda Express Inc.

REVISIONS:


ISSUE DATE:

1st	ISSUE FOR PERMIT	11-30-18

DRAWN BY: RR

PANDA PROJECT # S8-19-D6559
ARCH PROJECT # 1805

RANDY REYNOLDS
ARCHITECT
315 WALTER ROBERTS ST • FRANKLIN, TN 37064
PHONE (615) 496-8750 • FAX (866) 584-1265

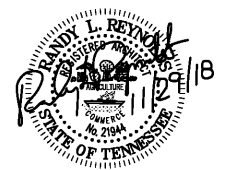

PANDA EXPRESS
ELM HILL PIKE AT DONELSON PIKE
2740 ELM HILL PIKE
NASHVILLE, TN 37214
2200 TRUE R1 (DAB 013)

A-102

ROUGH - IN PLUMBING PLAN