


Order Plans

WWW.LDILine.com

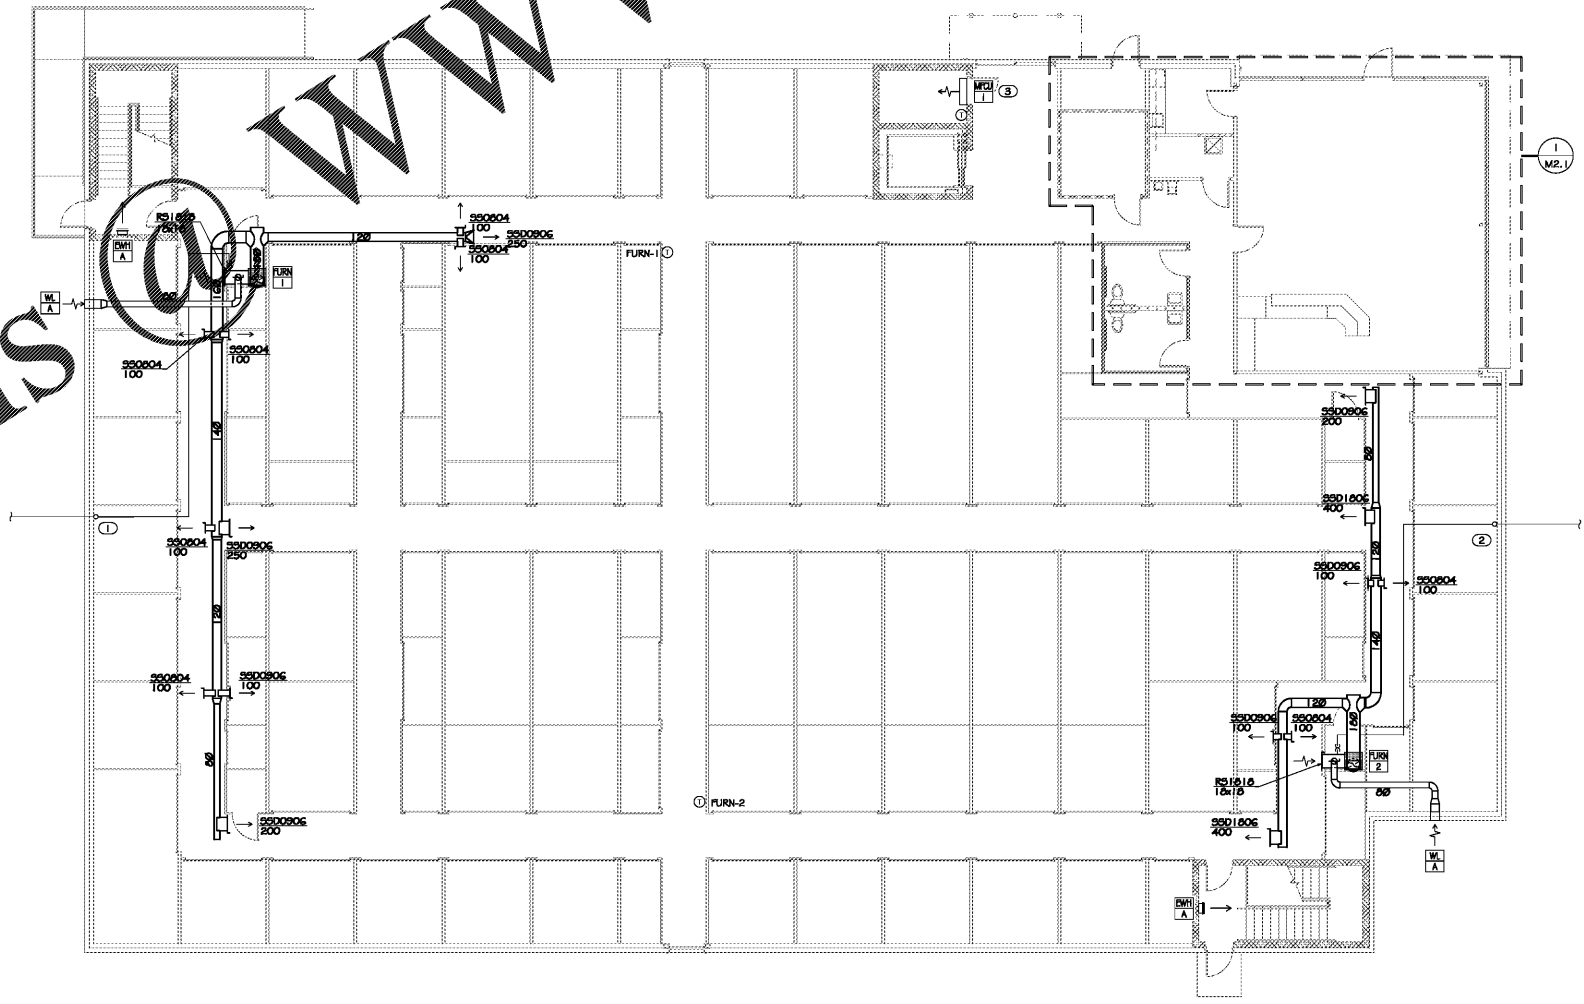


1 FIRST FLOOR PLAN
SCALE: 1/8"=1'-0"

GENERAL NOTES

- A. EACH SUPPLY DIFFUSER/REGISTER RUNOUT SHALL BE PROVIDED WITH A VOLUME DAMPER. REFER TO THE DIFFUSER TAKE-OFF DETAIL FOR ADDITIONAL INFORMATION.
- B. DRAWINGS ARE DIAGRAMMATIC ONLY. FINAL ROUTING OF DUCTWORK AND EQUIPMENT LOCATIONS SHALL BE DETERMINED IN THE FIELD. ADDITIONAL OFFSETS, ELBOWS, ETC. SHALL BE PROVIDED AND INSTALLED WITHOUT ADDITIONAL COST TO THE OWNER.
- C. COORDINATE LOUVER LOCATIONS WITH ARCHITECTURAL ELEVATIONS.

KEYNOTES

- ① CONDENSATE RISER 1. REFER TO CONDENSATE RISER 1 DETAIL ON SHEET M0.2.
- ② CONDENSATE RISER 2. REFER TO CONDENSATE RISER 2 DETAIL ON SHEET M0.2.
- ③ TRAP & ROUTE 1" CONDENSATE DRAIN LINE TO SPLASH BLOCK ON GRADE.

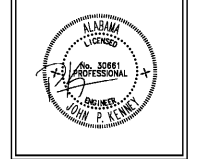

THESE DRAWINGS AND DESIGNS ARE THE PROPERTY OF PROFICIENT ARCHITECTURE, INC. AND SHALL NOT BE REPRODUCED OR TRANSMITTED IN ANY FORM OR BY ANY MEANS, ELECTRONIC OR MECHANICAL, INCLUDING PHOTOCOPYING, RECORDING, OR BY ANY INFORMATION STORAGE AND RETRIEVAL SYSTEM, WITHOUT THE WRITTEN PERMISSION OF PROFICIENT ARCHITECTURE, INC. THESE DRAWINGS AND DESIGNS ARE PREPARED FOR USE ON THIS SPECIFIC PROJECT AND ARE NOT VALID FOR USE ON ANY OTHER PROJECT. ALL DISCREPANCIES MUST BE REPORTED TO THE ARCHITECT IMMEDIATELY UPON DISCOVERY. THE ARCHITECT SHALL BE RESPONSIBLE FOR RESOLVING ALL DISCREPANCIES BEFORE PROCEEDING WITH CONSTRUCTION. THESE DRAWINGS DO NOT SCALE.

Life Storage #354
2020 South College St
Auburn, AL 36832



ISSUE FOR CONSTRUCTION
REVISIONS:

PROJECT NUMBER
201839
DATE
3-15-2019

SHEET NUMBER
M1.1