

Order Plans

WWW.LDILine.com

GENERAL NOTES

A. EACH SUPPLY DIFFUSER/REGISTER RUNOUT SHALL BE PROVIDED WITH A VOLUME DAMPER. REFER TO THE DIFFUSER TAKE-OFF DETAIL FOR ADDITIONAL INFORMATION.


B. DRAWINGS ARE DIAGRAMMATIC ONLY; FINAL ROUTING OF DUCTWORK AND EQUIPMENT LOCATIONS SHALL BE DETERMINED IN THE FIELD. ADDITIONAL OFFSETS, ELBOWS, ETC. SHALL BE PROVIDED AND INSTALLED WITHOUT ADDITIONAL COST TO THE OWNER.

C. COORDINATE LOUVER LOCATIONS WITH ARCHITECTURAL ELEVATIONS.

KEYNOTES

① CONDENSATE RISER 1. REFER TO CONDENSATE RISER 1 DETAIL ON SHEET NO.2.

② CONDENSATE RISER 2. REFER TO CONDENSATE RISER 2 DETAIL ON SHEET NO.2.

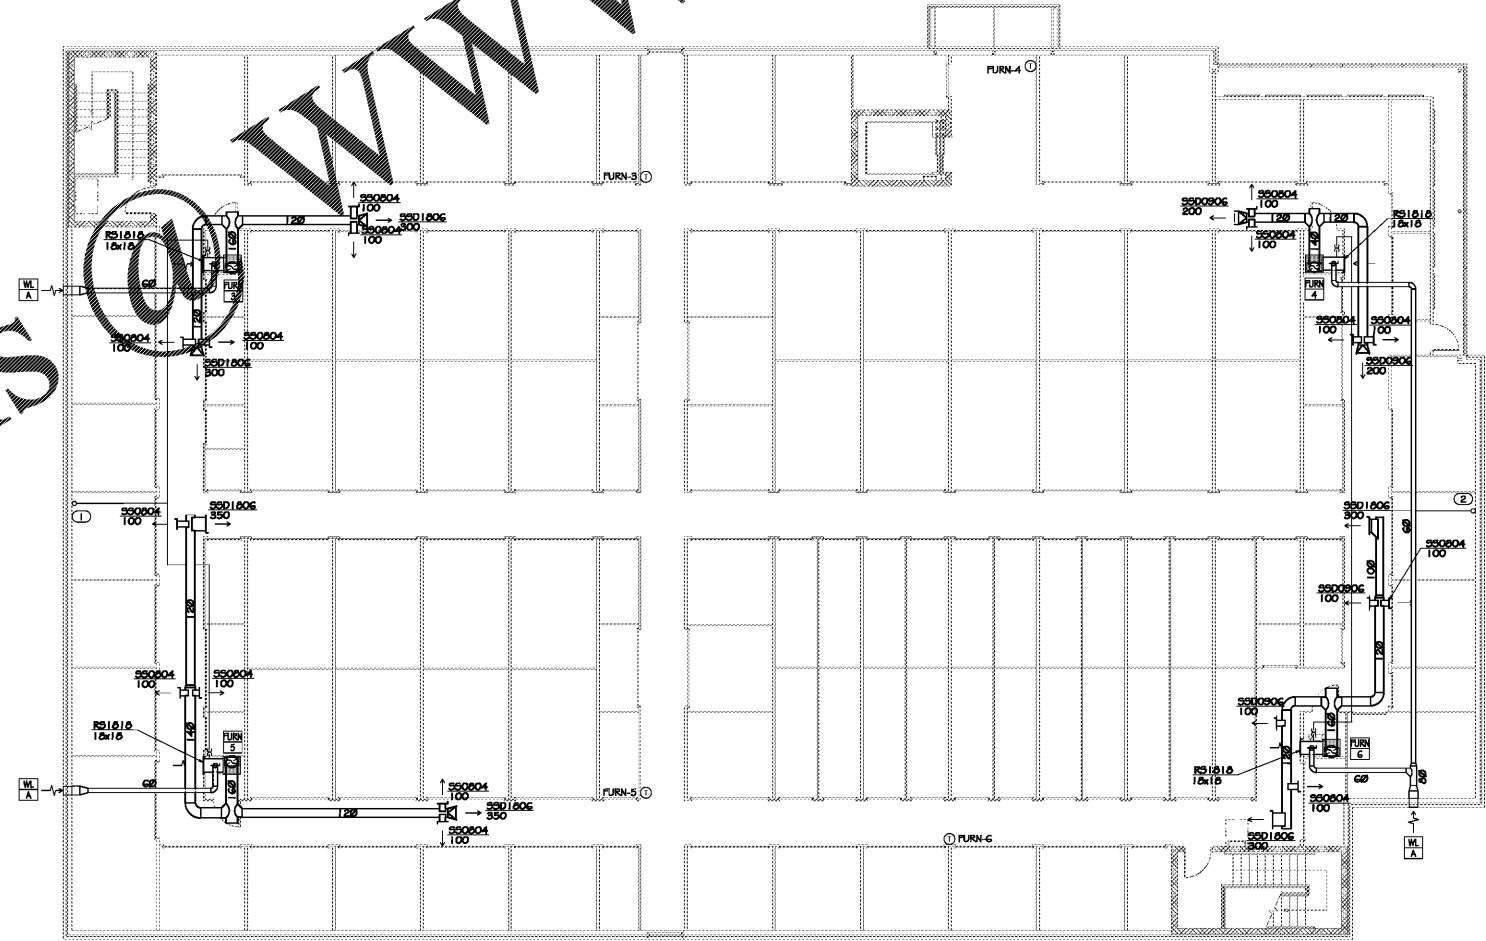

1 SECOND FLOOR PLAN
M1.2 SCALE: 1/8"=1'-0"



THESE DRAWINGS AND DESIGNS ARE THE PROPERTY OF PROFICIENT ARCHITECTURE, INC. AND SHALL NOT BE REPRODUCED, COPIED, OR TRANSMITTED IN ANY FORM OR BY ANY MEANS, ELECTRONIC OR MECHANICAL, WITHOUT THE WRITTEN PERMISSION OF PROFICIENT ARCHITECTURE, INC. THESE DRAWINGS ARE PREPARED FOR USE ON THIS SPECIFIC PROJECT AND ARE NOT TO BE USED FOR ANY OTHER PROJECT. ANY REUSE OF THESE DRAWINGS WITHOUT THE WRITTEN PERMISSION OF PROFICIENT ARCHITECTURE, INC. IS STRICTLY PROHIBITED. ALL DIMENSIONS MUST BE VERIFIED BY THE CONTRACTOR AND DISCREPANCIES BEFORE PROCEEDING WITH CONSTRUCTION. THESE DRAWINGS DO NOT SCALE.

Life Storage #354
2020 South College St
Auburn, AL 36832



ISSUE FOR CONSTRUCTION REVISIONS:

PROJECT NUMBER: 201839
DATE: 3-15-2019

SHEET NUMBER: M1.2