




3 ENLARGED PLAN - WASTE & VENT
SCALE: 1/4"=1'-0"

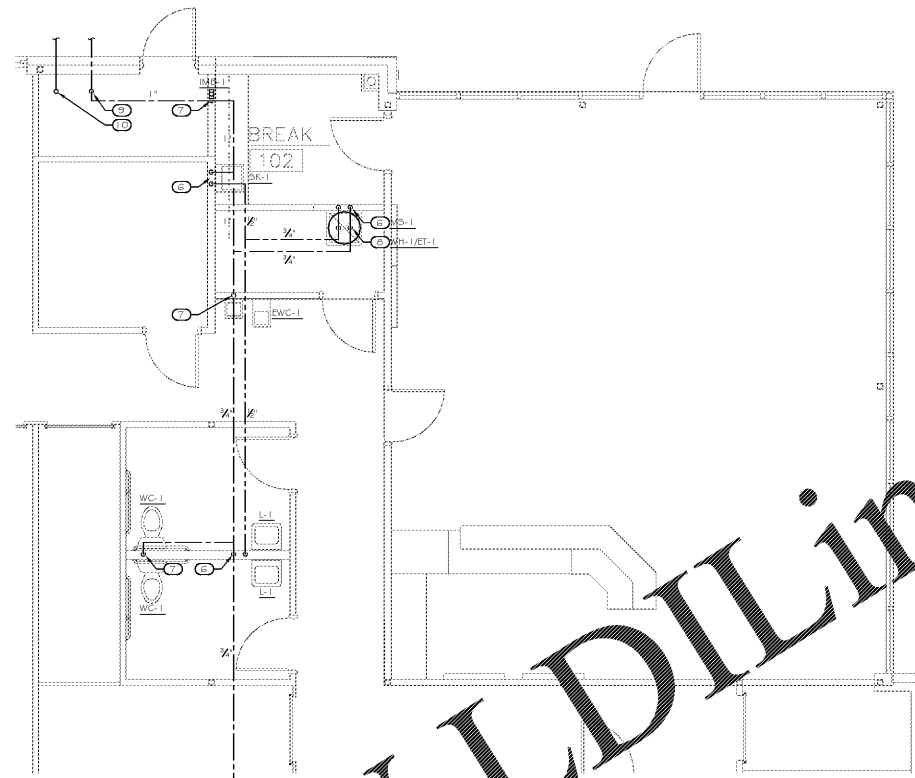

2 ENLARGED PLAN - WATER
SCALE: 1/4"=1'-0"

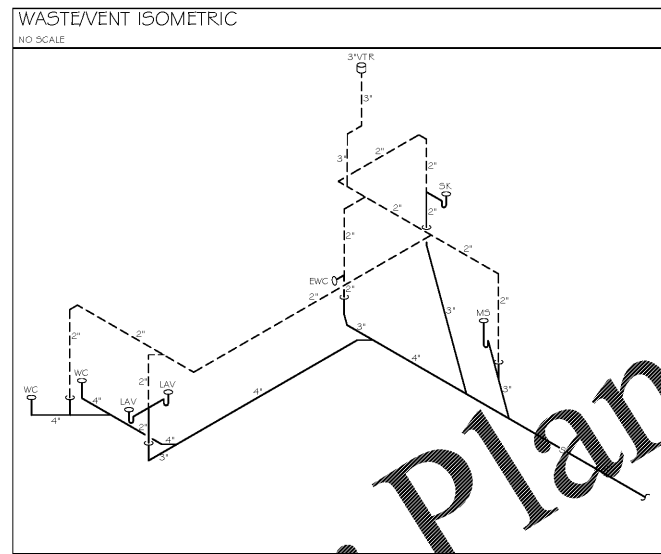

WASTE/VENT ISOMETRIC
NO SCALE

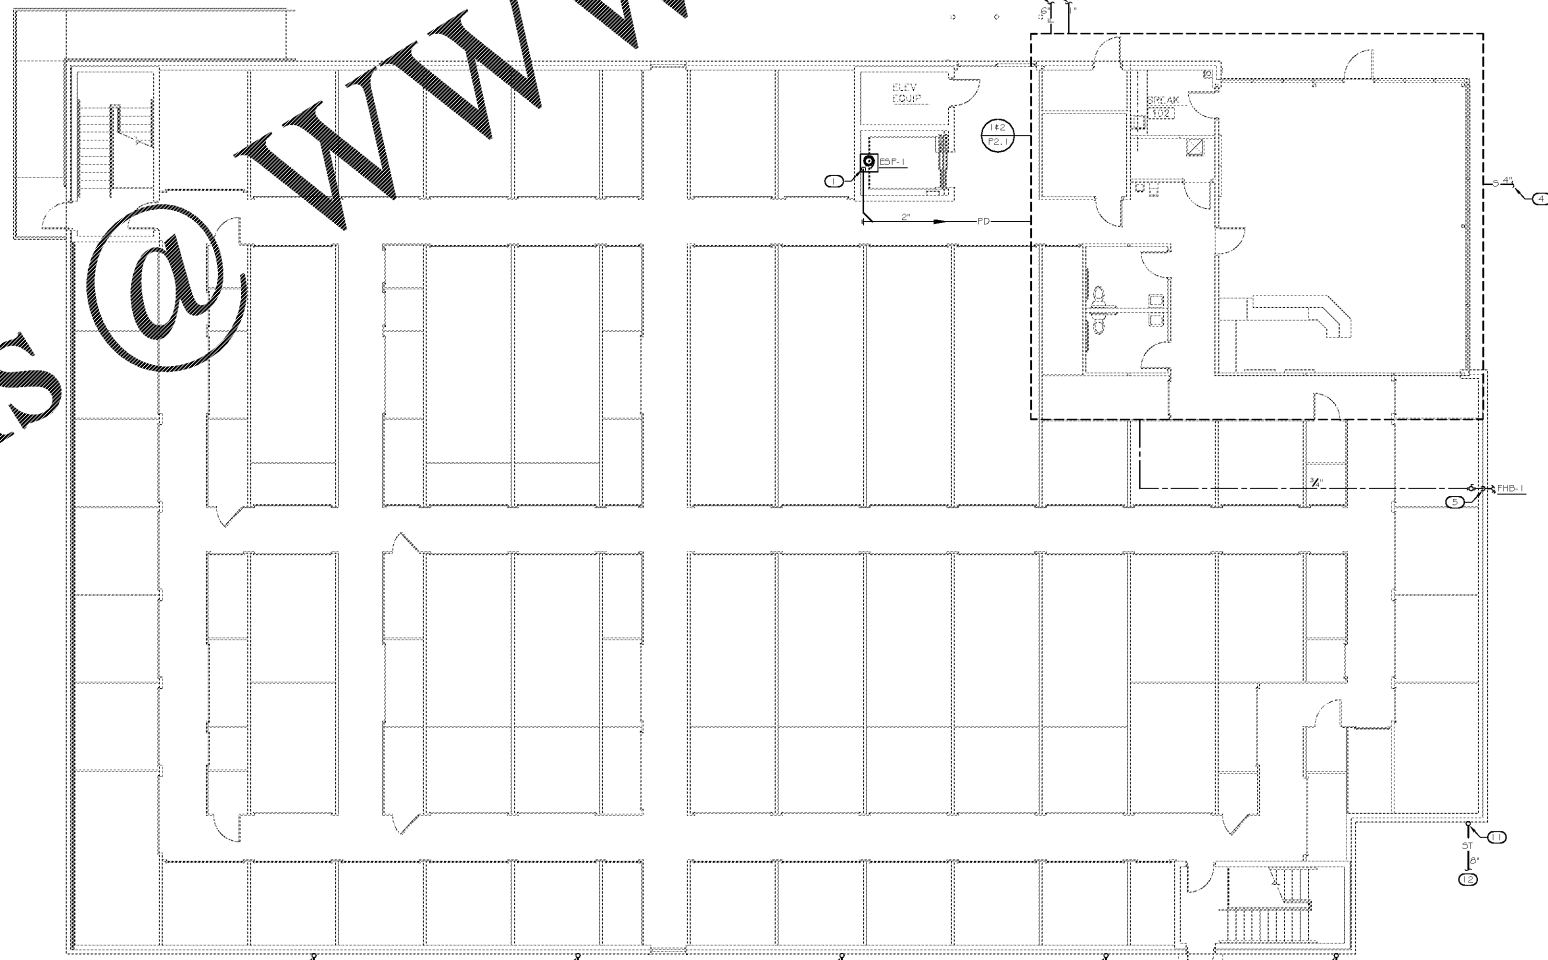


1 FIRST FLOOR PLAN
SCALE: 1/8"=1'-0"

- KEYNOTES
- 1 2" PD DN TO ELEVATOR SUMP PUMP (SEE DETAIL)
 - 2 6" SPRINKLER MAIN BKG, SEE CIVIL DRAWING FOR CONTINUATION AND BACKFLOW PREVENTER
 - 3 1" DOMESTIC WATER SERVICE BKG, SEE CIVIL DWG FOR CONT
 - 4 4" S BKG, SEE CIVIL DWG FOR CONT
 - 5 1/2" CW DN
 - 6 1/2" CW + 1/2" HW DN
 - 7 1/2" CW DN
 - 8 1/2" CW + 1/2" HW DN TO PLATFORM MOUNTED WATER HEATER, SEE DETAIL
 - 9 1" DOMESTIC WATER SERVICE UP WITH SHUTOFF VALVE & PRESSURE GAUGE, PROVIDE PRESSURE REDUCING VALVE IF INCOMING PRESSURE EXCEEDS 50PSI.
 - 10 6" SPRINKLER MAIN DN & STUB UP, SPRINKLER DESIGN BY SPRINKLER CONTRACTOR.
 - 11 6" x 4" DOWNSPOUT DN TO DOWNSPOUT BOX AND TRANSITION TO 2" ST BKG
 - 12 6" ST BKG, SEE CIVIL DWG FOR CONT
 - 13 4" ST FROM ABOVE AND TRANSITION TO 4" DN HORIZ. PENETRATE EXTERIOR WALL & ENLARGE ST TO 6" AT GRADE



THESE DRAWINGS AND DESIGNS ARE THE PROPERTY OF STIMNARD ARCHITECTURE, INC. AND SHALL NOT BE REPRODUCED OR TRANSMITTED IN ANY FORM OR BY ANY MEANS, ELECTRONIC OR MECHANICAL, WITHOUT THE WRITTEN PERMISSION OF STIMNARD ARCHITECTURE, INC. THESE DRAWINGS ARE NOT TO BE USED FOR ANY OTHER PROJECT WITHOUT THE WRITTEN PERMISSION OF STIMNARD ARCHITECTURE, INC. ALL DIMENSIONS MUST BE VERIFIED BY THE CONTRACTOR AND DISCREPANCIES BEFORE PROCEEDING WITH CONSTRUCTION. THESE DRAWINGS DO NOT SCALE.

Life Storage #354
2020 South College St
Auburn, AL 36832

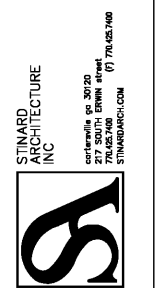

ISSUE FOR CONSTRUCTION REVISIONS:

PROJECT NUMBER
201839
DATE
3-15-2019

SHEET NUMBER
P1.1

Order Plans @ www.LDILine.com