



Order Plans @ www.LDILine.com

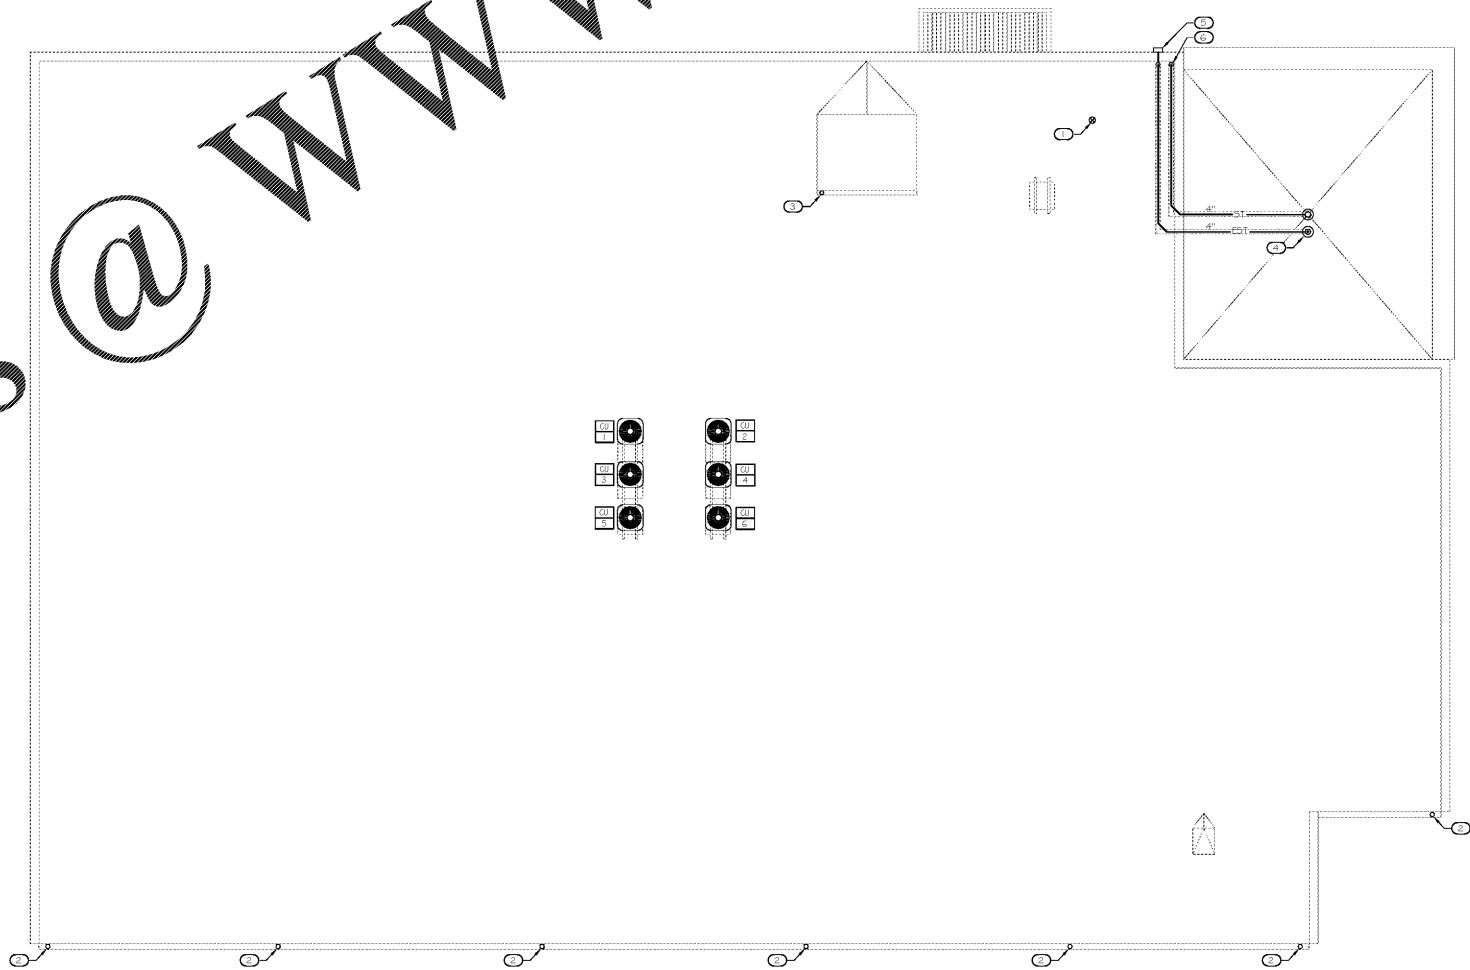


- KEYNOTES**
- 1 3" VTR
 - 2 6" X 6" DOWNSPOUT DN FROM 6" X 6" HORIZONTAL GUTTER, & DISCHARGE TO ROOF BELOW
 - 3 4" X 4" DOWNSPOUT DN FROM 6" X 6" HORIZONTAL GUTTER, & DISCHARGE TO ROOF BELOW
 - 4 3" ROOF DRAIN RD-L, & 3" EMERGENCY ROOF DRAIN EED-L, TRANSITION TO 4" IN HORIZONTAL
 - 5 ROUTE 4" EST @ X/FT TO INTERIOR WALL, DROP DN ALONG INTERIOR WALL AND DISCHARGE WITH DOWNSPOUT NOZZLE, DSN-L
 - 6 ROUTE 4" ST @ X/FT TO INTERIOR WALL, DROP DN ALONG INTERIOR WALL

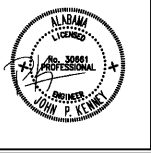

THESE DRAWINGS AND DESIGNS ARE THE PROPERTY OF LDILINE ARCHITECTURE, INC. AND SHALL NOT BE REPRODUCED OR TRANSMITTED IN ANY FORM OR BY ANY MEANS, ELECTRONIC OR MECHANICAL, WITHOUT THE WRITTEN PERMISSION OF LDILINE ARCHITECTURE, INC. THESE DRAWINGS AND DESIGNS ARE NOT TO BE USED FOR ANY OTHER PROJECT OR DATE AND ARE NOT SUITABLE FOR USE IN ANY OTHER MANNER. ALL DIMENSIONS MUST BE VERIFIED BY THE CONTRACTOR AND DISCREPANCIES BEFORE PROCEEDING WITH CONSTRUCTION. DO NOT SCALE DRAWINGS.

Life Storage #354
 2020 South College St
 Auburn, AL 36832

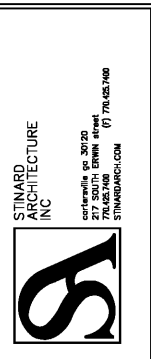

ISSUE FOR CONSTRUCTION REVISIONS:

PROJECT NUMBER
 201839
 DATE
 3-15-2019

SHEET NUMBER
P1.3

1 ROOF FLOOR PLAN
 P1.3 SCALE: 1/8"=1'-0"