


**KEYED NOTES CONTINUED**

24. NEW LIGHT FIXTURE, RE: ELECTRICAL DRAWINGS.
25. EXTERIOR WALL MOUNTED LIGHTING, RE: ELECTRICAL DRAWINGS.
26. INSTALL NEW DOCKLIGHTS, RE: ASD-82A.
27. NEW DECOR LIGHTING TO BE INSTALLED BY ELECTRICIAN. INSTALL LIGHTING AFTER DECOR ELEMENT HAS BEEN INSTALLED.
28. NEW DECOR LIGHTING BY STARBUCKS VENDOR TO BE INSTALLED BY ELECTRICIAN. INSTALL LIGHTING AFTER DECOR ELEMENT HAS BEEN INSTALLED.
29. NEW LIGHT FIXTURE TO BE INSTALLED ABOVE COOLER, RE: ELECTRICAL DRAWINGS.
30. NEW EXTERIOR LIGHT IS TO BE SECURED TO THE CHAIN LINK FENCE POST.
31. NEW EXTERIOR LIGHT TO BE SURFACE MOUNTED TO THE CANOPY.
32. NEW EXTERIOR LIGHT TO BE MOUNTED IN THE VINYL SOFFIT AND FRAMING.
33. EXISTING LIGHTING TO REMAIN.
34. EXISTING CANOPY TO BE PAINTED, RE: A2.1 SERIES FOR NEW FINISH COLOR.
35. NEW BASCART DOOR IS TO BE A VERTICAL LIFT DOOR WITH WALL ANCHORED SUPPORTS.
36. EXISTING GAS PIPING RUNNING BELOW THE CEILING, RE: MECHANICAL DRAWINGS.
37. NEW GAS PIPING, PAINT TO MATCH ADJACENT WALL FINISH, RE: MECHANICAL DRAWINGS.
38. PROVIDE 3" OF SOUND ATTENUATION INSULATION ABOVE THE CEILING.
39. INSTALL PAINTED NEW STEEL CANOPY, PT-013, RE: STD-A1.3 AND STRUCTURAL DRAWINGS.
40. INSTALL NEW DOCKLIGHT, RE: ASD-82.
41. SEE STD-B.1.A FOR HEADER DETAIL AT B PARTING DOOR.

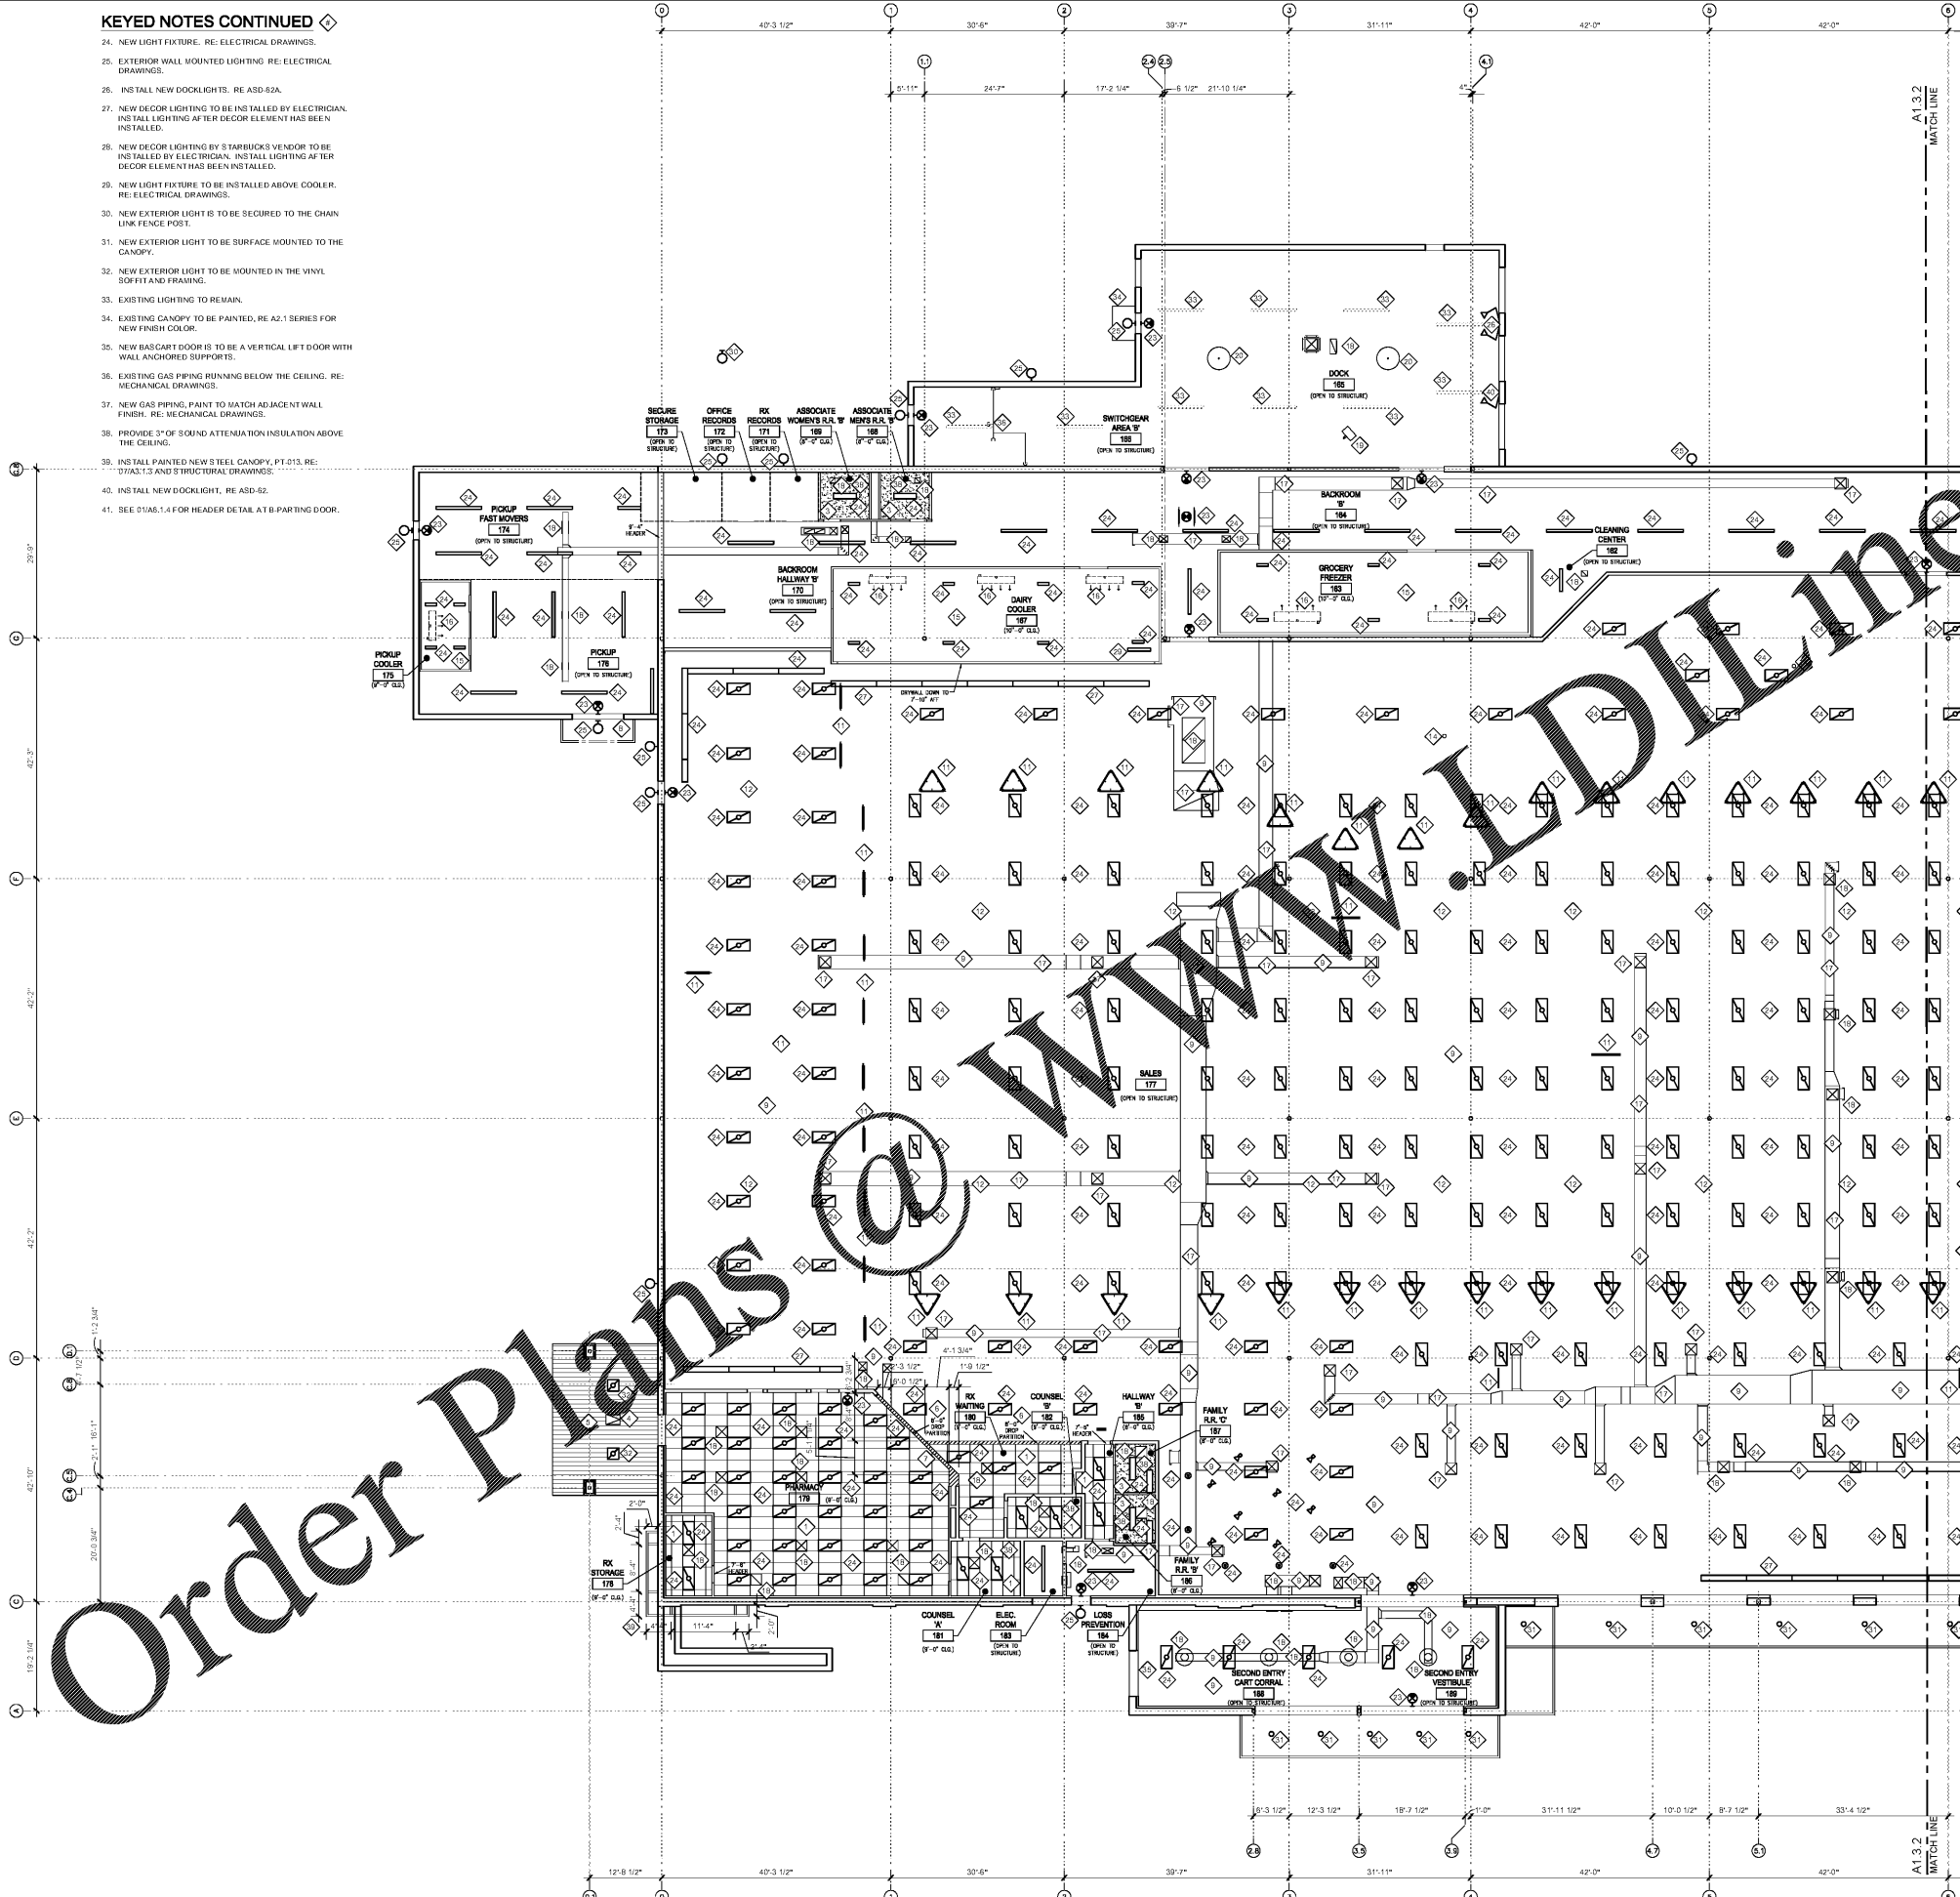

LEGEND, SYMBOLS AND NOTES APPLY TO BOTH A1.3.1 AND A1.3.2 SHEETS, SOME ITEMS MAY NOT APPEAR ON THIS SHEET

**SYMBOL LEGEND**

- SOFFIT TO REMAIN
- NEW PARTITION - PER A3.201 & A3.1.103
- NEW 2x4 SUSPENDED ACOUSTICAL CEILING
- NEW 2x2 SCORED PATTERN ON 2x4 SUSPENDED ACOUSTICAL CEILING
- NEW 2x4 SUSPENDED VINYL CEILING
- NEW 2x4 SUSPENDED METAL CEILING
- NEW GYPSUM BOARD SOFFIT/CEILING
- NEW ALUMINUM SOFFIT PANELS (FLUTES TO RUN AS INDICATED)
- EXISTING AIR DISTRIBUTION DEVICE
- NEW AIR DISTRIBUTION DEVICE
- EXISTING 8" FLEXIBLE LIGHT
- NEW 2x4 LIGHT
- NEW 4'-0" SUSPENDED LIGHT
- NEW 8'-0" SUSPENDED LIGHT
- NEW RECESSED LIGHT
- NEW BUILDING MOUNTED LIGHT
- NEW TRACK LIGHT
- NEW SINGLE POINT TRACK LIGHT
- NEW COOLER/FREEZER LIGHT
- NEW PENDANT LIGHT

**GENERAL NOTES**

1. PATCH AND REPAIR SOFFITS, PARTITIONS AND HEADWALLS AS NEEDED.
2. SEE STRUCTURAL, MECHANICAL AND ELECTRICAL DRAWINGS FOR ADDITIONAL INFORMATION.
3. RAISE, LOWER, AND OR RELOCATE PLUMBING, MECHANICAL, ELECTRICAL, REFRIGERATION AND FIRE SPRINKLER LINES AND EQUIPMENT AS REQUIRED FOR NEW CEILING, VERIFY IN FIELD.
4. THE EXISTING FIRE ALARM AND FIRE SPRINKLER SYSTEMS ARE TO REMAIN OPERATIONAL UNTIL THE NEW SYSTEM IS OPERATIONAL AND APPROVED BY THE AUTHORITY HAVING JURISDICTION.
5. PROVIDE CONTROL JOINTS IN GYP. BD. SOFFITS SPACED NO MORE THAN 30'-0" O.C.
6. ALL DIMENSIONS TO BE VERIFIED IN THE FIELD.
7. THE GENERAL CONTRACTOR IS TO PROVIDE 50 NEW ACOUSTICAL AND VINYL FACED CEILING TILES TO MATCH EXISTING FOR FUTURE STORE MAINTENANCE.
8. ALL HVAC WALL GRILLES TO BE PAINTED TO MATCH SURROUNDING WALL BACKGROUND COLOR, UNLESS OTHERWISE NOTED.
9. REFER TO A5.1 SERIES FOR ARCHITECTURAL STANDARD DETAILS (ASDS) AND GENERAL INSTALLATION DETAILS (GSDS).

**KEYED NOTES**

1. NEW 2x4 SUSPENDED ACOUSTICAL CEILING TILES AND GRID.
2. NEW 2x4 SUSPENDED VINYL CEILING TILES AND GRID.
3. PROVIDE NEW METAL FRAMING, HOISTURE RESISTANT GYPSUM BOARD AND PAINT, PT-702.
4. PROVIDE MINIMUM OF 2250'S NEW LOCKABLE ACCESS PANEL.
5. PROVIDE NEW METAL FRAMING AND EXTERIOR ALUMINUM SOFFIT PANELS. FLUTES ARE TO RUN IN DIRECTION INDICATED.
6. NEW DROP PARTITION PER A3.1.303 & A3.211.
7. REFER TO ASD-50 FOR PHARMACY GRILLE TRACK.
8. NEW PREFABRICATED CANOPY, RE: STRUCTURAL DRAWINGS & STD-A1.1.
9. ALL ITEMS LOCATED IN THE STRUCTURE ABOVE THE SALES FLOOR AND VESTIBULES ARE TO BE PAINTED, PT-733. THIS INCLUDES BUT IS NOT LIMITED TO THE DUCT WORK, REFRIGERATION LINES, SPRINKLER PIPING, PLUMBING PIPING, CABLING, UNSTRUT, STRUCTURE, ECT.
10. NEW WALL DECOR ELEMENT, RE: DECOR DRAWINGS 01.3-11.3.3, 11.5.10.2 SERIES. ELEMENT SUPPLIED BY KROGER AND INSTALLED BY GENERAL CONTRACTOR. COORDINATE ALL DECOR BLOCKING PRIOR TO CLOSING IN NEW PARTITIONS.
11. NEW HANGING DECOR ELEMENT, RE: DECOR DRAWINGS ELEMENT 01.3.14.1.3.3, 11.5.10.2 SERIES. SUPPLIED BY KROGER AND INSTALLED BY GENERAL CONTRACTOR. ALL SUSPENDED DECOR IS TO BE INSTALLED TO THE TOP CORD OF THE JOIST WITHOUT EXCEPTION. CONDUIT OR UNSTRUT IS TO BE USED WHEN NECESSARY.
12. REFER TO CENTER STORE FIXTURE SIGNAGE PLACEMENT GUIDE ON A5.2 FOR ISLE PRODUCE SIGNS.
13. INSTALL NEW MENU SIGNS RE: ELECTRICAL DRAWINGS PER ASD-72.
14. REFER TO RISD-35 AND RISD-35A FOR REFRIGERATION RISERS. PAINT RISERS PT-730 TO MATCH COLUMNS.
15. REFRIGERATION CONTRACTOR TO INSTALL NEW COOLER/FREEZER PANEL CEILING.
16. REFRIGERATION CONTRACTOR IS TO INSTALL NEW EVAPORATIVE COIL.
17. EXISTING AIR DISTRIBUTION DEVICE/DUCT WORK TO REMAIN, RE: MECHANICAL DRAWINGS.
18. NEW AIR DISTRIBUTION DEVICE/DUCT WORK, REFER TO MECHANICAL DRAWINGS.
19. EXISTING GAS FIRED UNIT HEATER, RE: MECHANICAL DRAWINGS.
20. DE STRATIFICATION FAN, RE: MECHANICAL DRAWINGS. MOUNT THE NEW FAN ON UNITS CONNECTED TO THE TOP CORD OF THE CLOSEST TWO JOISTS.
21. NEW VENTHOOD, RE: MECHANICAL DRAWINGS.
22. SURROUND THE HOOD WITH A MINIMUM OF 18" FF STAINLESS STEEL LAY IN CEILING PANELS. INSTALL METAL PANELS TO THE NEXT FULL TILE OUTSIDE THE MINIMUM CLEARANCE. NOT CUT STAINLESS STEEL PANELS WILL BE ACCEPTED.
23. NEW PHOTO LUMINESCENT EXIT SIGN, SUPPLIED AND INSTALLED BY GENERAL CONTRACTOR.

**KROGER**  
STORE #473

2013 UNIVERSITY AVENUE  
OXFORD, MISSISSIPPI 38655

A DEVELOPMENT OF:  
THE KROGER COMPANY

**naos**  
Naos Design Group Of Mississippi, PLLC.

MARC BREETZ, ARCHITECT

645 Lakeland East Drive Suite 101  
Flowood, Mississippi 39232  
(p) 303.759.5777  
(f) 720.360.4281

ARCHITECT OF RECORD

**CDS**  
COMMERCIAL DESIGN SYSTEMS, INC.

1925 SW GALEREAH DRIVE  
SHERWOOD, OREGON 97140  
503.855.7000 (P) 503.825.5902

INTERIOR DECOR

**Pickering Firm, Inc.**  
Architects - Engineering  
Planning - Surveying

6775 Lenox Center Court Suite 300  
Memphis, TN 38115  
901.726.0816

ENGINEER OF RECORD:  
STRUCTURAL  
MECHANICAL  
ELECTRICAL  
CIVIL ENGINEER

**VSOFT**  
INFRASTRUCTURE

1500 CHESTER ROAD  
CINCINNATI, OH 45216  
T: 513-670-3069

LOW VOLTAGE

**telgian**  
TELGIAN CORPORATION  
10230 SOUTH 50TH PLACE  
SUITE 100  
PHOENIX, AZ 85044  
T: (602) 836-4426  
HTTP://WWW.TELGIAN.COM  
FIRE PROTECTION

**ISSUE LOG**


NO.	REV.	DESCRIPTION	DATE
1	-	PERMIT SET	12/05/18
2	-	810 SET	03/21/19

JOB: 2018041 SCALE: 3/32" = 1'-0"

SHEET NO. **A1.3.1**  
PARTIAL REFLECTED CEILING PLAN WEST

**PARTIAL REFLECTED 01 CEILING PLAN WEST**

SCALE: 3/32" = 1'-0"

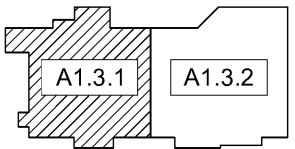

**KEY PLAN**

SCALE: NOT TO SCALE

Order Plans @ WWW.LDLINE.COM