


KEYED NOTES CONTINUED

- 30. EXISTING ROOF TOP EQUIPMENT TO REMAIN. PROVIDE NEW FLASHING/COVER FLASHING AND SEAL CURB TO NEW ROOFING. RE: ASD-64C.
- 31. INSTALL NEW ROOF TOP UNIT AND CURB PER ASD-64C AND ASD-78.
- 32. INSTALL NEW EXHAUST FAN AND CURB PER ASD-88.
- 33. INSTALL NEW CONDENSING UNIT AND CURB PER ASD-88.
- 34. EXISTING GAS PIPING. PAINT EXPOSED PIPE PT-716. RE: MECHANICAL DRAWINGS. INSTALL NEW PIPE SUPPORTS PER PSD-35. RE: PLUMBING DRAWINGS.
- 35. NEW GAS PIPING. PAINT EXPOSED PIPE PT-716. RE: MECHANICAL DRAWINGS. INSTALL NEW PIPE SUPPORTS PER PSD-35. RE: PLUMBING DRAWINGS.
- 36. NEW SATELLITE DISHES AND BALLASTED SUPPORTS. FLASH AS NECESSARY. RE: ESD-27RES.1 FOR ROOF PENETRATION DETAIL.
- 37. INSTALL SLATED LOUVER METAL ROOF SCREEN WITH STANDARD TRIM FROM ROOFSCREENS.COM. RE: STRUCTURAL DRAWINGS AND MANUFACTURER'S SHOP DRAWINGS.

ALTERNATE #1


- THE GENERAL CONTRACTOR IS TO BID THE SETTING, INSTALLATION, CONNECTION, ELECTRICAL WIRING, ELECTRICAL CONNECTIONS, ETC. FOR THE EQUIPMENT SHOWN NOTED IN THE MEAS. PREP - 03 AND TENANT PREP - 119 AS ALTERNATE #1 IN THEIR BID. THE HOOD, ROOF PENETRATION, WIRING, SWITCHES, ETC. FOR THE BUNKER IN TENANT PREP - 119 IS TO BE INCLUDED IN THE ALTERNATE #1.
- 38. INSTALL NEW EXHAUST FAN AND CURB PER ASD-88 IF ALTERNATE #1 IS ACCEPTED.
- 39. INSTALL ADDITIONAL NEW GAS PIPING. PAINT EXPOSED PIPE PT-716. RE: MECHANICAL DRAWINGS. INSTALL NEW PIPE SUPPORTS PER PSD-35. RE: PLUMBING DRAWINGS.

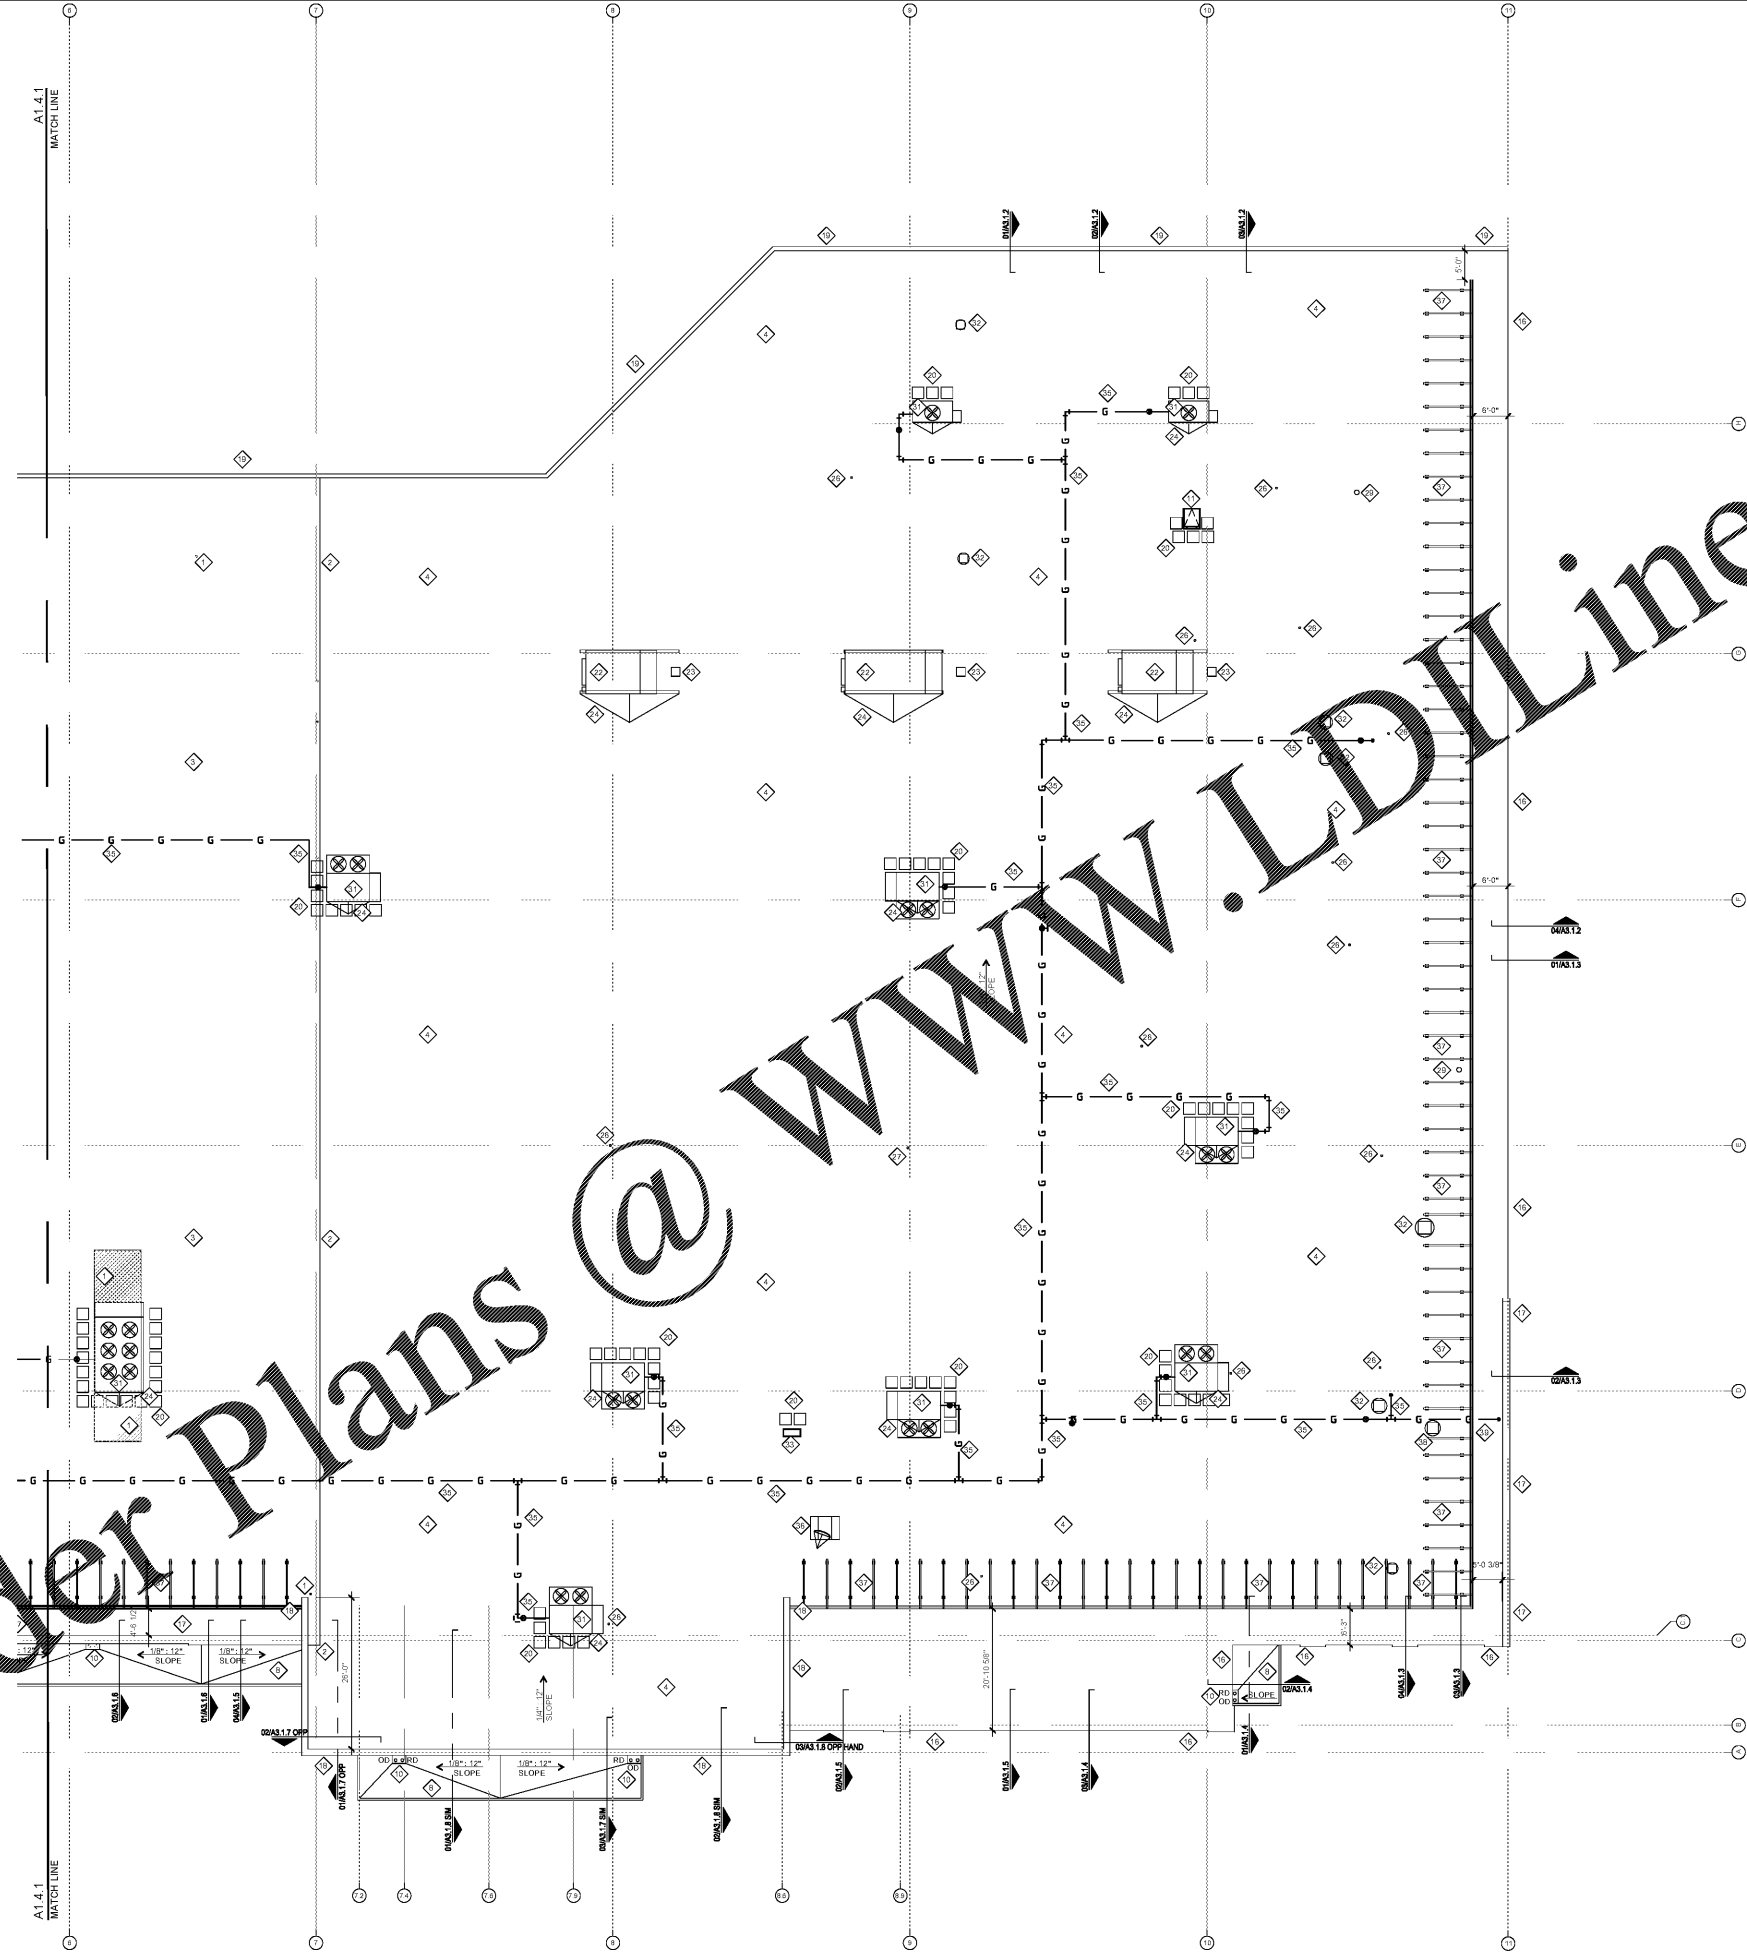

- SYMBOL LEGEND**
- EXISTING ROOF TOP EQUIPMENT
 - NEW ROOF TOP EQUIPMENT
 - - - EXISTING GAS LINE, RE: MECHANICAL DRAWINGS
 - - - NEW GAS LINE, RE: MECHANICAL DRAWINGS
 - RD NEW ROOF DRAIN
 - OD NEW OVERFLOW DRAIN
 - OS NEW OVERFLOW SCUPPER
 - ▨ INFILL ROOF DECKING PRIOR TO NEW INSULATION AND ROOFING.

- GENERAL NOTES**
1. SEAL ALL ROOF PENETRATIONS.
 2. RESEAL ALL CONTROL AND EXPANSION JOINTS AT THE EXTERIOR PARAPET WALLS.
 3. NEW ROOF TOP EQUIPMENT TO BE SET ON TOP OF CURB OR PLATFORMS. REFER TO MECHANICAL DRAWINGS.
 4. FOR HVAC EQUIPMENT, DUCTWORK AND GYPSUM AND DUCTWORK PENETRATION OF ROOF TO MECHANICAL DRAWINGS.
 5. ROOF TOP EQUIPMENT MUST BE A MINIMUM OF 10' FROM THE EDGE OF THE ROOF. REFER TO MECHANICAL DRAWINGS.
 6. EXHAUST FANS ARE TO BE SET AT LEAST 10' FROM AN AIR INTAKE. REFER TO MECHANICAL DRAWINGS.
 7. ALL EXPOSED ROOF GAS LINES TO BE PAINTED SAFETY.
 8. DETERMINE WHETHER TO REMOVE FROM ROOF: ROOF DRAIN, OVERFLOWS AND GUTTERS AT THE COMPLETION OF THE ROOFING PHASE OF THE PROJECT AND AGAIN AT THE COMPLETION OF THE PROJECT.
 9. GAS LINES ON THE ROOF ARE SHOWN FOR REFERENCE ONLY. ALL GAS LINE IS TO BE SUPPORTED PER PSD-35RE: MECHANICAL PLUMBING DRAWINGS.
 10. REFER TO A2.1 SERIES FOR EXTERIOR FINISH MATERIALS LEGEND.
 11. REFER TO M.E. FOR HVAC EQUIPMENT ORDERING INFORMATION SCHEDULE.
 12. REFER TO A5.1 SERIES FOR ARCHITECTURAL STANDARD DETAILS (ASDs) AND GENERAL INSTALLATION DETAILS (GSDs).

- KEYED NOTES**
1. INSTALL NEW METAL DECK INFILL TO MATCH EXISTING WHERE EQUIPMENT OR VENTS WERE REMOVED. RE: STRUCTURAL DRAWINGS.
 2. LINE OF EXPANSION BELOW.
 3. NEW INDUCTION WELDED 60 MIL WHITE THERMOPLASTIC (TPO) ROOFING OVER ± 1/2" OF NEW POLYISOCYANURATE RIGID INSULATION OVER EXISTING INSULATION, METAL DECKING AND STRUCTURE. EXTERIOR MEMBRANE UP AND OVER TOP OF PARAPET EXCEPT AS NOTED. TOTAL RIGID INSULATION IS TO BE 4" TOTAL WITH THE NEW AND EXISTING LAYERS. RE: STRUCTURAL DRAWINGS, SIMILAR TO 62(A) 4.1 AND SPECIFICATIONS FOR ADDITIONAL REQUIREMENTS.
 4. NEW INDUCTION WELDED 60 MIL WHITE THERMOPLASTIC (TPO) ROOFING OVER ± 4" OF POLYISOCYANURATE RIGID INSULATION OVER NEW METAL DECKING AND STRUCTURE. EXTERIOR MEMBRANE UP AND OVER TOP OF PARAPET EXCEPT AS NOTED. RE: STRUCTURAL DRAWINGS, SIMILAR TO 62(A) 4.1 AND SPECIFICATIONS FOR ADDITIONAL REQUIREMENTS.
 5. NEW PREFABRICATED CANOPY WITH INTEGRAL ROOF SCUPPER. RE: STRUCTURAL DRAWINGS & 01(A) 1.1.
 6. NEW FULLY ADHERED 60 MIL WHITE THERMOPLASTIC (TPO) ROOFING OVER ± 4" OF TAPERED POLYISOCYANURATE RIGID INSULATION OVER NEW METAL DECKING AND STRUCTURE. EXTERIOR MEMBRANE UP AND OVER TOP OF PARAPET EXCEPT AS NOTED. RE: STRUCTURAL DRAWINGS, SIMILAR TO 62(A) 4.1 AND SPECIFICATIONS FOR ADDITIONAL REQUIREMENTS.
 7. NEW FULLY ADHERED 60 MIL WHITE THERMOPLASTIC (TPO) ROOFING OVER ± 4" OF TAPERED POLYISOCYANURATE RIGID INSULATION OVER NEW METAL DECKING AND STRUCTURE. EXTERIOR MEMBRANE UP AND OVER TOP OF PARAPET EXCEPT AS NOTED. RE: STRUCTURAL DRAWINGS, SIMILAR TO 62(A) 4.1 AND SPECIFICATIONS FOR ADDITIONAL REQUIREMENTS.
 8. NEW PAINTED STEEL CANOPY AND SUPPORT ROOF, PT-013, WITH NEW FULLY ADHERED 60 MIL WHITE TPO ROOFING. OVER 2" OF TAPERED POLYISOCYANURATE RIGID INSULATION OVER NEW METAL DECKING AND STRUCTURE. EXTERIOR MEMBRANE UP AND OVER TOP OF PARAPET EXCEPT AS NOTED. RE: STRUCTURAL DRAWINGS, SIMILAR TO 02(A) 1.1 AND SPECIFICATIONS FOR ADDITIONAL REQUIREMENTS.
 9. INSTALL PAINTED NEW STEEL CANOPY, PT-013. RE: 07(A) 1.3 AND STRUCTURAL DRAWINGS.
 10. INSTALL NEW 3" ROOF DRAIN, 3" OVER FLOW AND DOWN SPOUT. RE: 01(A) 1.2 AND 05(A) 1.4. OVER FLOW TO BE SIMILAR.
 11. INSTALL 3'2" X 2'6" ROOF HATCH. RE: 05 & 05(A) 1.2. NEW ROOF HATCH ACCESSORY RAILS PER SPECIFICATION.
 12. NEW WALL MOUNTED ACCESS LADDER ATTACHED TO EXISTING CHU WALL. PAINT THE LADDER PT-01. RE: 05(A) 1.3 & 05(A) 1.3.
 13. PAINT EXISTING DOCK HOOD, PT-13.
 14. PAINT EXISTING DOOR HOOD, PT-13.
 15. NEW DRIVE THRU CLEARANCE INDICATOR SIGN. RE: ASD-32.
 16. NEW METAL COPING, MC-01. RE: ASD-65A.
 17. NEW METAL CAP FLASHING, MC-02. RE: ASD-64A.
 18. NEW METAL CAP FLASHING, MC-03. RE: ASD-64A.
 19. NEW METAL GUTTER, MG-01, AND DOWNSPOUT, MD-01. RE: ASD-64B.
 20. NEW CONCRETE WALK PADS.
 21. NEW REFRIGERATION CONDENSING UNIT AND RAIL CURBS OVER THE EXISTING ROOF DECK AND STRUCTURE. RE: ASD-82.
 22. NEW REFRIGERATION CONDENSING UNIT AND RAIL CURBS OVER NEW ROOF DECK AND STRUCTURE. RE: ASD-81.
 23. NEW PIPE FABRICATED SHEET METAL BOX FOR REFRIGERATION CHANNEL PIPING. RE: ASD-78.
 24. INSTALL NEW ROOF CRIBS AT NEW CURB. ONLY INSTALL ON CURBS THAT ARE 8'0" OR LONGER.
 25. EXISTING PLUMBING VENT TO REMAIN. FLASH AND SEAL EXISTING PIPE TO NEW ROOFING. RE: PLUMBING DRAWINGS.
 26. INSTALL NEW PLUMBING VENT. RE: PLUMBING DRAWINGS.
 27. NEW FREEZE PROOF ROOF TOP HYDRANT. RE: PLUMBING DRAWINGS.
 28. EXISTING MECHANICAL FLUE TO REMAIN. FLASH AND SEAL EXISTING PIPE TO NEW ROOFING. RE: MECHANICAL DRAWINGS.
 29. INSTALL NEW UTENSIL WASHER FLUE. RE: MECHANICAL DRAWINGS.

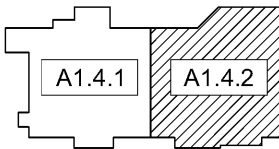

PARTIAL 01 ROOF PLAN EAST
SCALE: 3/32" = 1'-0"

KEY PLAN
SCALE: NOT TO SCALE

KROGER
STORE #473

2013 UNIVERSITY AVENUE
OXFORD, MISSISSIPPI 38655

A DEVELOPMENT OF:
THE KROGER COMPANY

Naos Design Group Of Mississippi, PLLC.

MARC BREETZ, ARCHITECT

645 Lakeland East Drive
Suite 101
Flowood, Mississippi 39232
(p) 303.759.5777
(f) 720.360.4281

ARCHITECT OF RECORD

CDS
COMMERCIAL DESIGN SYSTEMS, INC.

1925 SW GALLERIE DRIVE
SHERWOOD, OREGON 97140
503.885.7000 (P) 503.625.5902

INTERIOR DECOR

Pickering Firm, Inc.
Architecture - Engineering
Planning - Surveying

6775 Lenox Center Court, Suite 300
Memphis, TN 38115
901.726.0810

ENGINEER OF RECORD:
STRUCTURAL
MECHANICAL
ELECTRICAL
CIVIL ENGINEER

V-SOFT
INFRASTRUCTURE

1650 CHESTER ROAD
CINCINNATI, OH 45216
T: 513-670-3069

LOW VOLTAGE

telgian
TELIGIAN CORPORATION
10230 SOUTH 50TH PLACE
SUITE 100
PHOENIX, AZ 85044
T: (677) 836-4426
HTTP://WWW.TELIGIAN.COM
FIRE PROTECTION

ISSUE LOG

NO.	REV.	DESCRIPTION	DATE
1	-	PERMIT SET	12/05/18
2	-	BID SET	03/21/19

JOB: 2018041 SCALE: 3/32" = 1'-0"

SHEET NO. **A1.4.2**

PARTIAL ROOF PLAN EAST

COPYRIGHT © 2018 BY V-SOFT INFRASTRUCTURE, A DIVISION OF MISSISSIPPI. ALL RIGHTS RESERVED. THIS DRAWING IS THE PROPERTY OF V-SOFT INFRASTRUCTURE. NO PART OF THIS DRAWING IS TO BE REPRODUCED OR TRANSMITTED IN ANY FORM OR BY ANY MEANS, ELECTRONIC OR MECHANICAL, WITHOUT THE WRITTEN CONSENT OF V-SOFT INFRASTRUCTURE.

Order Plans @ www.LDLine.com