


Order Plans @ www.LDilLine.com

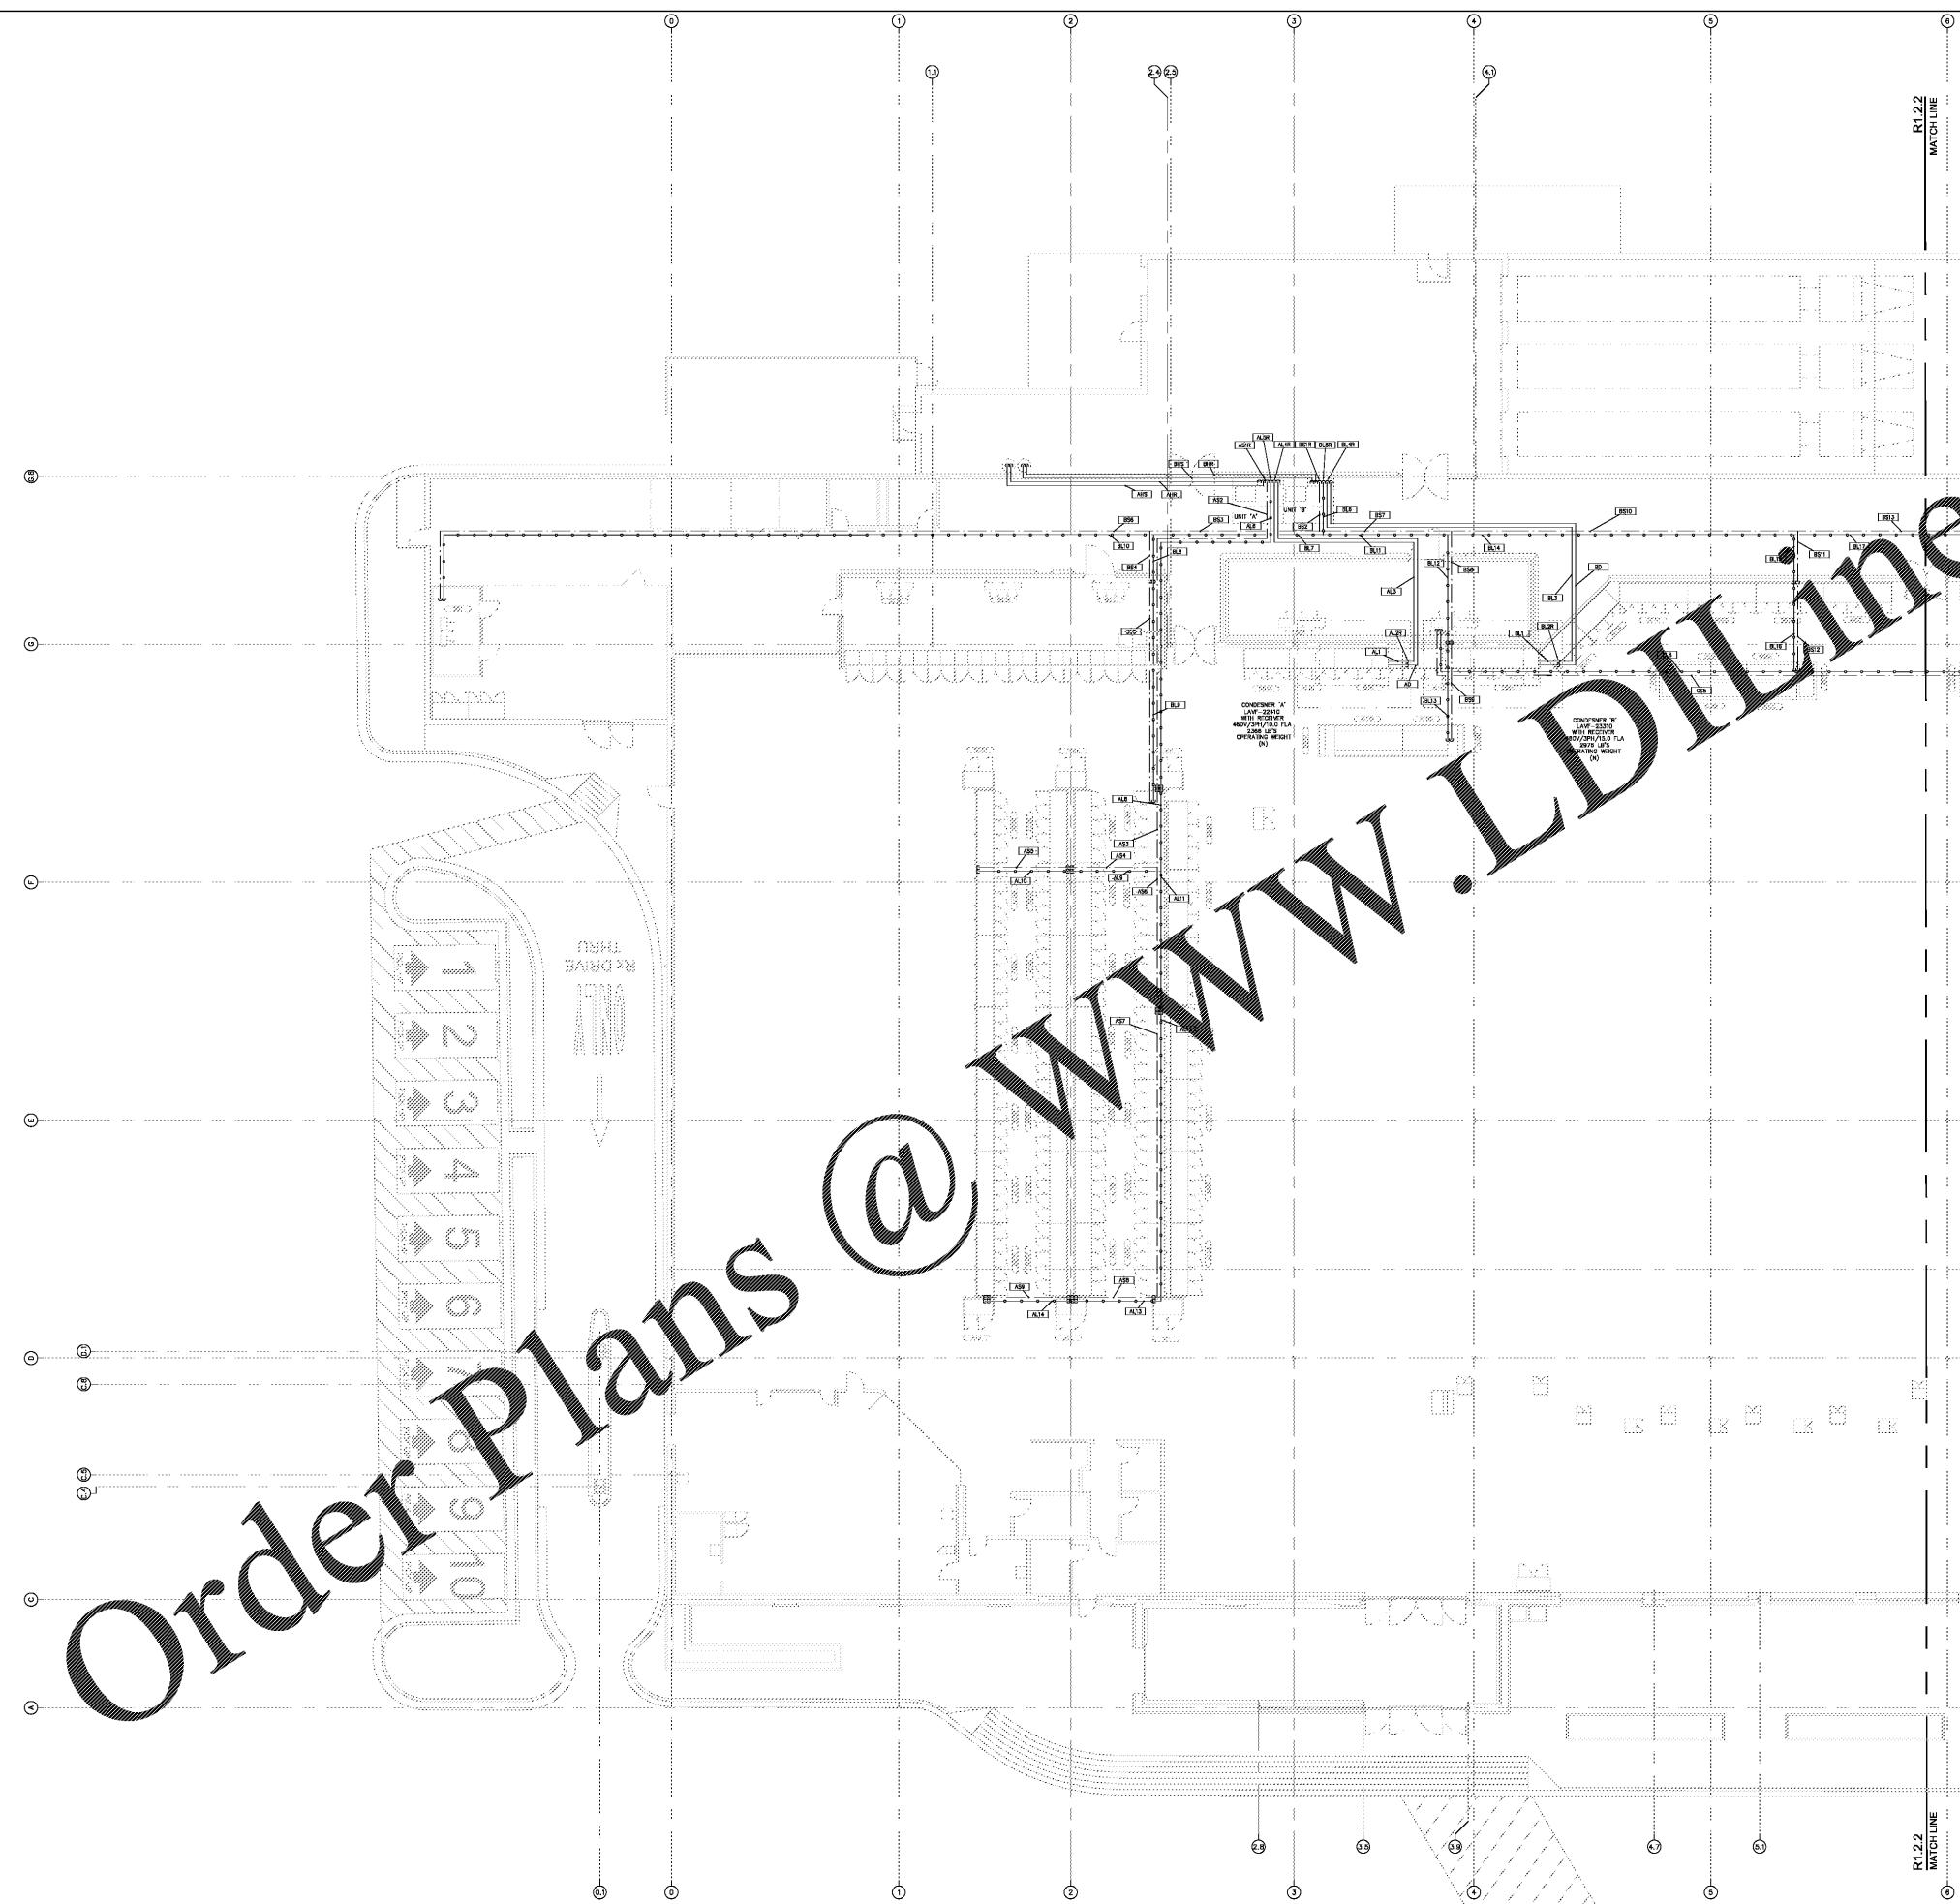

LEGEND: SYMBOLS AND NOTES APPLY TO BOTH R1.2.1 AND R1.2.2 SHEETS SOME ITEMS MAY NOT APPEAR ON THIS SHEET

LEGEND

- REFRIGERATION PIPING TO FLOW AT REST
- REFRIGERATION PIPING ICE
- REFRIGERATION PIPE UP
- LIQUID PIPING
- LIQUID PIPING - SUBCOOLED
- SECTION PIPING - FIRST SECTION GROUP
- PIPE SEGMENT DESIGNATION (SEE HELD FOR PIPE BEING SUBCOOLED)
- 'V' FOR REFRIG (OR BLANK FOR HORIZONTAL PIPING)
- SEGMENT NUMBER
- PIPING TYPE
'L' FOR DISCHARGE, 'Y' FOR HEAT RETAIN, '1' FOR LIQUID, 'A' 'F' FOR SECTION
- DISTRIBUTED UNIT DESIGNATION
- CIRCUIT DESIGNATION (SEE SHEETS 'R1.1' & 'R1.2' FOR RETROFIT UNIT & SUBCOOL)
- CIRCUIT LETTER FOR CIRCUITS WITH MORE THAN ONE
- CIRCUIT NUMBER
- DISTRIBUTED UNIT DESIGNATION

INSTALLATION NOTES:

- REFRIGERATION SHALL BE RESPONSIBLE FOR INSTALLATION OF ALL PIPING, INCLUDING CONDENSERS AND REFRIGERATION UNITS. ALL PIPING SHALL BE INSTALLED IN ACCORDANCE WITH THE REFRIGERATION MANUFACTURER'S RECOMMENDATIONS.
- REFRIGERATION PIPING TO BE INSTALLED BELOW THE ROOF.
- CONDENSER UNIT SHALL BE INSTALLED AS SHOWN ON THIS SHEET. CONDENSER UNIT SHALL BE INSTALLED WITH PROPER CLEARANCES AND SHALL BE INSTALLED WITH PROPER WEIGHTING.
- CONDENSER UNIT SHALL BE INSTALLED WITH PROPER CLEARANCES AND SHALL BE INSTALLED WITH PROPER WEIGHTING.

Kroger

KROGER STORE #473

2013 UNIVERSITY AVENUE
OXFORD, MISSISSIPPI 38655

A DEVELOPMENT OF THE KROGER COMPANY

naos

Naos Design Group Of Mississippi, PLLC.

MARC BREETZ, ARCHITECT

645 Lakeland East Drive
Suite 101
Flowood, Mississippi 39232
(p) 303.759.5777
(f) 720.360.4281

ARCHITECT OF RECORD

CDS

COMMERCIAL DESIGN SYSTEMS, INC.

13825 SW GALBREATH DRIVE
SHERWOOD, OREGON 97140
503.888.7800 (F)503.828.8822

INTERIOR DECOR

Pickering

Pickering Firm, Inc.
Architecture - Engineering
Planning - Surveying

8775 Lenox Center Court, Suite 300
Memphis, TN 38115
901.728.9819

ENGINEER OF RECORD:
STRUCTURAL
MECHANICAL
ELECTRICAL
CIVIL ENGINEER

AVSOFT

INFRASTRUCTURE

1820 CHESTNUT ROAD
CHRYSTAL, OH 43015
T: 503-670-3009


LOW VOLTAGE

telgian

TELGIAN CORPORATION
10230 SOUTH 56TH PLACE
SUITE 100
PHOENIX, AZ 85044
T: 6771.838.4428
HTTP://WWW.TELGIAN.COM
FIRE PROTECTION

ISSUE LOG

NO.	REV.	DESCRIPTION	DATE
1	-	PERMIT SET	12/05/18
2	-	BID SET	03/21/19

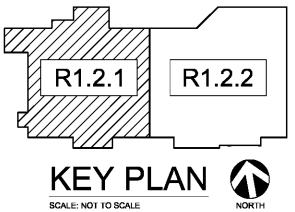

PARTIAL REFRIGERATION
01 MAIN PIPING PLAN WEST

SCALE: 3/32" = 1'-0"

JOB: 2018041
SCALE: 3/32" = 1'-0"

SHEET NO.

R1.2.1

PARTIAL REFRIGERATION
MAIN PIPING PLAN WEST

COPYRIGHT © 2018 NAOS DESIGN GROUP OF MISSISSIPPI, PLLC. THESE DRAWINGS OR PARTS THEREOF MAY NOT BE REPRODUCED IN ANY FORM OR BY ANY MEANS, ELECTRONIC OR MECHANICAL, WITHOUT PRIOR WRITTEN CONSENT FROM NAOS.