


Order Plans @

WWW.LDILine.com

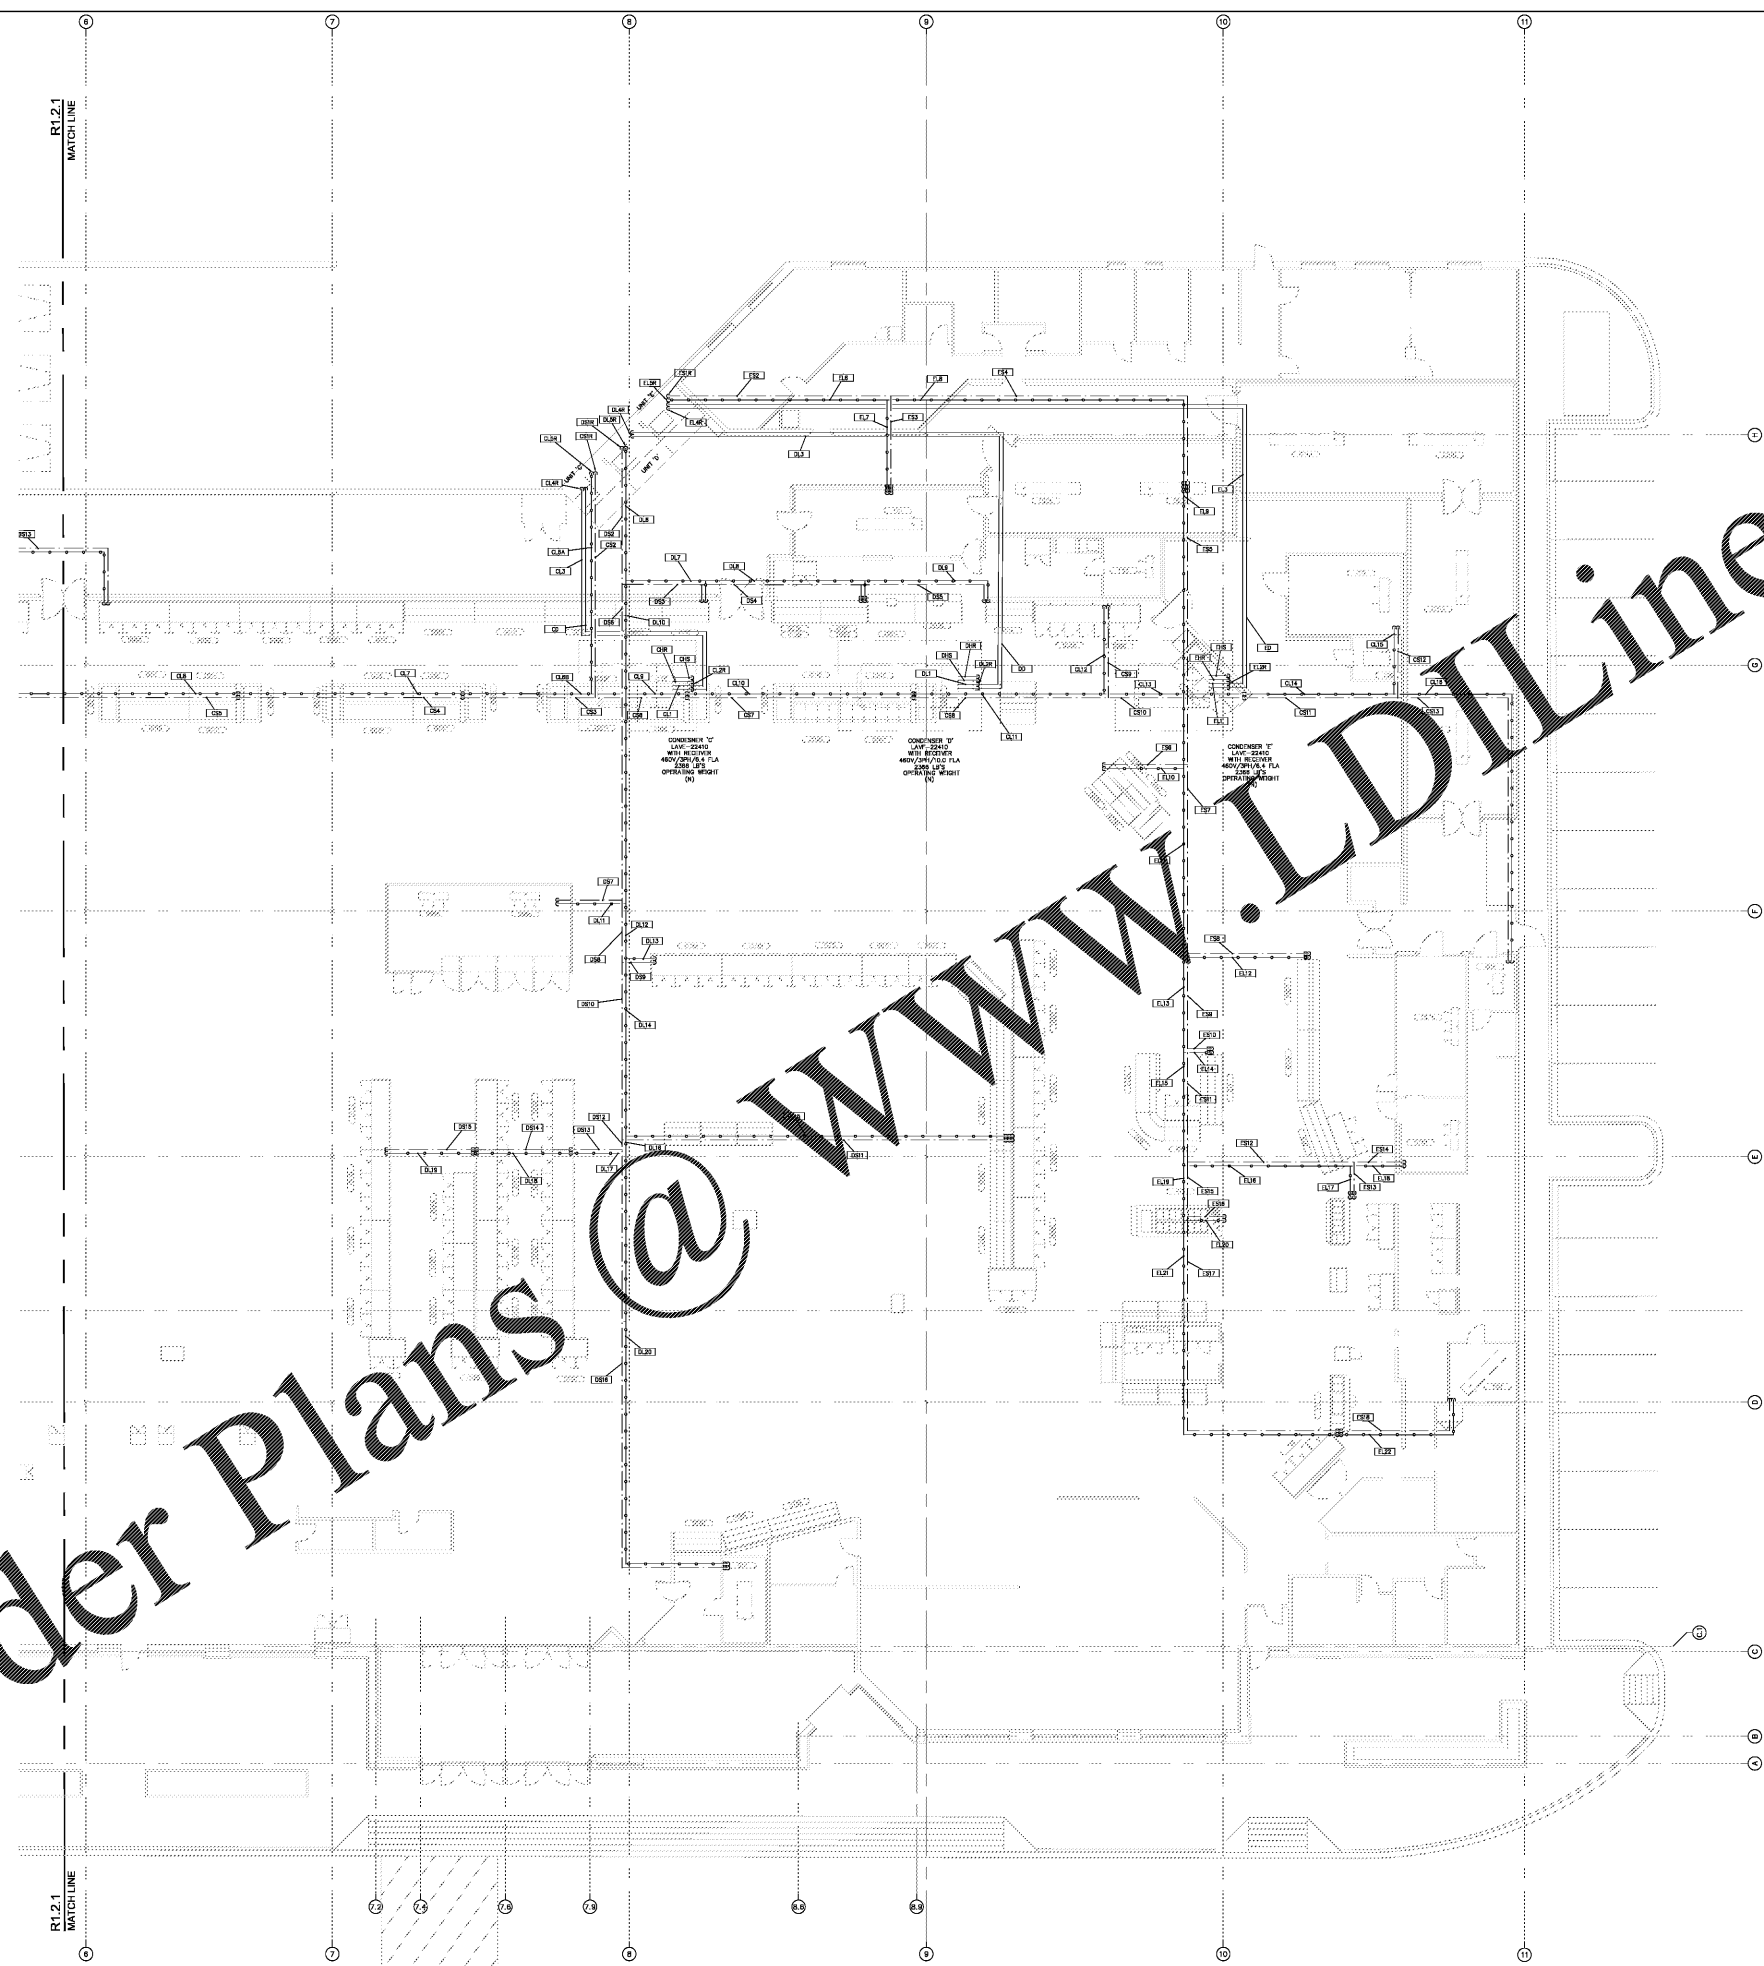

LEGEND
 > REFRIGERATION PIPING TO ELBOW AT REFRIG.
 < REFRIGERATION PIPING TO ELBOW AT REFRIG.
 ○ REFRIGERATION PIPE UP
 — LIQUID PIPING
 — LIQUID PIPING - SUBROUTED
 — SECTION PIPING - FIRST SECTION GROUP
 — PIPE SEGMENT DESIGNATION (SEE SHEET FOR PIPE BEING SUBROUTED)
 — 'Y' FOR RISER (OR BLANK FOR HORIZONTAL PIPING)
 — SEGMENT NUMBER
 — PIPING TYPE
 'C' FOR CONDENSER, 'V' FOR VALVE, 'R' FOR REFRIGERANT, 'L' FOR LIQUID, 'A' & 'F' FOR AIRFLOW
 — DISTRIBUTED UNIT DESIGNATION
 — CIRCUIT DESIGNATION (SEE SHEETS 'R1.1' & 'R1.2' FOR REFRIGERATION LAYOUT & SCHEDULE)
 — CIRCUIT LETTER (FOR CIRCUITS WITH MORE THAN ONE)
 — CIRCUIT NUMBER
 — DISTRIBUTED UNIT DESIGNATION

INSTALLATION NOTES:
 — REFRIGERATION CONTRACTOR RESPONSIBLE FOR INSTALLATION OF REFRIGERATION EQUIPMENT AND REFRIGERANT CHARGING AND REFRIGERANT MANUFACTURER RECOMMENDATIONS.
 — REFRIGERATION PIPING TO BE INSTALLED BELOW THE ROOF.
 — REFRIGERATION PIPING TO BE INSTALLED AS SHOWN ON THIS PLAN. ANY CHANGES TO BE MADE BETWEEN CONTRACTORS AND REFRIGERATION CONTRACTOR SHALL BE THE RESPONSIBILITY OF THE CONTRACTOR FOR INSTALLATION AND PROTECTION OF EXISTING WORK WITH MECHANICAL DRAWINGS.

Kroger
 KROGER
 STORE #473
 2013 UNIVERSITY AVENUE
 OXFORD, MISSISSIPPI 38655
 A DEVELOPMENT OF THE KROGER COMPANY

naos
 Naos Design Group Of Mississippi, PLLC.
 MARC BREETZ, ARCHITECT
 645 Lakeland East Drive
 Suite 101
 Flowood, Mississippi 39232
 (p) 303.759.5777
 (f) 720.360.4281
 ARCHITECT OF RECORD

CDS
 COMMERCIAL DESIGN SYSTEMS, INC.
 13825 SW GALBREATH DRIVE
 SHERWOOD, OREGON 97140
 503.885.7000 (P) 503.825.8922
 INTERIOR DECOR


Pickering
 Pickering Firm, Inc.
 Architecture - Engineering
 Planning - Surveying
 8775 Lenox Center Court, Suite 300
 Memphis, TN 38115
 901.728.9819
 ENGINEER OF RECORD:
 STRUCTURAL
 MECHANICAL
 ELECTRICAL
 CIVIL ENGINEER

AVSOFT
 INFRASTRUCTURE
 1820 CHESTNUT ROAD
 CHRYSTAL, OH 43015
 T: 503-570-3009
 LOW VOLTAGE

telgian
 TELGIAN CORPORATION
 10230 SOUTH 56TH PLACE
 SUITE 100
 PHOENIX, AZ 85044
 T: (677) 838-4428
 HTTP://WWW.TELGIAN.COM
 FIRE PROTECTION

ISSUE LOG

NO.	REV.	DESCRIPTION	DATE
1	-	PERMIT SET	12/05/18
2	-	BID SET	03/21/19

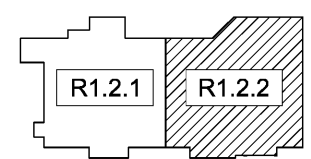

PARTIAL REFRIGERATION
01 MAIN PIPING PLAN EAST
 SCALE: 3/32" = 1'-0"

KEY PLAN
 SCALE: NOT TO SCALE
 NORTH

R1.2.2
 PARTIAL REFRIGERATION
 MAIN PIPING PLAN EAST

COPYRIGHT © 2018 NAOS DESIGN GROUP OF MISSISSIPPI, PLLC. THESE DRAWINGS, OR PARTS THEREOF, ARE NOT TO BE REPRODUCED IN ANY FORM, BY ANY METHOD, FOR ANY PURPOSE, WITHOUT PRIOR WRITTEN CONSENT FROM NAOS.