



KROGER  
STORE #473

2013 UNIVERSITY  
AVENUE  
OXFORD, MISSISSIPPI  
38655

A DEVELOPMENT OF  
THE KROGER COMPANY



Naos Design  
Group Of  
Mississippi,  
PLLC.

MARC BREETZ  
ARCHITECT

645 Lakeland East Drive  
Suite 101  
Flowood, Mississippi 39232  
(p) 303.759.5777  
(f) 720.360.4281

ARCHITECT OF RECORD



CDS  
COMMERCIAL DESIGN SYSTEMS,  
INC.

13825 SW GALBREATH DRIVE  
SHERWOOD, OREGON 97140  
503.855.7000 (p) 503.855.8902

INTERIOR DESIGN



Pickering Firm, Inc.  
Architecture - Engineering  
Planning - Surveying

6775 Lenox Center Court, Suite 300  
Memphis, TN 38115  
901.726.8810

ENGINEER OF RECORD:  
STRUCTURAL  
MECHANICAL  
ELECTRICAL  
CIVIL ENGINEER



V-SOFT  
INFRASTRUCTURE  
11280 CHESTER  
ROAD  
CINCINNATI, OH  
45246  
T: 513-950-3810  
LOW VOLTAGE



TELGIAN CORPORATION  
10230 SOUTH 50TH PLACE  
SUITE 100  
PHOENIX, AZ 85044  
T: (602) 836-4426  
HTTP://WWW.TELGIAN.COM  
FIRE PROTECTION

ISSUE LOG


NO.	REV.	DESCRIPTION	DATE
1	-	PERMIT SET	12/06/18
2	-	BID SET	03/21/19

JOB	SCALE
2019041	AS SHOWN

SHEET NO.

P1.2.1  
PARTIAL WATER PLAN WEST

Copyright © 2018 Naos Design Group of Mississippi, PLLC. All rights reserved. No part of this document may be reproduced, stored in a retrieval system, or transmitted in any form or by any means, electronic, mechanical, photocopying, recording, or by any information storage and retrieval system, without prior written consent from Naos Design Group of Mississippi, PLLC.

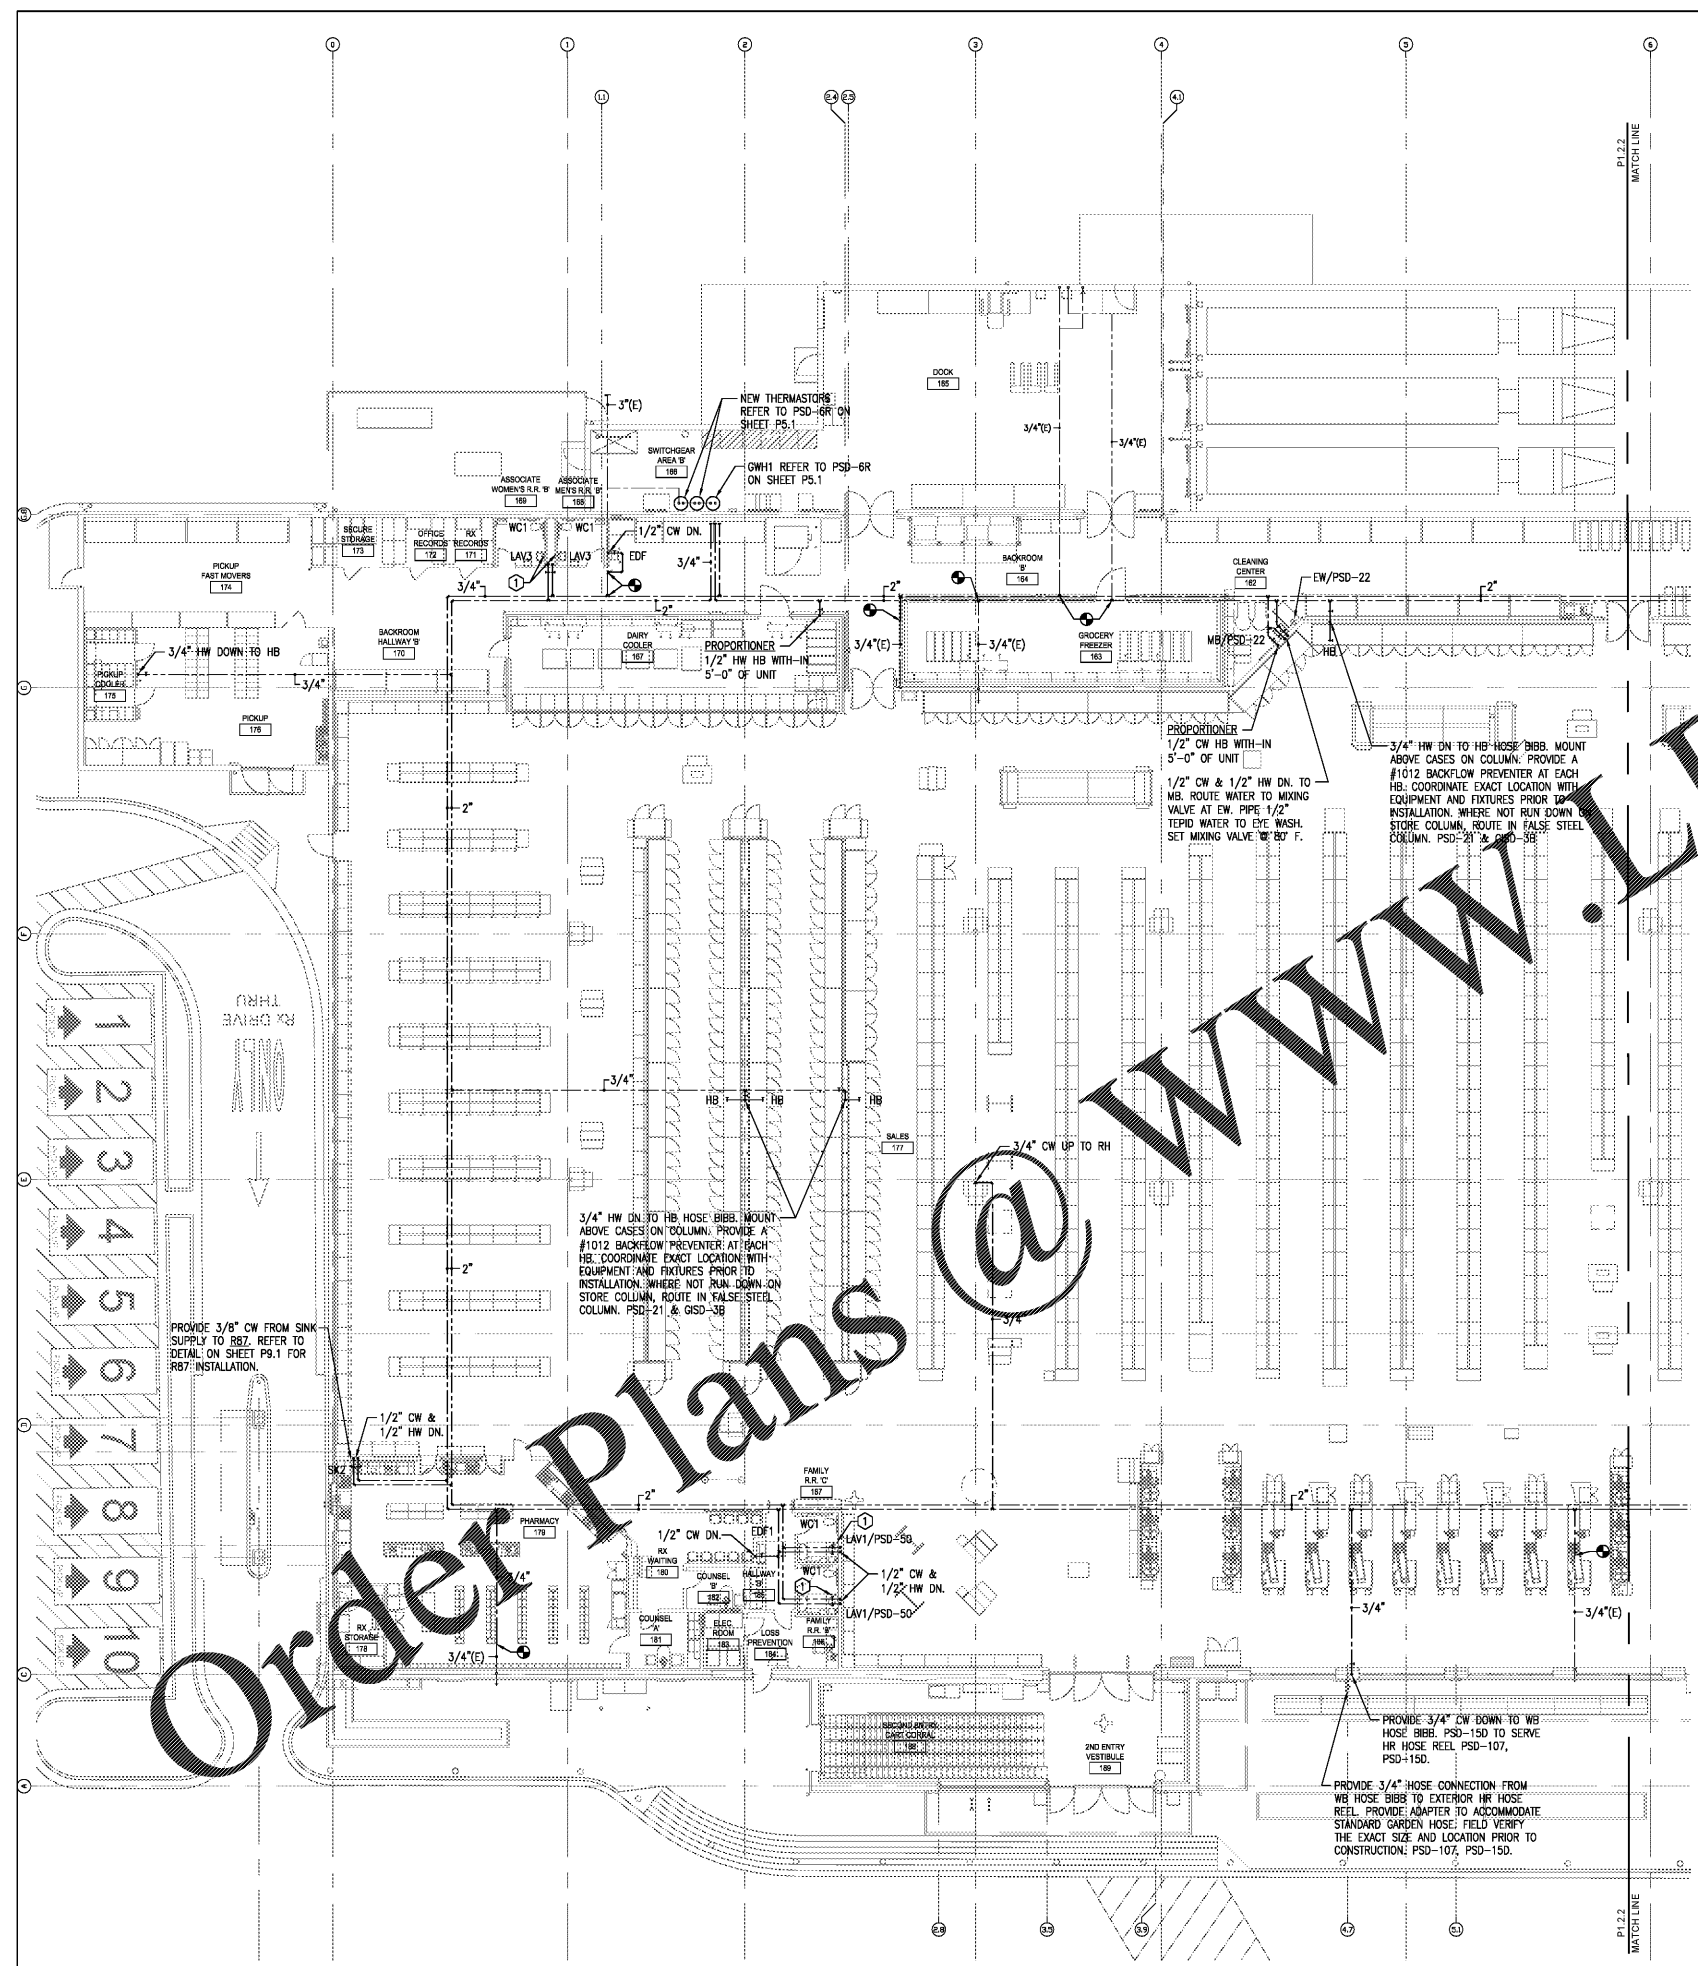

KEYNOTES:  
① HW HOSE BIBB 18" AFF BELOW LAVATORY.

PIPING IN THE PRODUCE AND MEAT PREP AREAS TO BE RUN IN THE WARM SPACE OUTSIDE THE INSULATED PANELS AND STUBBED THROUGH THE WALLS OR PENNELED TO STUBS, ETC.

WATER PIPING IS PROHIBITED FROM BEING INSTALLED IN A COOLER OR FREEZER.


NO SURFACE MOUNTED WATER LINES PERMITTED EXPOSED IN THE PRODUCE AND MEAT PREP AREA ROOMS.

PSD#  
NOTE: SK# REFERS TO THE PLUMBING FIXTURE CALLOUT AS NOTED IN PLUMBING FIXTURE SCHEDULE ON SHEET P6.1. PSD# REFERS TO INSTALLATION DETAILS OF THE FIXTURE AS NOTED ON SHEETS P5.1 AND 5.2.

ALL PREP AREAS VISIBLE TO CUSTOMERS ARE TO HAVE UTILITIES RUNS (E.G. CONDUITS, PIPES) CONCEALED INSIDE THE NEAREST WALL UP TO THEIR CONNECTION POINT. NO EXTERIOR MOUNTED RUNS ARE ACCEPTABLE (E.G. ANSEL CONNECTIONS).

REMOVE, RELOCATE OR MODIFY ALL UTILITIES ABOVE CEILINGS BEING DEMOLISHED. THIS INCLUDES (BUT IS NOT LIMITED TO) HVAC DUCTS; ELECTRICAL AND LOW VOLTAGE WIRING AND CONDUITS; REFRIGERATION, SPRINKLER, WASTE, VENT, AND WATER PIPING.

Order Plans @ WWW.LDILLING.COM

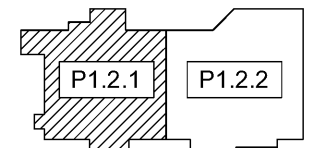

01 PARTIAL WATER PLAN WEST  
SCALE: 3/32" = 1'-0"

KEY PLAN  
SCALE: NOT TO SCALE