



KROGER  
STORE #473

2013 UNIVERSITY AVENUE  
OXFORD, MISSISSIPPI 38655

A DEVELOPMENT OF THE KROGER COMPANY

**naos**  
Naos Design Group Of Mississippi, PLLC.

MARC BREETZ, ARCHITECT  
645 Lakeland East Drive Suite 101  
Flowood, Mississippi 39232  
(601) 303.759.5777  
(601) 720.360.4281

ARCHITECT OF RECORD



CDS  
COMMERCIAL DESIGN SYSTEMS, INC.  
13825 SW GALLERIE DRIVE  
SHERWOOD, OREGON 97140  
503.855.7000 (P) 503.855.8002

INTERIOR DESIGNER



Pickering Firm, Inc.  
Architecture - Engineering  
Planning - Surveying  
6775 Lenox Center Court, Suite 300  
Memphis, TN 38115  
(901) 728.0810

ENGINEER OF RECORD:  
STRUCTURAL  
MECHANICAL  
ELECTRICAL  
CIVIL ENGINEER



V-SOFT  
INFRASTRUCTURE  
11280 CHESTER ROAD  
CINCINNATI, OH 45240  
T: 513-950-3810  
LOW VOLTAGE



TELGIAN CORPORATION  
10230 SOUTH 50TH PLACE  
SUITE 100  
PHOENIX, AZ 85044  
T: (602) 835-4426  
HTTP://WWW.TELGIAN.COM  
FIRE PROTECTION


ISSUE LOG

NO.	REV.	DESCRIPTION	DATE
1	-	PERMIT SET	12/05/18
2	-	BID SET	03/21/19

JOB	SCALE
2019041	AS SHOWN

SHEET NO.

**P1.2.2**  
PARTIAL WATER PLAN EAST

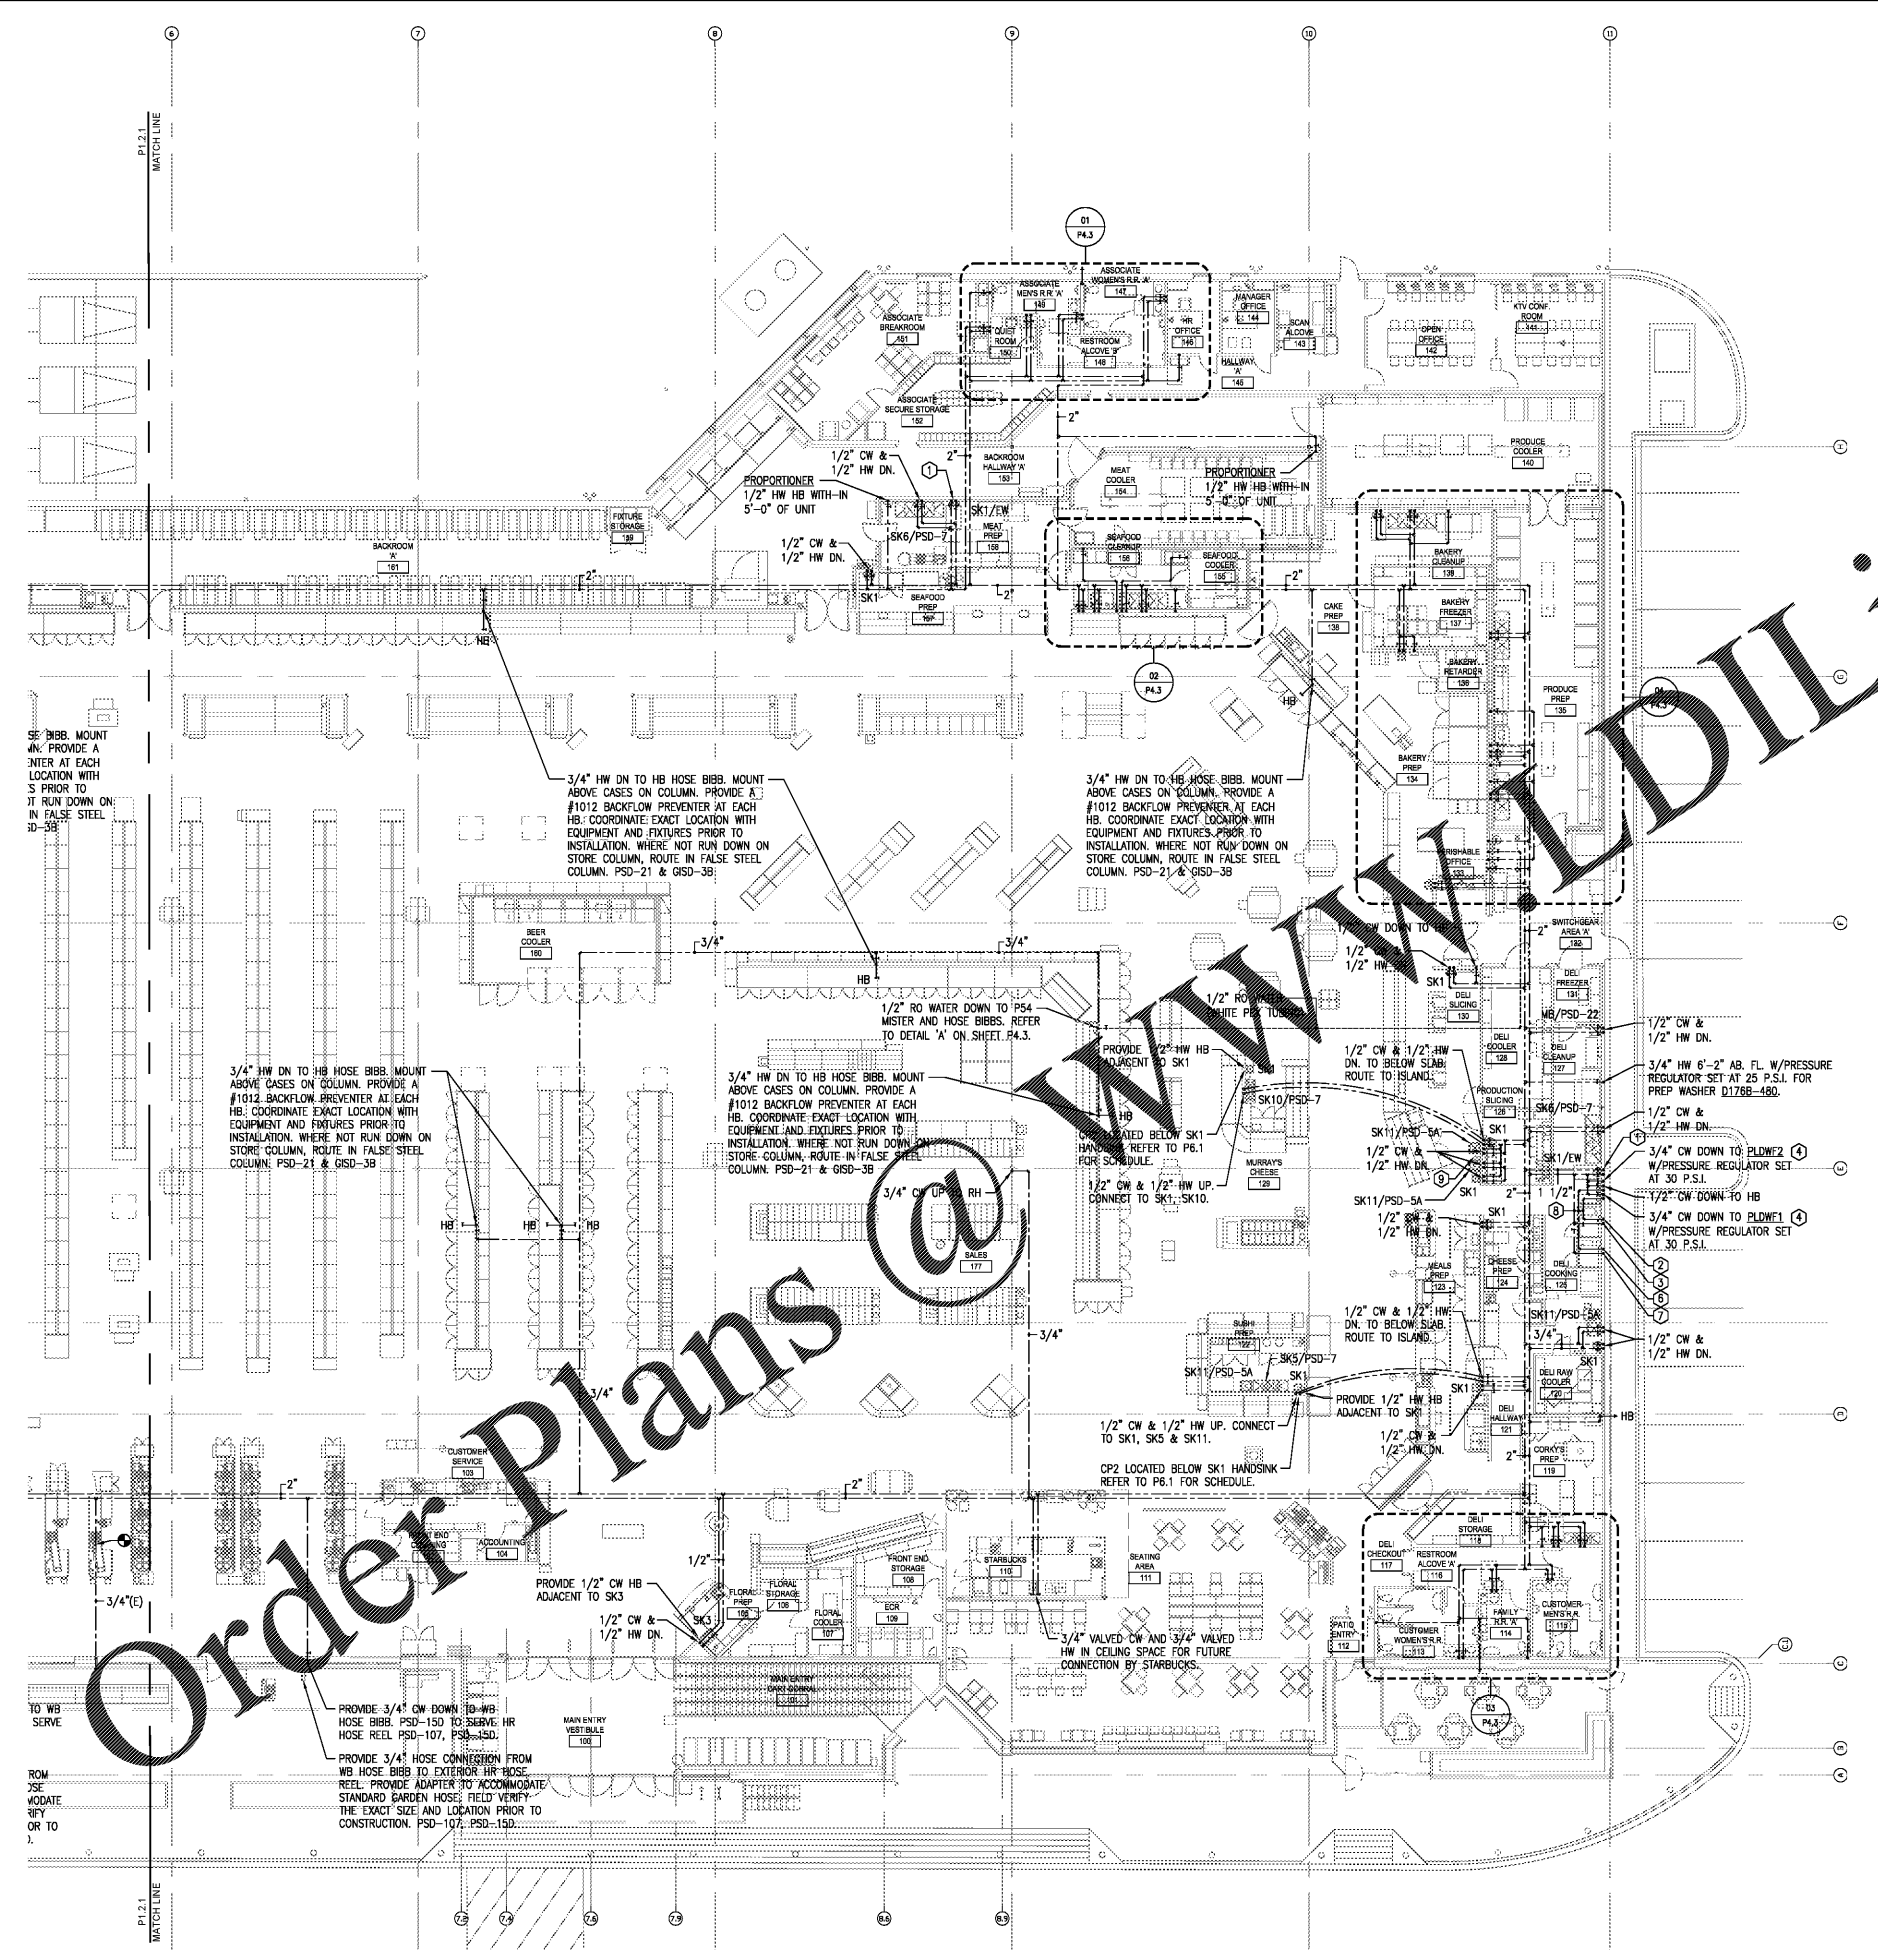

- KEYNOTES:**
- 1/2" CW & 1/2" HW DN TO SK1. PIPE 1/2" TEPID WATER TO EYE WASH. SET MIXING VALVE @ 80' F.
  - 3/4" CW DOWN WITH FILTER AND PRESSURE REGULATOR SET AT 45 P.S.I. TO COMBI OVEN DISCS-480. REFER TO PSD-23A. ROUTE TIGHT TO WALL.
  - 3/4" CW 6"-2" AB. FL. W/PRESSURE REGULATOR SET AT 25 P.S.I. TO COMBI OVEN DISCS-480. REFER TO PSD-23A. ROUTE TIGHT TO WALL.
  - MOUNT FILTER ON WALL. REFER TO PSD-23A.
  - 3/4" CW DOWN TO FILTER SYSTEM W/PRESSURE REGULATOR SET AT 30 P.S.I.
  - 3/4" CW DOWN WITH FILTER AND PRESSURE REGULATOR SET AT 45 P.S.I. TO COMBI OVEN DISCS-480. REFER TO PSD-23A. ROUTE TIGHT TO WALL.
  - 3/4" CW 6"-2" AB. FL. W/PRESSURE REGULATOR SET AT 25 P.S.I. TO COMBI OVEN DISCS-480. REFER TO PSD-23A. ROUTE TIGHT TO WALL.
  - SHOWN FOR CLARITY. ROUTE TIGHT TO WALL UNDER HOOD.
  - HW HOSE BIBB 18" AFF.

PIPING IN THE PRODUCE AND MEAT PREP AREAS TO BE RUN IN THE WARM SPACE OUTSIDE OF THE INSULATED PANELS AND STUBBED THROUGH THE WALLS FOR CONNECTION TO SINKS, ETC.


WATER PIPING IS PROHIBITED FROM BEING INSTALLED IN A COOLER OR FREEZER.

NO SURFACE MOUNTED WATER LINES PERMITTED EXPOSED IN THE PRODUCE AND MEAT PREP AREA ROOMS.

SK#/PSD# NOTE: SK# REFERS TO THE PLUMBING FIXTURE CALLOUT AS NOTED IN PLUMBING FIXTURE SCHEDULE ON SHEET P6.1. PSD# REFERS TO INSTALLATION DETAILS OF THE FIXTURE AS NOTED ON SHEETS P5.1 AND 5.2.

ALL PREP AREAS VISIBLE TO CUSTOMERS ARE TO HAVE UTILITIES RUNS (E.G. CONDUITS, PIPES) CONCEALED INSIDE THE NEAREST WALL UP TO THEIR CONNECTION POINT. NO EXTERIOR MOUNTED RUNS ARE ACCEPTABLE (E.G. ANSEL CONNECTIONS).

REMOVE, RELOCATE OR MODIFY ALL UTILITIES ABOVE CEILINGS BEING DEMOLISHED. THIS INCLUDES (BUT IS NOT LIMITED TO) HVAC DUCTS, ELECTRICAL AND LOW VOLTAGE WIRING AND CONDUITS; REFRIGERATION, SPRINKLER, WASTE, VENT, AND WATER PIPING.

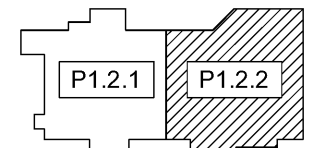

01 PARTIAL WATER PLAN EAST  
SCALE: 3/32" = 1'-0"

KEY PLAN  
SCALE: NOT TO SCALE

Order Plans @ [www.dilinc.com](http://www.dilinc.com)