



KROGER
STORE #473

2013 UNIVERSITY
AVENUE
OXFORD, MISSISSIPPI
38655

A DEVELOPMENT OF
THE KROGER COMPANY

naos
Naos Design
Group Of
Mississippi,
PLLC.

MARC BREETZ,
ARCHITECT

645 Lakeland East Drive
Suite 101
Flowood, Mississippi 39232
(p) 303.759.5777
(f) 720.360.4281

ARCHITECT OF RECORD



CDS
COMMERCIAL DESIGN SYSTEMS,
INC.
13825 SW GALLEREA DRIVE
SHERWOOD, OREGON 97140
503.855.7000 (p) 503.825.8202
INTERIOR DECOR



Pickering
Pickering Firm, Inc.
Architecture - Engineering
Planning - Surveying

6775 Lenox Center Court, Suite 300
Memphis, TN 38115
901.726.8810
ENGINEER OF RECORD:
STRUCTURAL
MECHANICAL
ELECTRICAL
CIVIL ENGINEER



V-SOFT
INFRASTRUCTURE
11280 CHESTER
ROAD
CINCINNATI, OH
45246
T: 513-950-3810
LOW VOLTAGE



telgian
TELGIAN CORPORATION
10230 SOUTH 50TH PLACE
SUITE 100
PHOENIX, AZ 85044
T: (602) 938-4426
HTTP://WWW.TELGIAN.COM
FIRE PROTECTION

ISSUE LOG


NO.	REV.	DESCRIPTION	DATE
1	-	PERMIT SET	12/05/18
2	-	BID SET	03/21/19

JOB: 2018041 SCALE: AS SHOWN

SHEET NO.


P4.1
ENLARGED PLUMBING PLAN

COPYRIGHT © 2018 NAOS DESIGN GROUP OF MISSISSIPPI, PLLC. THESE DRAWINGS OR PARTS THEREOF MAY NOT BE REPRODUCED, COPIED, EITHER WHOLLY OR IN PART, OR FOR ANY PURPOSE, WITHOUT PRIOR WRITTEN CONSENT FROM NAOS.

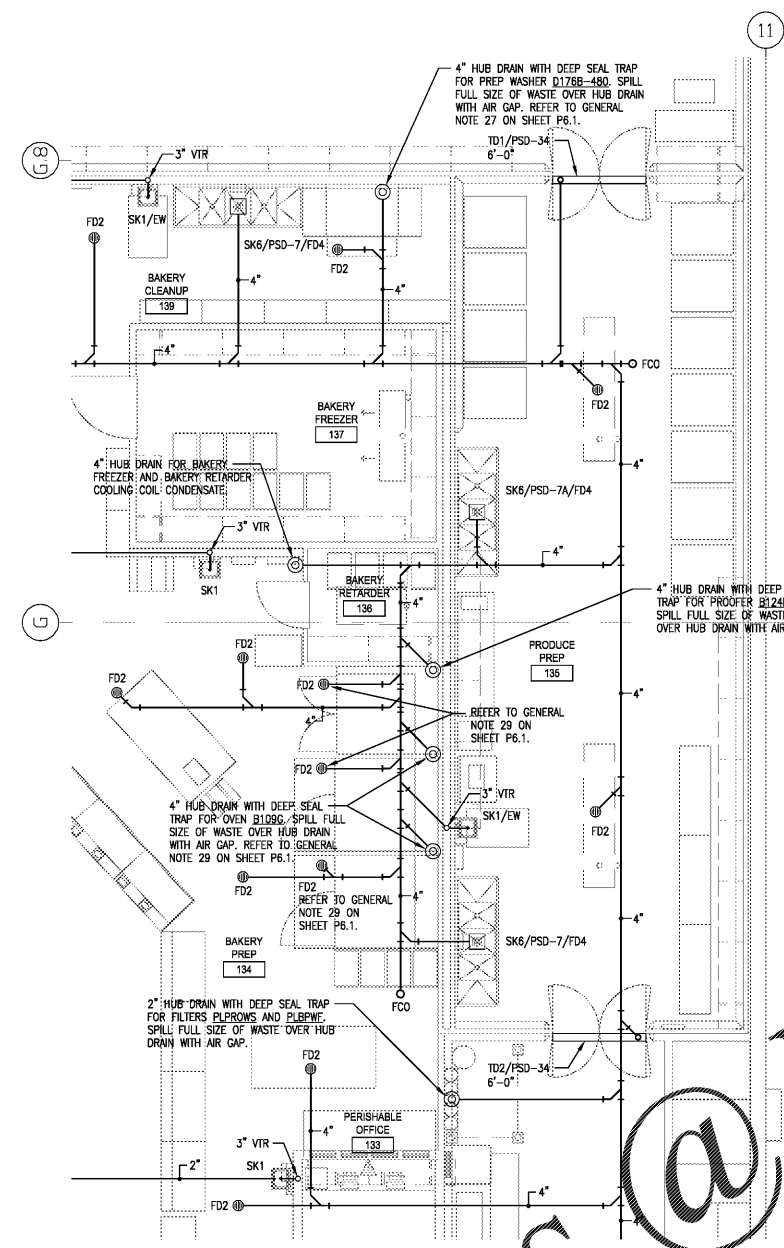

01 ENLARGED WASTE AND VENT PLAN

SCALE: 1/4" = 1'-0"

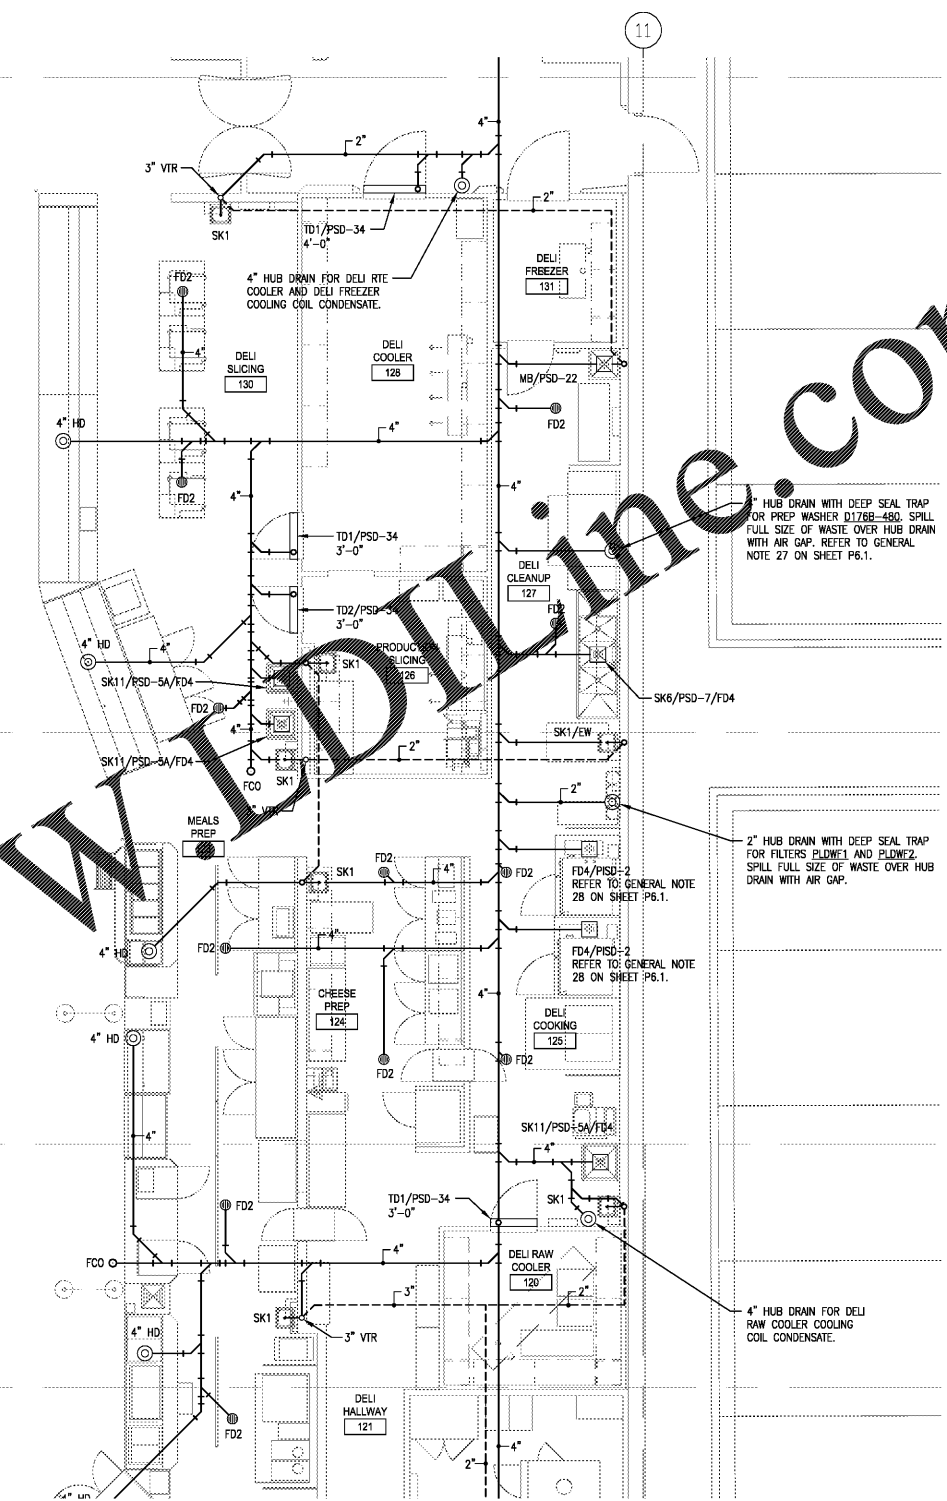

02 ENLARGED WASTE AND VENT PLAN

SCALE: 1/4" = 1'-0"

Order Plans @

WWW.WJDLINE.COM