




01 ENLARGED WASTE AND VENT PLAN  
SCALE: 1/4" = 1'-0"

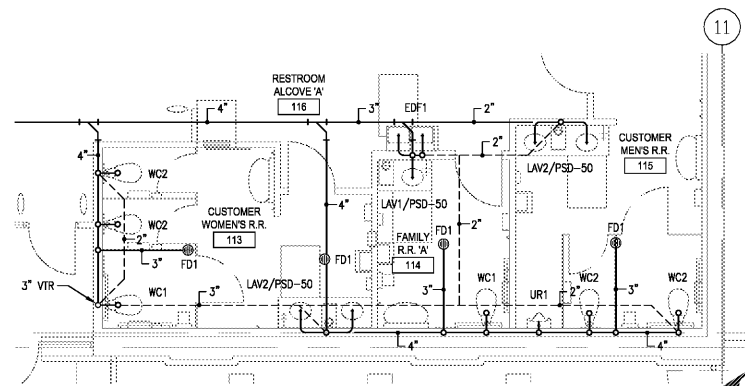

02 ENLARGED WASTE AND VENT PLAN  
SCALE: 1/4" = 1'-0"

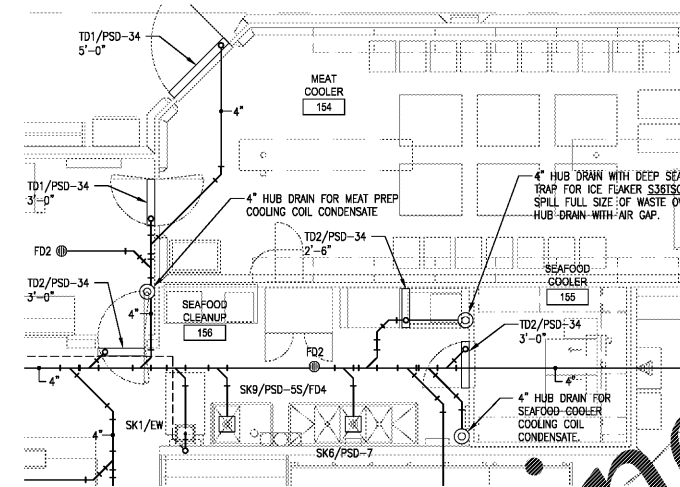

03 ENLARGED WASTE AND VENT PLAN  
SCALE: 1/4" = 1'-0"

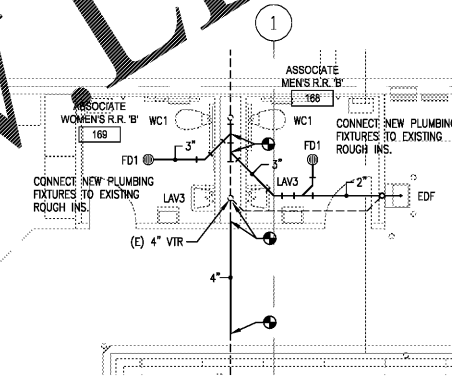

04 ENLARGED WASTE AND VENT PLAN  
SCALE: 1/4" = 1'-0"

Order Plans @ [www.LDILine.com](http://www.LDILine.com)



KROGER  
STORE #473

2013 UNIVERSITY AVENUE  
OXFORD, MISSISSIPPI 38655

A DEVELOPMENT OF  
THE KROGER COMPANY

**naos**  
Naos Design  
Group Of  
Mississippi,  
PLLC.

MARC BREETZ,  
ARCHITECT

645 Lakeland East Drive  
Suite 101  
Flowood, Mississippi 39232  
(p) 303.759.5777  
(f) 720.360.4281

ARCHITECT OF RECORD



CDS  
COMMERCIAL DESIGN SYSTEMS,  
INC.

13825 SW GALBREATH DRIVE  
SHERWOOD, OREGON 97140  
503.855.7000 (P) 503.855.8902

INTERIOR DECOR



Pickering Firm, Inc.  
Architecture - Engineering  
Planning - Surveying

6775 Lenox Center Court, Suite 300  
Memphis, TN 38115  
901.726.8810

ENGINEER OF RECORD:  
STRUCTURAL  
MECHANICAL  
ELECTRICAL  
CIVIL ENGINEER



V-SOFT  
INFRASTRUCTURE  
11280 CHESTER ROAD  
CINCINNATI, OH 45246  
T: 513-950-3819  
LOW VOLTAGE



TELGIAN CORPORATION  
10230 SOUTH 50TH PLACE  
SUITE 100  
PHOENIX, AZ 85044  
T: (602) 836-4426  
HTTP://WWW.TELGIAN.COM  
FIRE PROTECTION

ISSUE LOG

NO.	REV.	DESCRIPTION	DATE
1	-	PERMIT SET	12/05/18
2	-	BID SET	03/21/19

JOB: 2018041 SCALE: AS SHOWN

SHEET NO.

**P4.2**  
ENLARGED PLUMBING PLAN

COPYRIGHT © 2018 NAOS DESIGN GROUP OF MISSISSIPPI, PLLC. THESE DRAWINGS OR PARTS THEREOF MAY NOT BE REPRODUCED, COPIED, EITHER WHOLLY OR IN PART, FOR ANY PURPOSE, WITHOUT PRIOR WRITTEN CONSENT FROM NAOS.