


01 ENLARGED PLUMBING DIMENSION PLAN
SCALE: 1/4" = 1'-0"

PLUMBING DIMENSIONS ARE PROVIDED AS A COURTESY TO THE CONTRACTOR. THE CONTRACTOR SHALL FIELD VERIFY ALL DIMENSIONS TO ENSURE ACCURACY. DIMENSIONS CAN VARY BASED ON COLUMN LOCATIONS, DRAIN LOCATIONS, EQUIPMENT VARIATIONS, AND OTHER FACTORS. DO NOT RELY SOLELY ON THE DIMENSIONS GIVEN ON THE DRAWINGS.

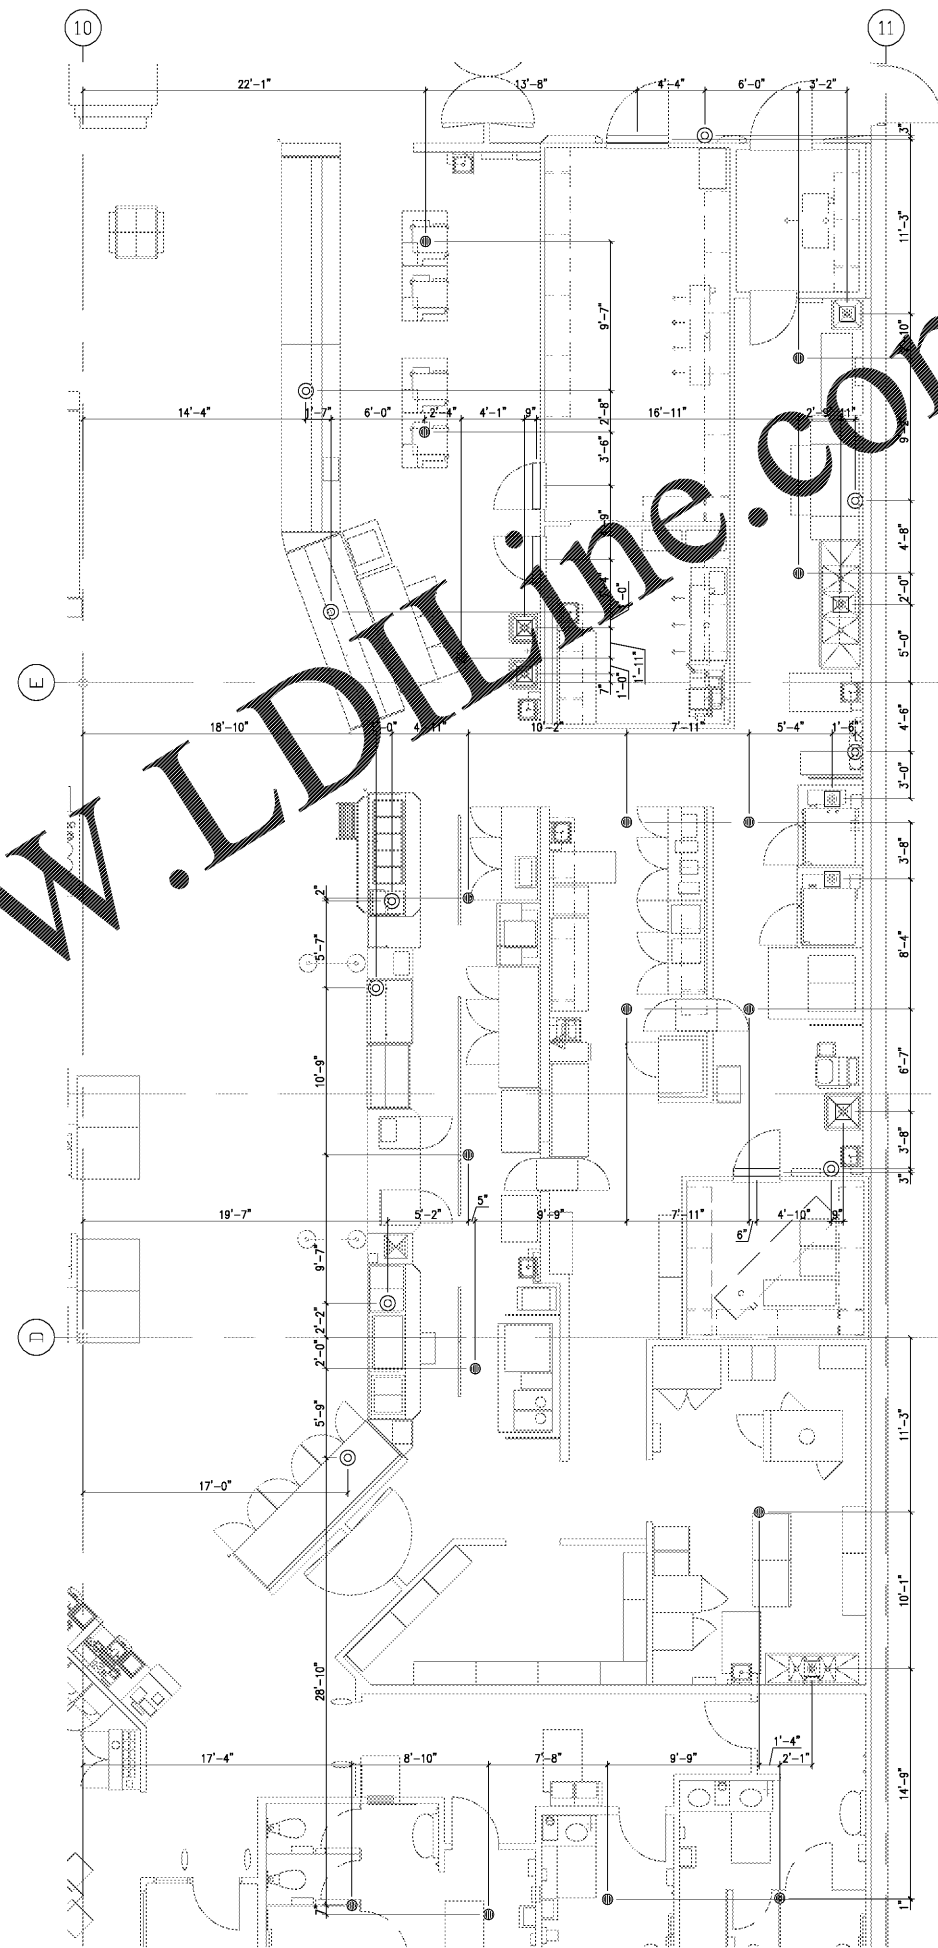

02 ENLARGED PLUMBING DIMENSION PLAN
SCALE: 1/4" = 1'-0"

Order Plans

WWW.LDILLINE.COM



KROGER
STORE #473
2013 UNIVERSITY AVENUE
OXFORD, MISSISSIPPI 38655
A DEVELOPMENT OF THE KROGER COMPANY




Naos Design Group Of Mississippi, PLLC.
MARC BREETZ, ARCHITECT
645 Lakeland East Drive Suite 101
Flowood, Mississippi 39232
(p) 303.759.5777 (f) 720.360.4281
ARCHITECT OF RECORD



CDS COMMERCIAL DESIGN SYSTEMS, INC.
13825 SW GALBREATH DRIVE SHERWOOD, OREGON 97140
503.855.7000 (p) 503.825.8902
INTERIOR DECOR



Pickering Firm, Inc. Architecture - Engineering Planning - Surveying
6775 Lenox Center Court, Suite 300 Memphis, TN 38115 901.726.8816
ENGINEER OF RECORD: STRUCTURAL MECHANICAL ELECTRICAL CIVIL ENGINEER



V-SOFT INFRASTRUCTURE
11280 CHESTER ROAD CINCINNATI, OH 45248
T: 513-998-3819 LOW VOLTAGE



TELGIAN CORPORATION
10230 SOUTH 50TH PLACE SUITE 100 PHOENIX, AZ 85044
T: (677) 836-4426 HTTP://WWW.TELGIAN.COM FIRE PROTECTION

ISSUE LOG

NO.	REV.	DESCRIPTION	DATE
1	-	PERMIT SET	12/05/18
2	-	BID SET	03/21/19

JOB: 2018041 SCALE: AS SHOWN

SHEET NO. P4.4
ENLARGED PLUMBING PLAN

COPYRIGHT © 2018 NAOS DESIGN GROUP OF MISSISSIPPI, PLLC. THESE DRAWINGS OR PARTS THEREOF MAY NOT BE REPRODUCED, COPIED, EITHER WHOLLY OR IN PART, FOR ANY PURPOSE, WITHOUT PRIOR WRITTEN CONSENT FROM NAOS.