



KROGER
STORE #473

2013 UNIVERSITY AVENUE
OXFORD, MISSISSIPPI 38655

A DEVELOPMENT OF
THE KROGER COMPANY



Naos Design
Group Of
Mississippi,
PLLC.

MARC BREETZ,
ARCHITECT

645 Lakeland East Drive
Suite 101
Flowood, Mississippi 39232
(p) 303.759.5777
(f) 720.360.4281

ARCHITECT OF RECORD



CDS
COMMERCIAL DESIGN SYSTEM
INC.
13825 SW GALLEATH DRIVE
SHERWOOD, OREGON 97140
503.885.7000 (P) 503.625.8002

INTERIOR DECOR



Pickering Firm, Inc.
Architecture Engineering
Planning Surveying
6775 Lenox Center Court, Suite 300
Memphis, TN 38115
901.726.0810

ENGINEER OF RECORD
STRUCTURAL
MECHANICAL
ELECTRICAL
CIVIL ENGINEER



V-SOFT
INFRASTRUCTURE
11200 CHESTER ROAD
CINCINNATI, OH 45248
T: 513-505-3819
LOW VOLTAGE



TELGIAN CORPORATION
10230 SOUTH 50TH PLACE
SUITE 100
PHOENIX, AZ 85044
T: (877) 835-4426
HTTP://WWW.TELGIAN.COM
FIRE PROTECTION

ISSUE LOG


NO.	REV.	DESCRIPTION	DAT
1	-	PERMITS SET	12/06/
2	-	BID SET	03/21/

SCALE
20' = 1" AS SHOWN

SHEET NO.

M1.2.2
PARTIAL HVAC ROOF PLAN EAST

NO RTH

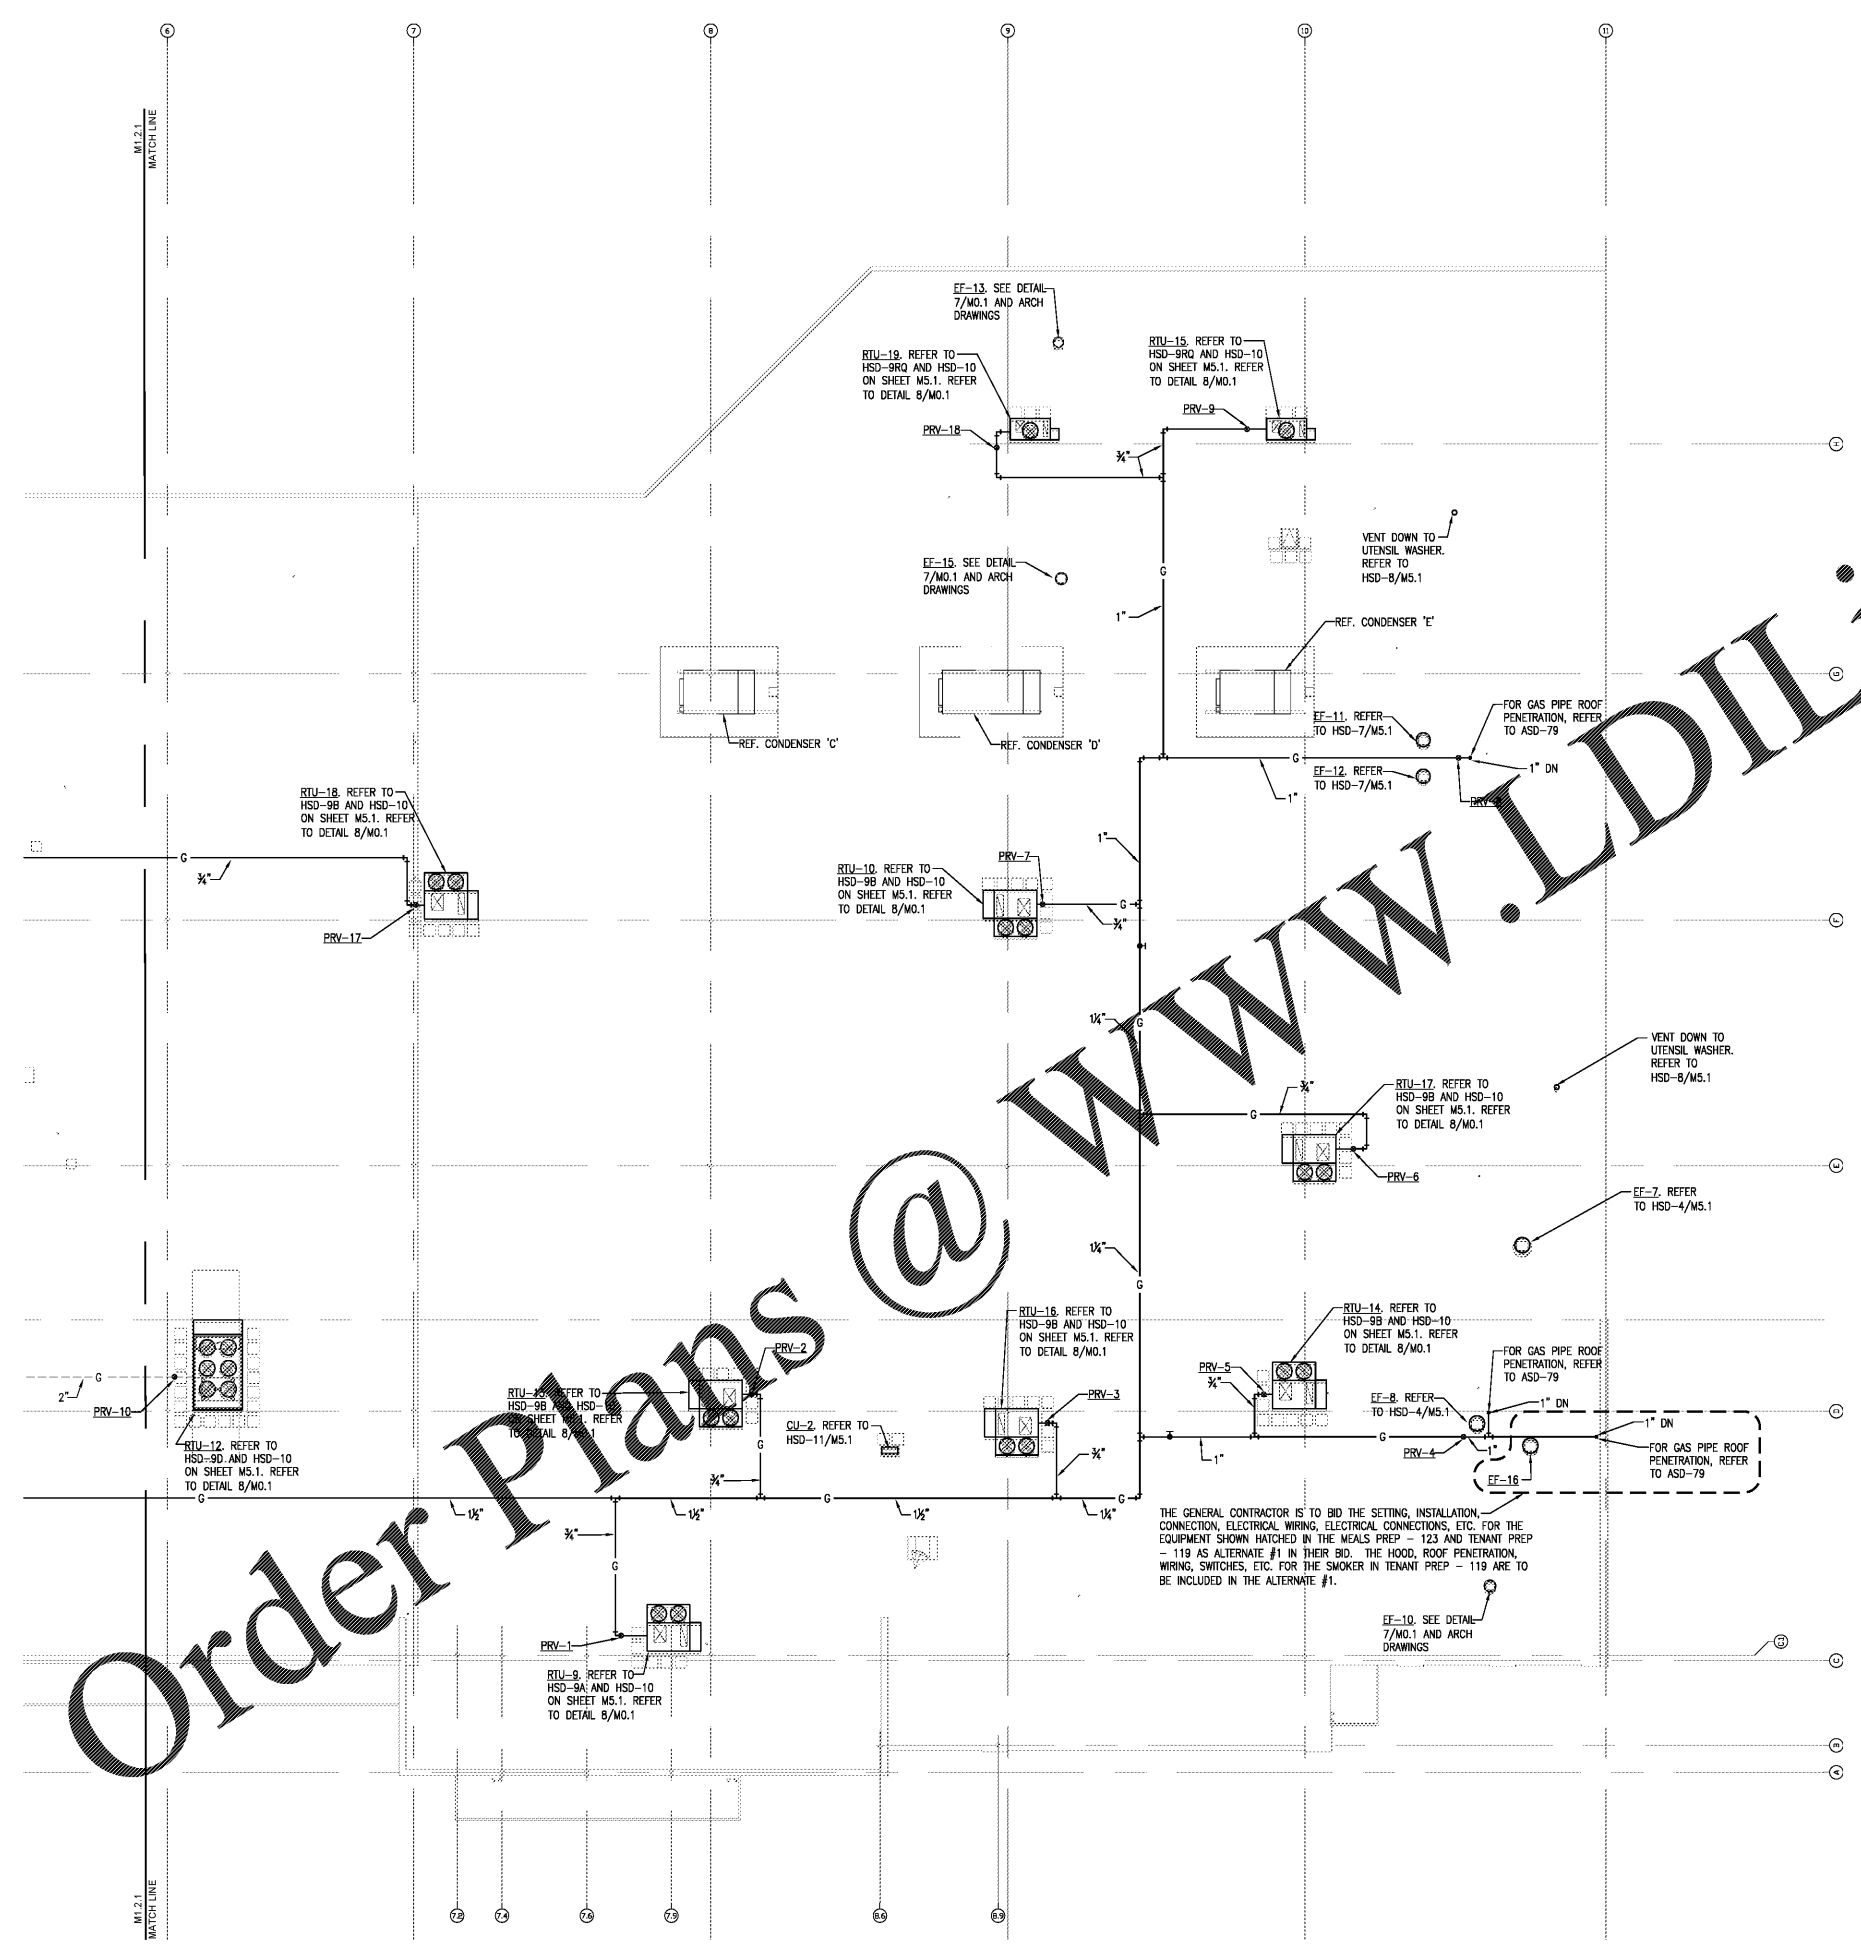

Order Plans @ WWW.LDILine.com

01 PARTIAL HVAC ROOF PLAN EAST

SCALE: 3/32" = 1'-0"



KEY PLAN

SCALE: NOT TO SCALE



NO RTH