



**NOTE:**  
 ALL WATER PIPING WITH NO FITTINGS TO BE ROUTED BELOW SLAB. DO NOT EMBED PIPING IN SLAB. PIPING MUST BE INSULATED AS SPECIFIED.

**GENERAL NOTES:**


1. OFFSET TO MATCH LOCATION AND INVERT OF CIVIL UTILITY LINES. MAKE FINAL CONNECTIONS. NOTIFY OWNER IF SITE UTILITY STUBS ARE NOT WITHIN 20 FEET OF THIS BUILDING STUB-OUT. REFER TO CIVIL DRAWINGS FOR CONTINUATION OF SERVICES.
2. TO PREVENT PIPING FROM RATTLING IN WALLS, INSULATE ALL PENETRATIONS THRU STUDS. SUPPORT PIPING USING UNISTRUT, CLAMPS STACKFIX AND/OR POSIFIX.
3. THE CONTRACTOR SHALL COORDINATE CONSTRUCTION WITH THE GENERAL CONTRACTOR AS WELL AS ALL OTHER DISCIPLINES OF JOB SITE.
4. THE CONTRACTOR SHALL BE RESPONSIBLE FOR THE REMOVAL AND DISPOSAL OF ALL WASTE MATERIALS GENERATED DURING CONSTRUCTION.
5. SEE SHEET P1.01 FOR LEGEND AND FIXTURE DESIGNATIONS.

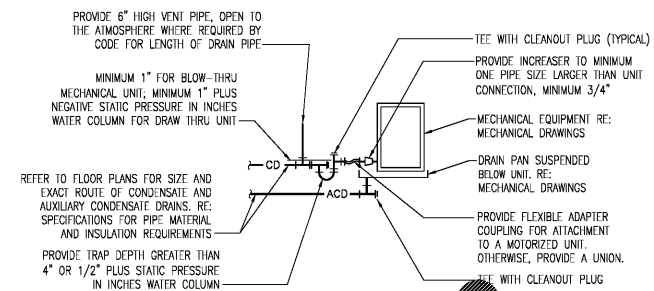


PIPING ARRANGEMENT SHOWN IS SCHEMATIC. ADJUST AS REQUIRED TO SUIT ACTUAL INSTALLATION CONDITIONS. REFER TO ALL CODES FOR INDIRECT DRAIN REQUIREMENTS.  
**3 AIR HANDLING UNIT CONDENSATE DRAIN**  
 NOT TO SCALE

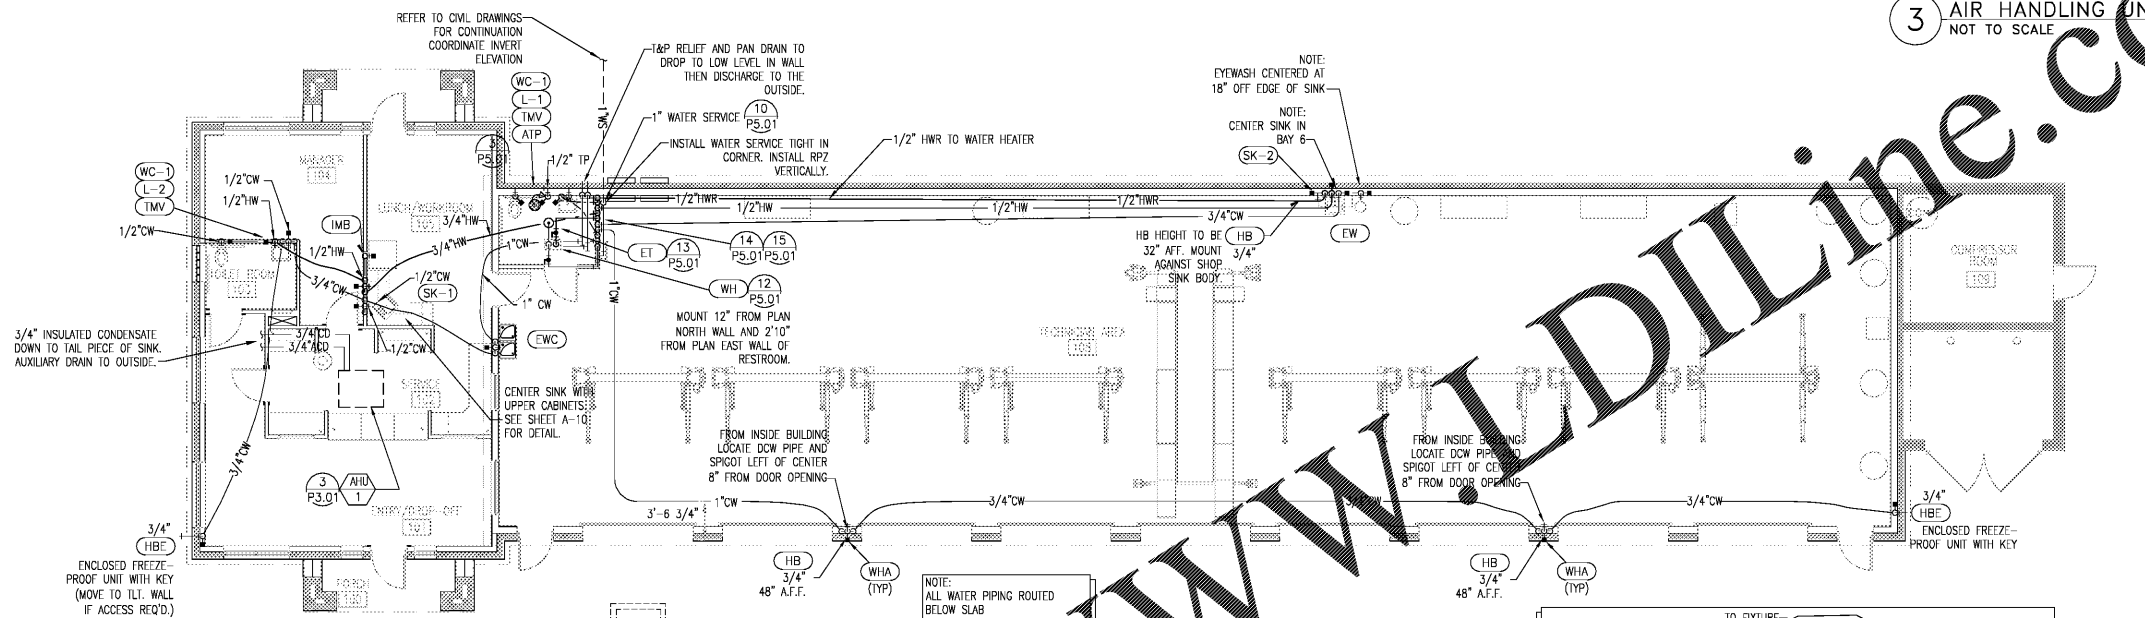

**1 WATER FLOOR PLAN**  
 SCALE: 1/8"=1'-0"

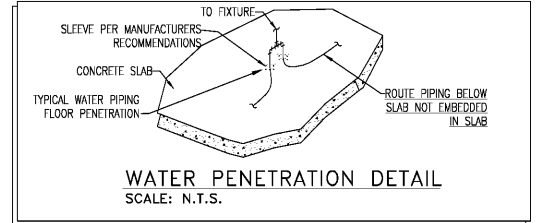

**WATER PENETRATION DETAIL**  
 SCALE: N.T.S.

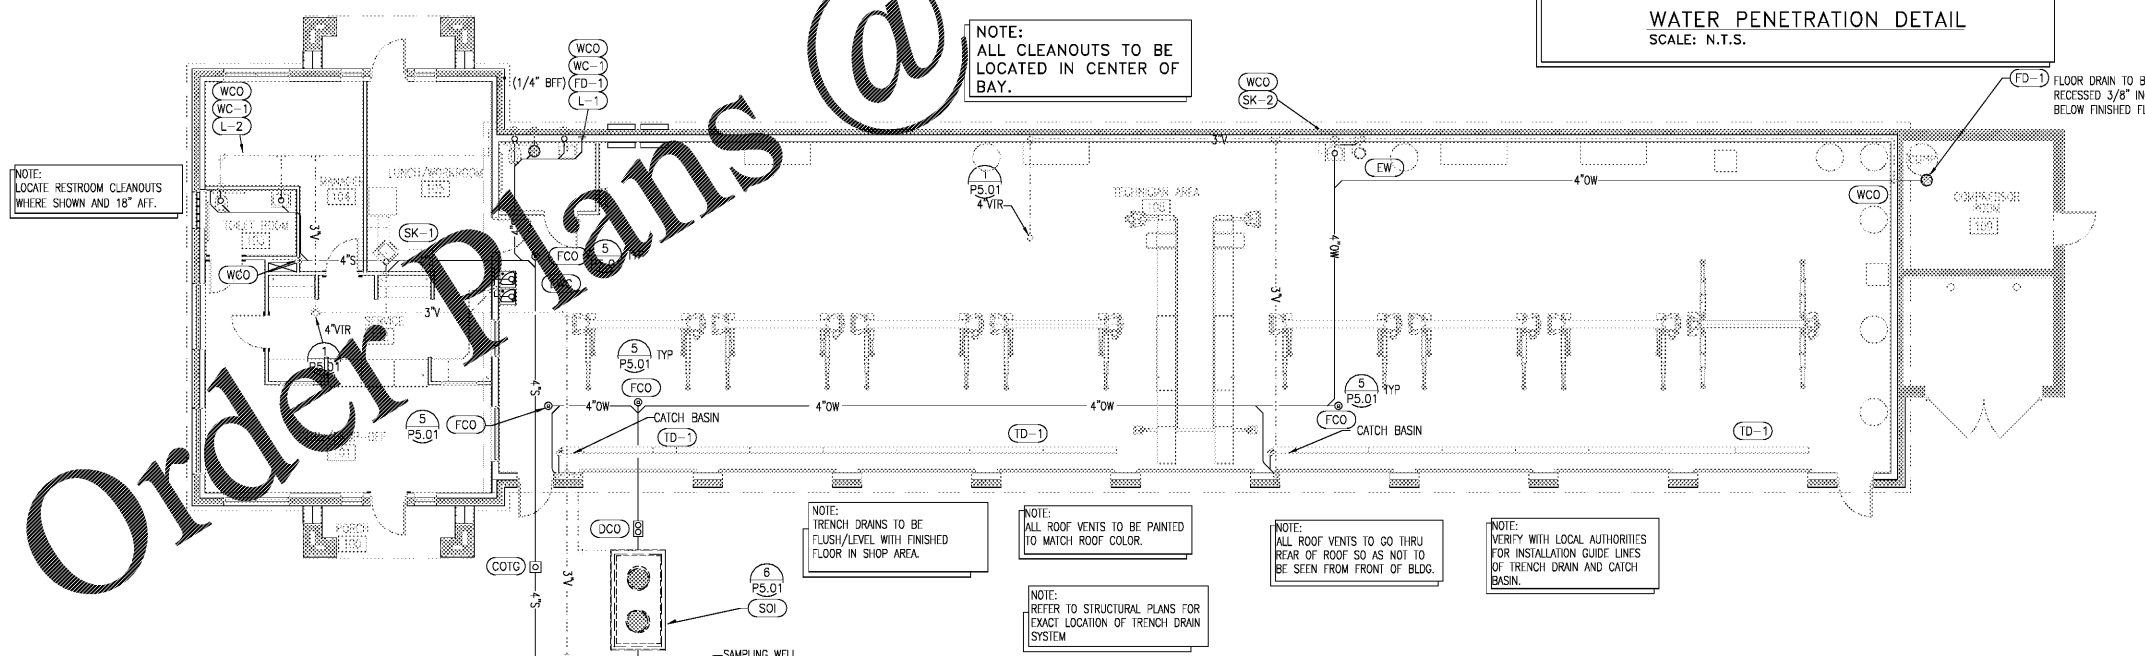

**2 SANITARY FLOOR PLAN**  
 SCALE: 1/8"=1'-0"

Order Plans @

**NOTE:**  
 ALL CLEANOUTS TO BE LOCATED IN CENTER OF BAY.



**Christian Brothers Automotive**  
 5650 Peachtree Industrial Boulevard  
 Norcross, GA 30071



10/19/2018  
 Date

**Revisions**  
 2/28/18 - Prototype Update

Project No. 18-042  
 Drawn By:  
 Date: 10/19/18

Sheet Title:  
**PLUMBING FLOOR PLANS**

Drawing No.  
**P-3.01**  
 LH9N-09-2018

