

STEWART + REINDERSMA
ARCHITECTURE, PLLC
5450 E. High Street, Suite 200
Phoenix, Arizona 85054
P: 480.515.5123
www.sra360.com

Christian Brothers
Automotive
5650 Peachtree Industrial Boulevard
Norcross, GA 30071

Christian Brothers
Automotive
17725 Katy Freeway, St. 200
Houston, TX 77064



10/19/2018
Date

Revisions

2/28/18 - Prototype Update

Project No. 18-042

Drawn By:

Date: 10/19/18

Sheet Title:

PLUMBING RISER DETAILS

Drawing No.


P-4.01

LH9N-09-2018

WASTE & VENT RISER 1
NO SCALE

OILY WASTE RISER 2
NO SCALE

3 NATURAL GAS RISER
NO SCALE

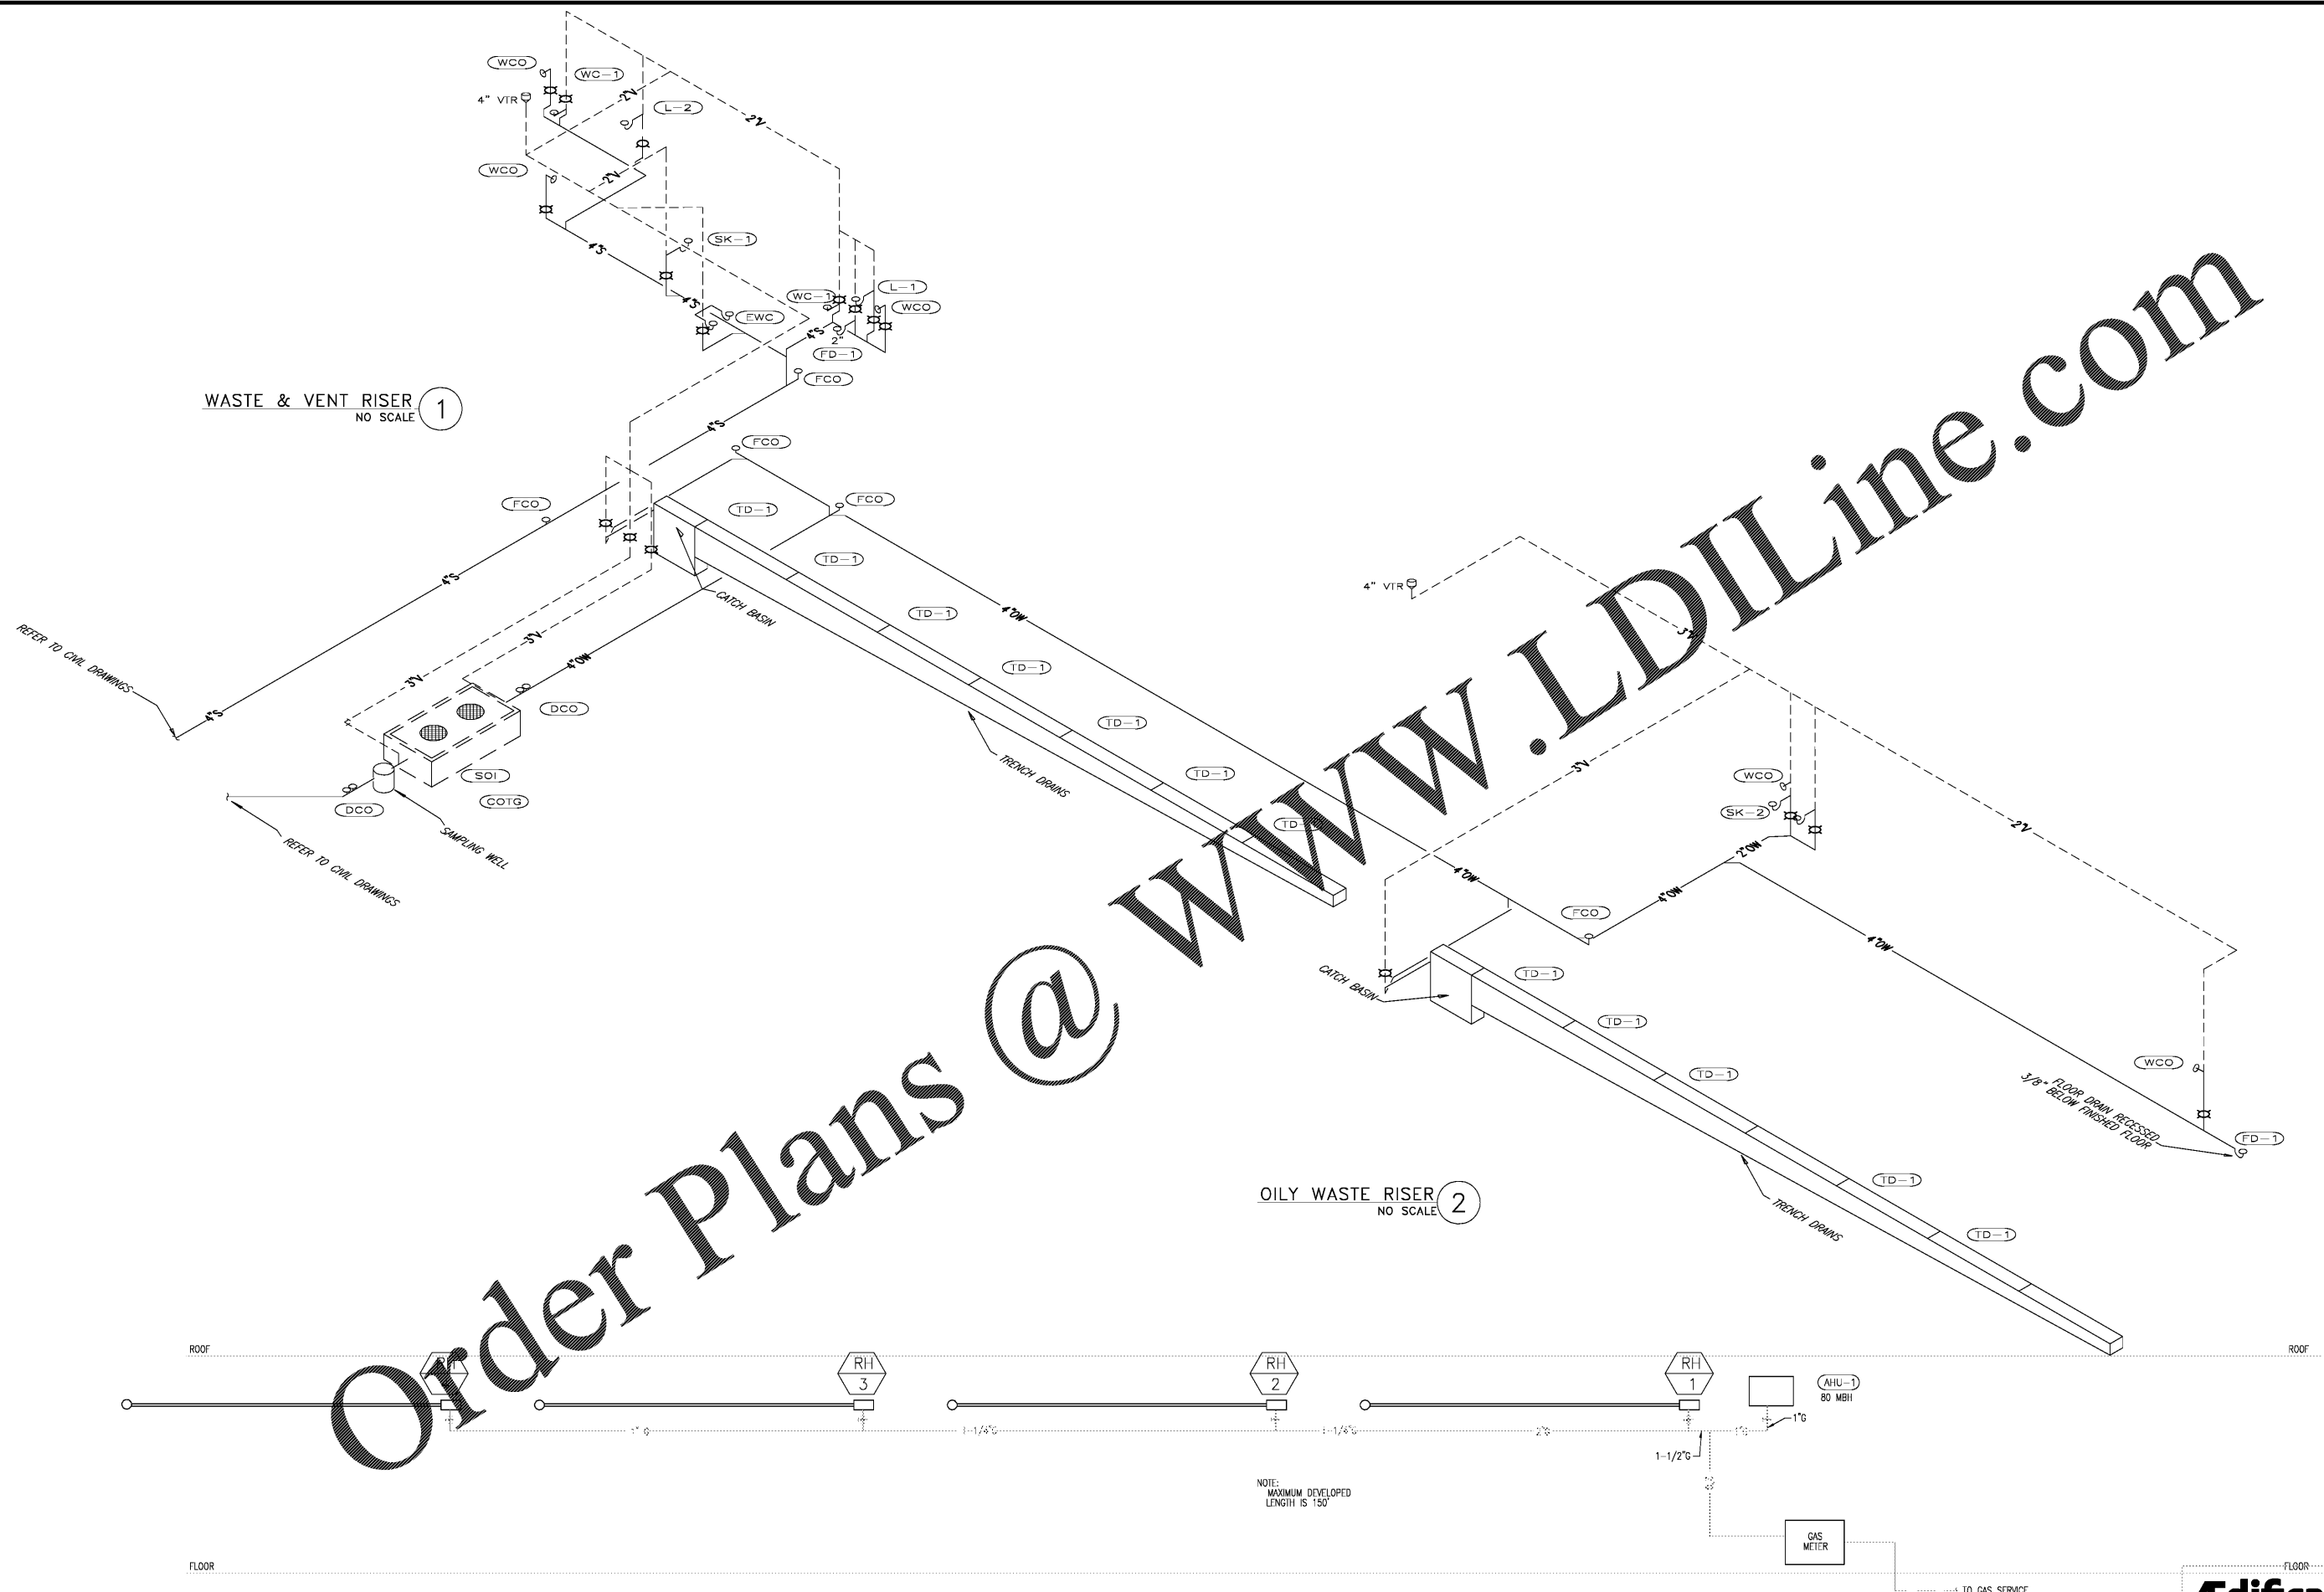

Order Plans @ www.LDILine.com

Adifica case
engineering

798 Main Court
St. Louis, MO 63126
T 636.349.1690
F 636.349.1730
adificacase.com

mechanical
electrical
plumbing
fire protection
structural

CERTIFICATE OF AUTHORITY NO. PE996438