


Order Plans @ [www.LDILine.com](http://www.LDILine.com)

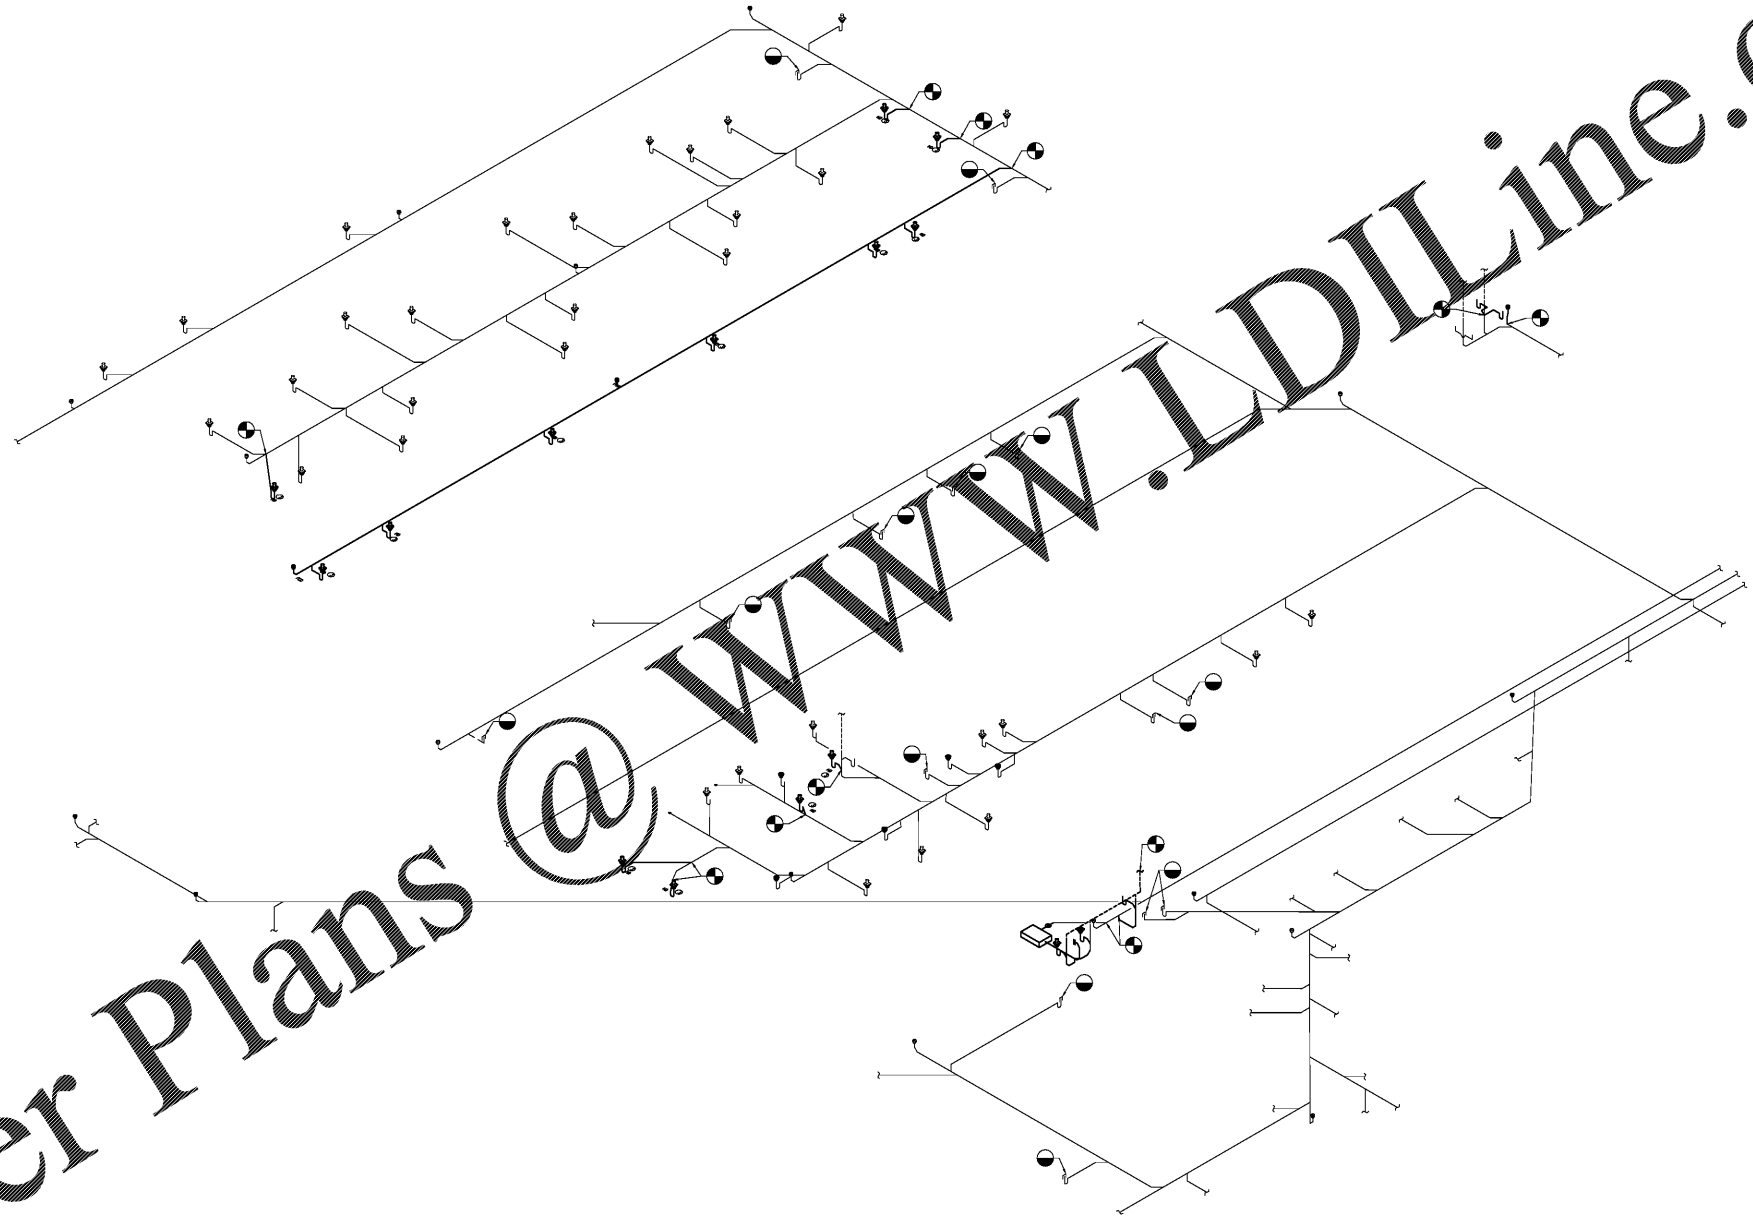

WASTE RISER NTS

**INTERPLAN**  
ARCHITECTURE  
ENGINEERING  
INTERIOR DESIGN  
PROJECT MANAGEMENT

404 COURTLAND STREET  
SUITE 100  
ORLANDO, FLORIDA 32804  
PH 407.645.3200  
FX 407.629.9124

SEAL:

THIS DOCUMENT IS NOT  
FOR REGULATORY  
APPROVAL, PERMITTING,  
OR CONSTRUCTION.

A WITHIN THE WALLS REMODEL FOR:  
**KROGER STORE # 478 - MARIETTA - GA**  
3162 JOHNSON FERRY RD.,  
MARIETTA, GA 30062



GENERAL OFFICE  
FACILITY ENGINEERING  
674 W. 1ST STREET, SUITE 400  
PH 402.762.7600 FAX 402.762.4000

NO. DATE REVISIONS  
REVISIONS  
PROJECT NO: 2019-0125  
DATE: 03.18.2019

**P3.1**  
PLUMBING RISER

CHECKED: PD DRAWN: RCH

COPYRIGHT © 2019 INTERPLAN, LLC. ALL RIGHTS RESERVED. THIS DOCUMENT IS THE PROPERTY OF INTERPLAN, LLC. NO PART OF THIS DOCUMENT IS TO BE REPRODUCED, COPIED, OR TRANSMITTED IN ANY FORM OR BY ANY MEANS, WITHOUT THE WRITTEN PERMISSION OF INTERPLAN, LLC.