


Order Plans @

WWW.LDILine.com

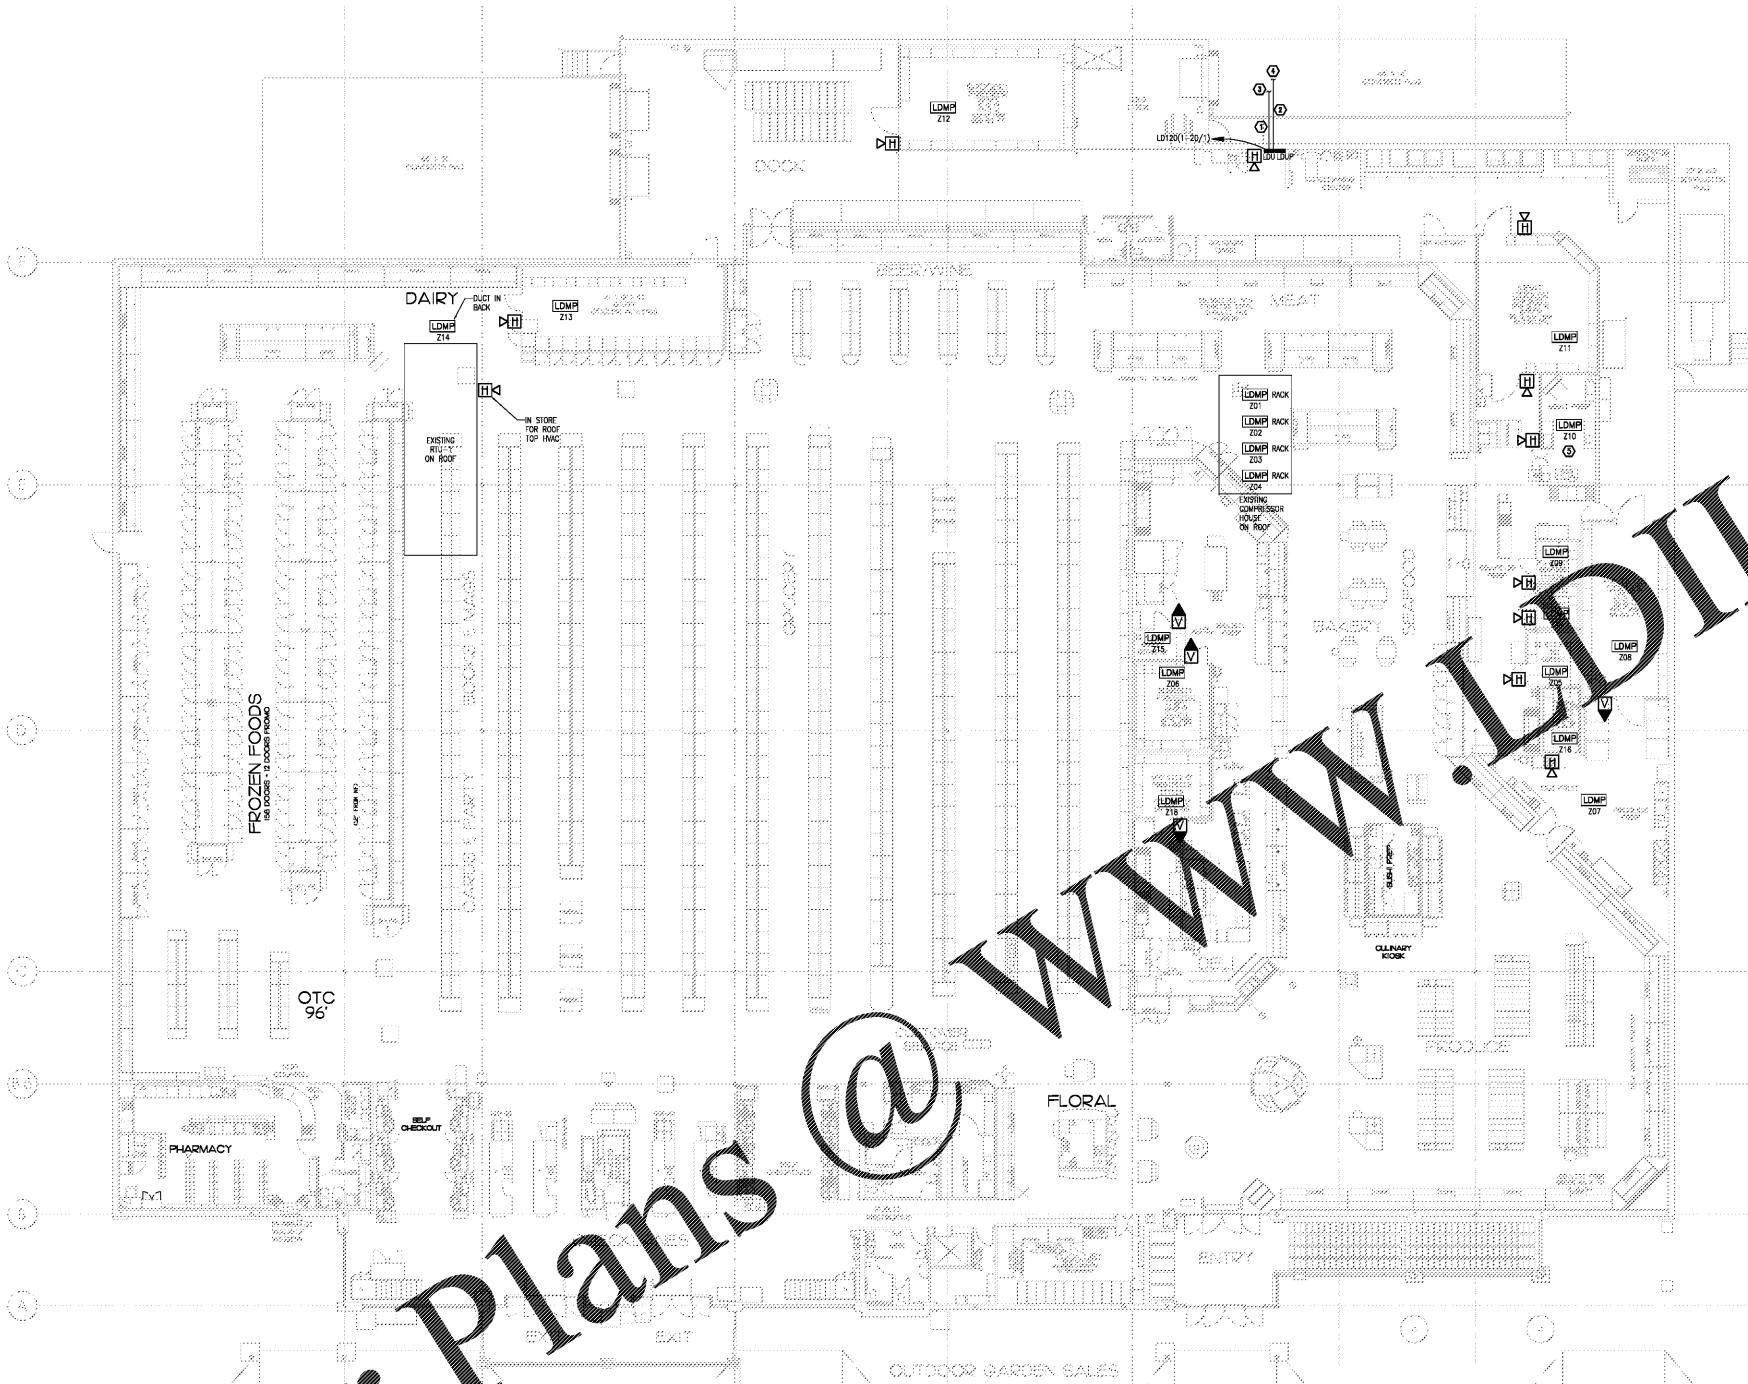

REFRIGERANT LEAK DETECTION SYMBOL LEGEND

- SEE SPECIFICATION SECTION 11 41 46 FOR FURTHER INFORMATION
- LDU** REFRIGERANT LEAK DETECTION UNIT.
 - LDMP** REFRIGERANT LEAK DETECTION CONTROL PANEL.
 - LDMP** REFRIGERANT LEAK DETECTION MONITORING POINT.
 - LDH** REFRIGERANT LEAK DETECTION HORN & STROBE UNIT.
 - LDH** REFRIGERANT LEAK DETECTION STROBE UNIT.
 - LDH** PROPOSED ROUTING OF EXHAUST TUBING.
 - LDH** PROPOSED ROUTING OF PURGE LINE
 - Z** REFRIGERANT LEAK DETECTION ZONE #
 - 1** VERIFY EXACT LOCATION OF EXHAUST TUBING TERMINATION. DO NOT TERMINATE NEAR MAN DOOR, OVERHEAD DOOR OR NEAR WHERE PEOPLE MAY BE GATHERING.
 - 2** VERIFY EXACT LOCATION OF PURGE LINE TUBING TERMINATION. TERMINATE AT ROOF. MAKE ROOF SEAL AS REQUIRED. ORDER PREVENTED ENTRY OF WATER. DO NOT TERMINATE NEAR REFRIGERATION UNIT. DO NOT TERMINATE NEAR LINE ENTRY AND MAKE EXACT LOCATION OF TERMINATION IN THE FIELD PRIOR TO ROUGH-IN.
 - 3** WHEN THE LDMP IS IN THE SAME ZONE, THE TUBING TO THE PANEL SHOULD BE THE SAME LENGTH.
- NOTE:
 1. LOCATION OF ALL EQUIPMENT SHALL BE VERIFIED AND COORDINATED IN THE FIELD WITH KROGER PROJECT MANAGER, REFRIGERATION CONTRACTOR, EMS CONTRACTOR AND THE EQUIPMENT MANUFACTURER PRIOR TO ROUGH-IN.
 2. ALL CONDUIT SHALL BE RUN CONCEALED. WHEN HORN / STROBE OR STROBE ONLY UNITS ARE MOUNTED ON COLUMNS, ALL CONDUIT AND WIRING SHALL BE RUN CONCEALED IN THE COLUMN.

ZONE SCHEDULE

ZONE NUMBER	ZONE DESCRIPTION
201	RACK A
202	RACK C
203	RACK B
204	RACK D
205	DELI COOLER
206	BAKERY FREEZER
207	PRODUCE PREP
208	PRODUCE COOLER
209	SEAFOOD COOLER
210	MEAT PREP
211	MEAT COOLER
212	GROCERY FREEZER
213	DAIRY COOLER
214	INAC (RU-1)
215	BAKERY REFRIGERATOR
216	FLORAL COOLER
217	SEAFOOD FREEZER
218	FRESH FOOD COOLER

INTERPLAN
 ARCHITECTURE
 ENGINEERING
 INTERIOR DESIGN
 PROJECT MANAGEMENT

404 COURTLAND STREET
 SUITE 100
 ORLANDO, FLORIDA 32804
 PH 407.645.5208
 FX 407.629.9124

THIS DOCUMENT IS NOT FOR REGULATORY APPROVAL, PERMITTING, OR CONSTRUCTION.

A WITHIN THE WALLS REMODEL FOR:
KROGER STORE # 478 - MARIETTA - GA
 3162 JOHNSON FERRY RD.,
 MARIETTA, GA 30062



NO DATE REVISIONS
 REVISIONS
 PROJECT NO: 2019-0125
 DATE: 03.18.2019

LD1.0
 REFRIGERANT LEAK
 DETECTION FLOOR PLAN
 CHECKED: DS DRAWN: VLD