
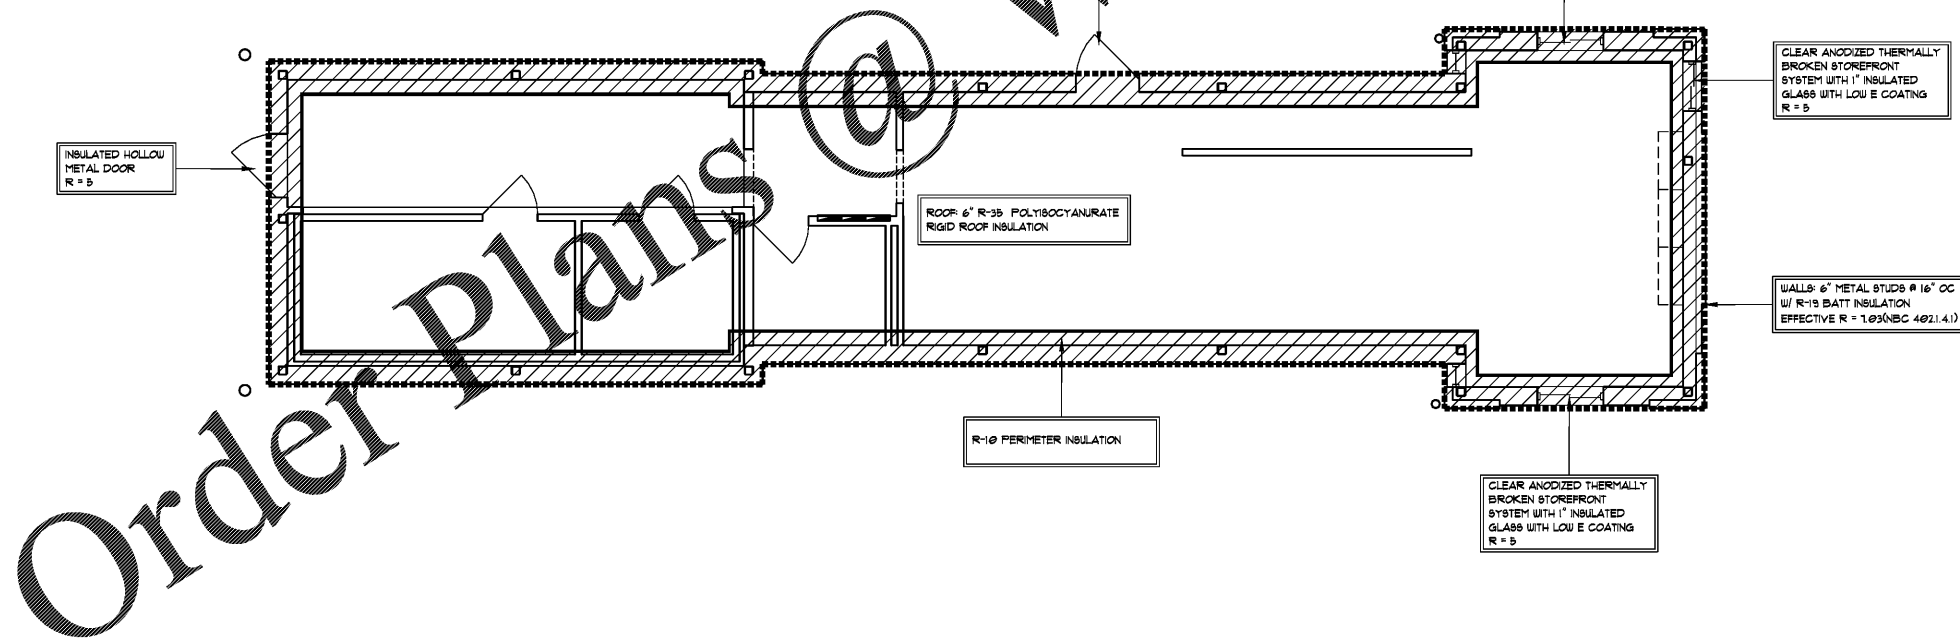


A-2 RESTAURANT OCCUPANCY:		
KITCHEN	1041 SF @ 200 SF/PERSON	6 PEOPLE
COOLER/FREEZER	254 SF	
TOTAL	1301 SF	6 PEOPLE
TOTAL BUILDING OCCUPANCY: 12 PEOPLE		

PLUMBING FIXTURES:		
OCCUPANTS:		
BUILDING OCCUPANCY:	12 PEOPLE	
ADDITIONAL OCCUPANCY:	---	
TOTAL:	12 PEOPLE	
WATER CLOSETS		
WOMEN	6 PEOPLE @ 1 WC/15 P = 1WC	
MEN	6 PEOPLE @ 1 WC/15 P = 1WC	
LAVATORIES		
	6 PEOPLE @ 1 LAV/200 P = 1 LAV	
	6 PEOPLE @ 1 LAV/200 P = 1 LAV	

LEGEND:	
C.O.L.	CALCULATED OCCUPANT LOAD
A.O.L.	ACTUAL OCCUPANT LOAD
E.W.	EGRESS WIDTH
P.H.	PANIC HARDWARE

1 LIFE SAFETY PLAN  
BCS 0.2 SCALE: 3/16" = 1'-0"

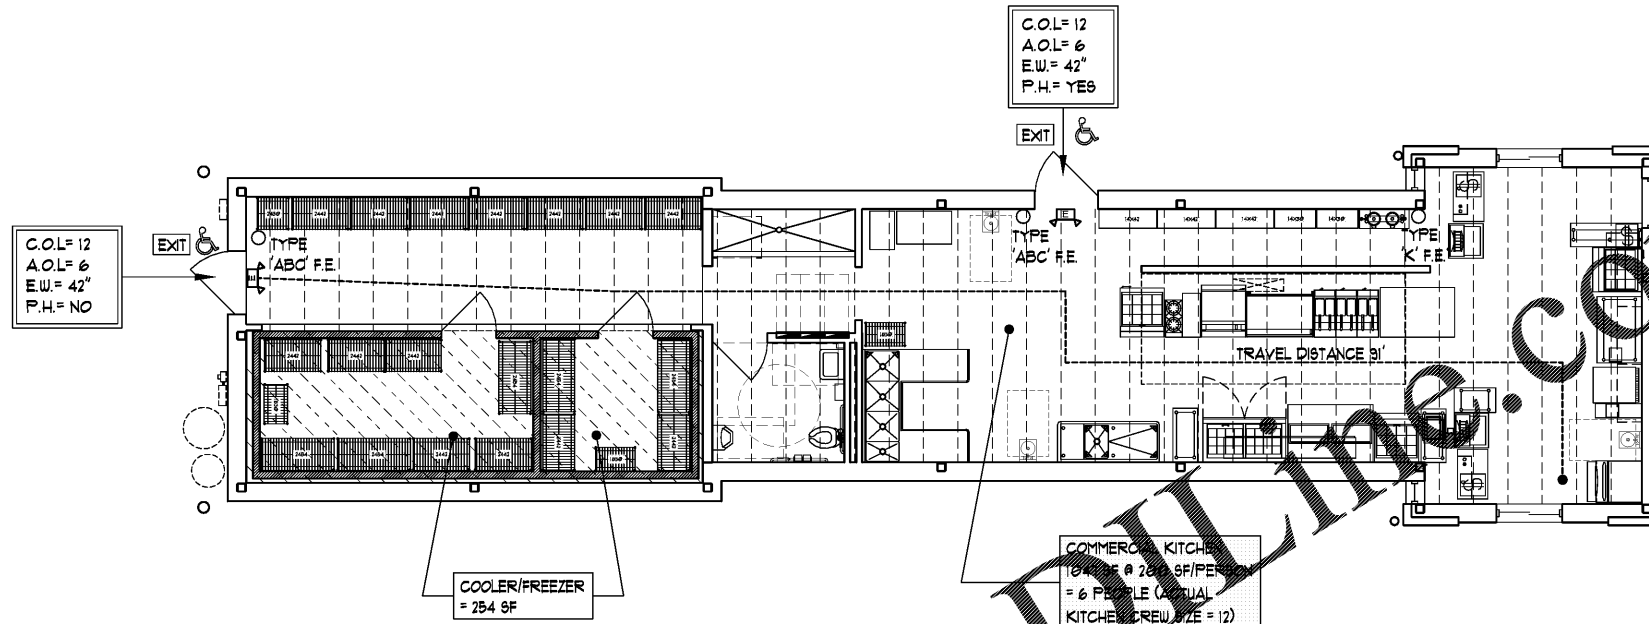

2 ENERGY CODE PLAN  
BCS 0.2 SCALE: 3/16" = 1'-0"



NO.	DATE	DESCRIPTION

**LIFE SAFETY PLAN & ENERGY CODE**

DATE: 03-20-2019  
DRAWN BY: EDO/JHM  
CHECK BY: RML  
JOB NO.: 19-010  
SHEET: