

**Alamance Consulting Engineers**

961-F Burlington Ave.  
Gibsonville, NC 27249  
Phone: (336) 449-4558  
www.ace-nc.net  
N.C. Firm License Number C-2071



**LINDSEY ARCHITECTURE**  
125 S. Elm Street, Suite 300  
Greensboro, NC 27401  
p. 336.617.4402  
f. 336.617.4434  
www.lindseyarchitecture.com



NEW BUILDING FACILITY:  
**COOK OUT**  
4455 Main Street  
Shallotte, North Carolina

DRAWING NAME:  
**ROOF ELECTRICAL PLAN**



DRAWN: TGW  
DATE: 2/27/19  
SCALE: AS NOTED  
JOB NO.: 19021  
SHEET:

**E-3**

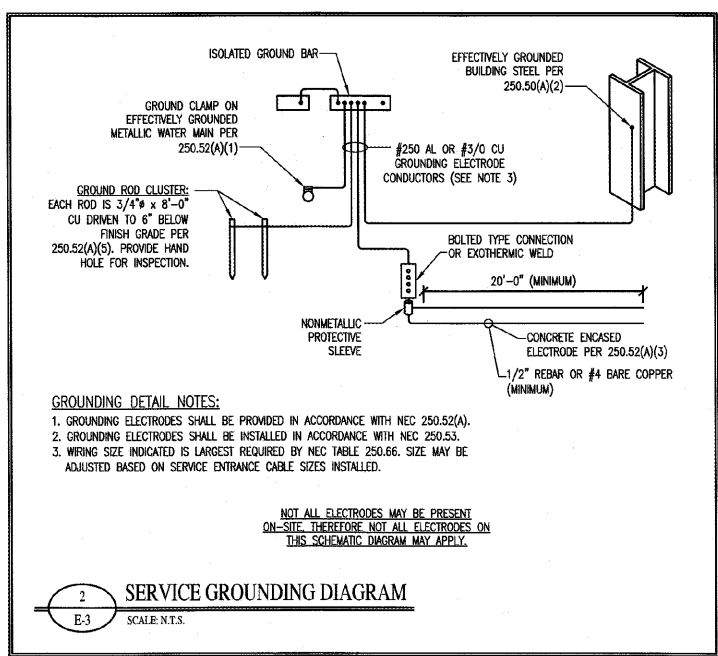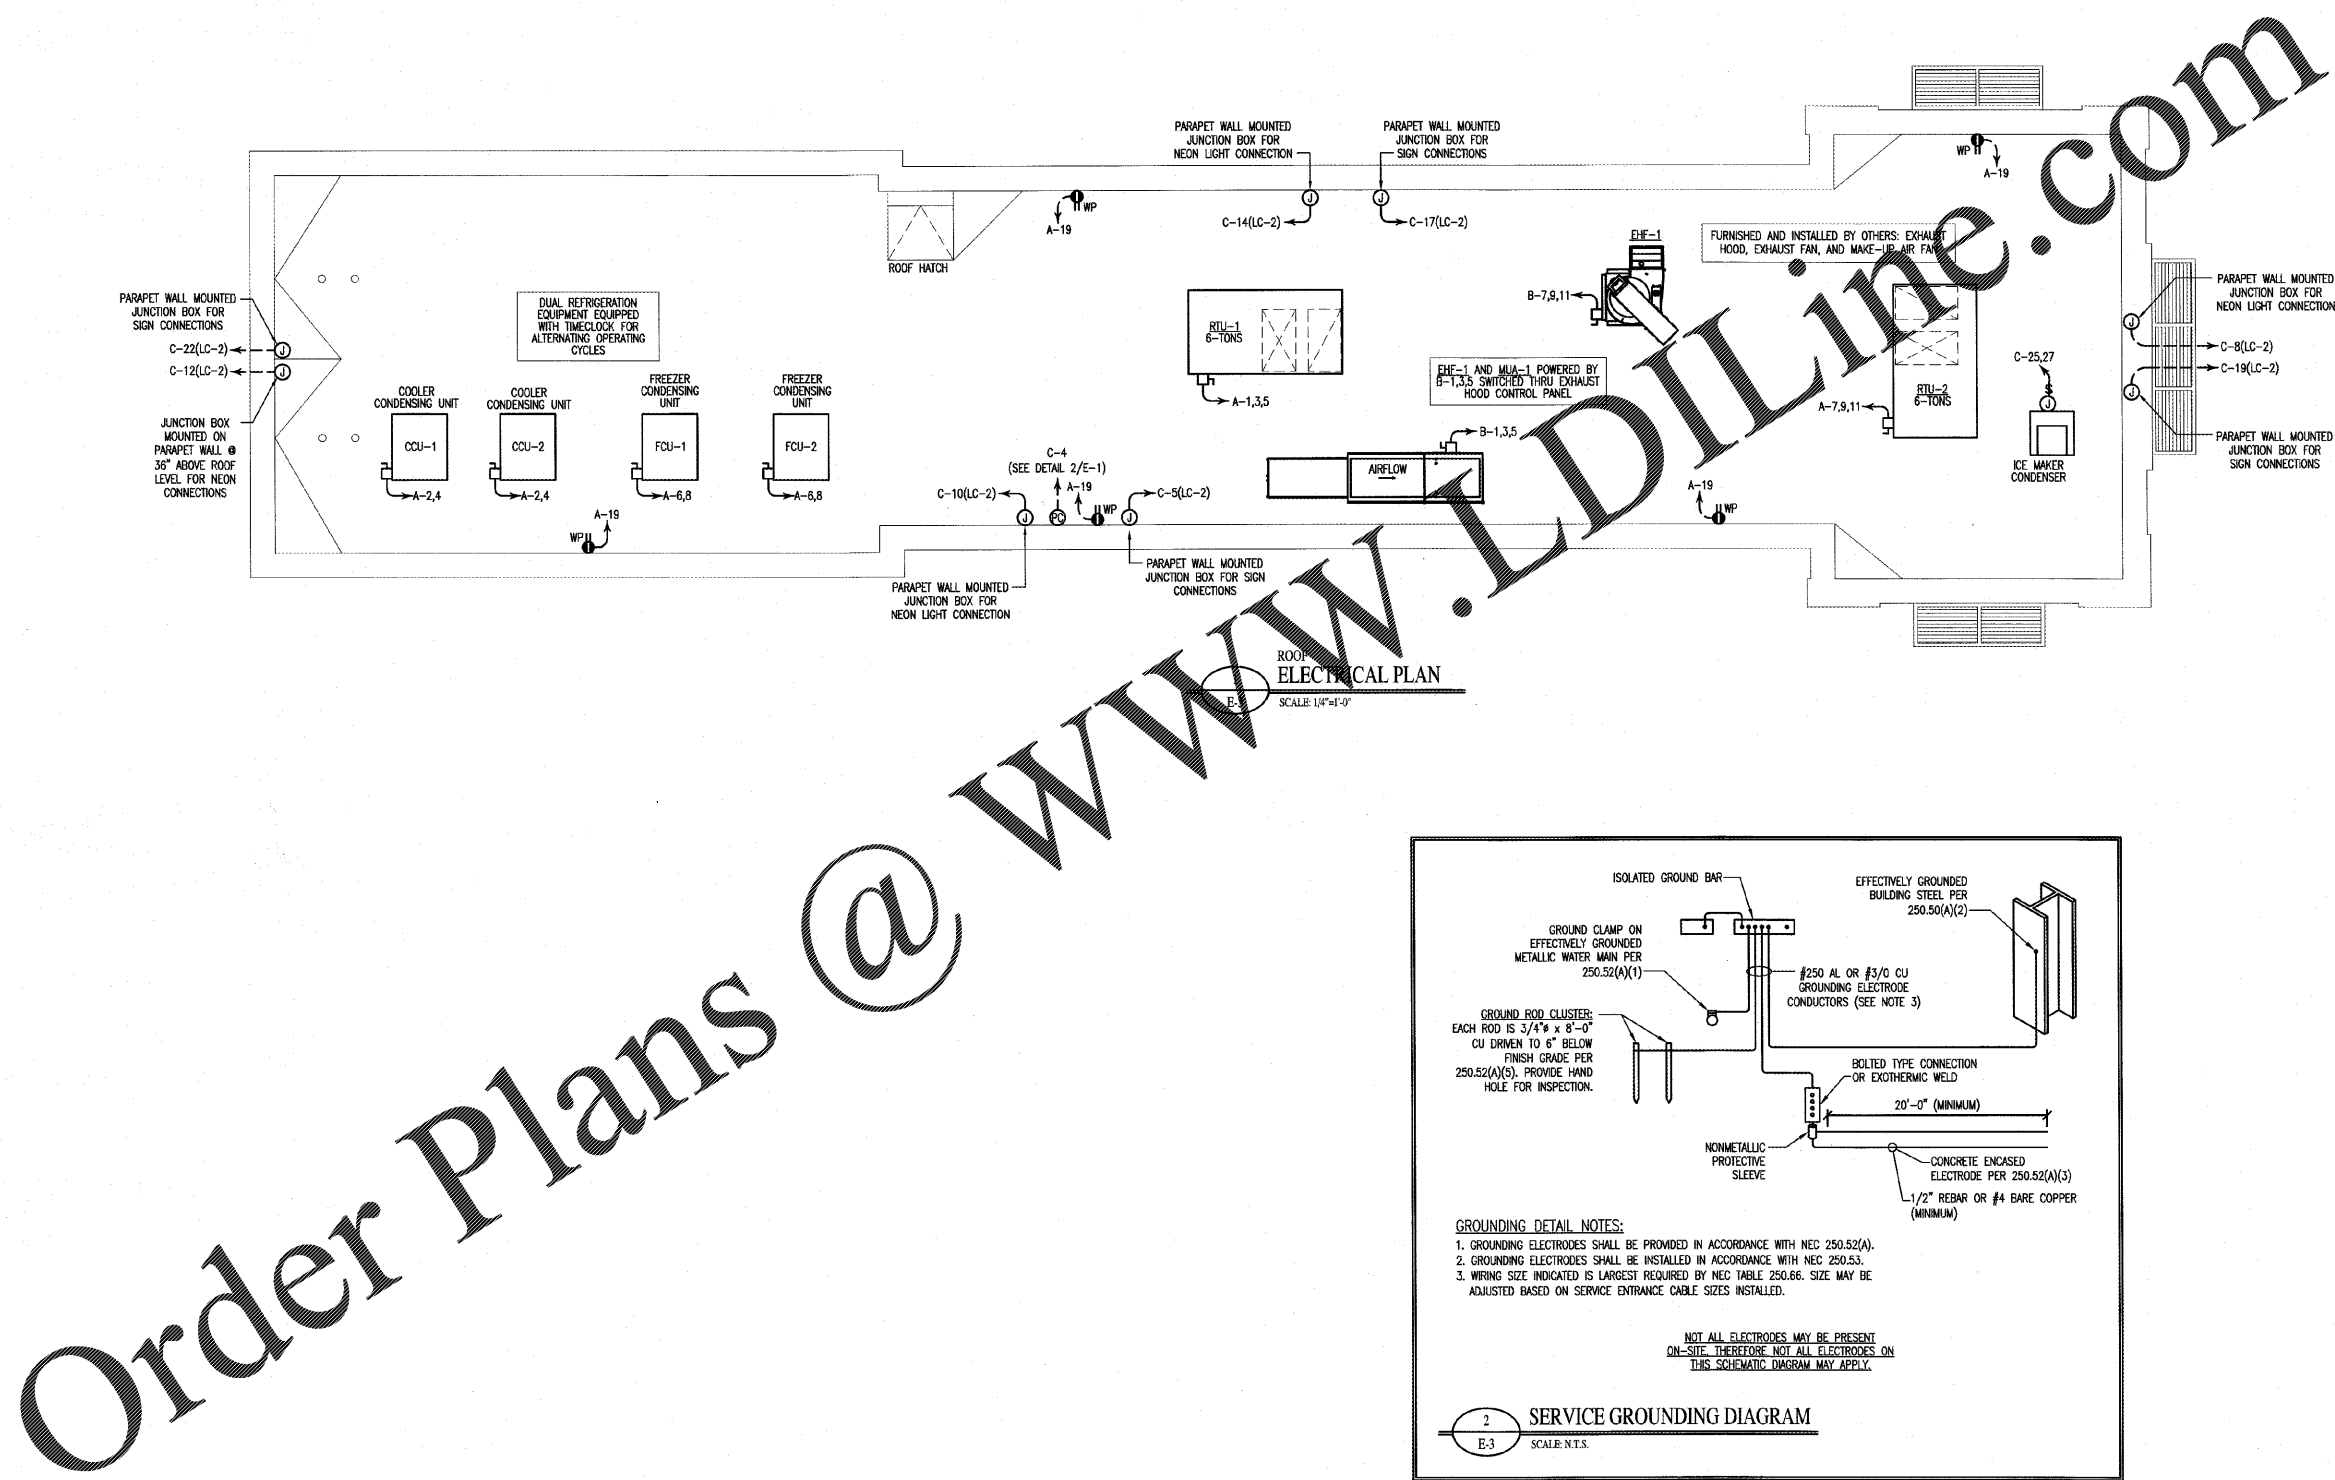

Order Plans @ WWW.LDILINE.COM